

PROJECT TEAM:

DESIGNER:
KEAN DESIGNS LTD.
5 MAIN STREET, COLD SPRING HARBOR, NY 11724
(631) 367-9696

ARCHITECT OF RECORD:
JOSEPH M. NEITZEL, R.A.
406 NORTH COUNTRY ROAD
ST. JAMES, NY 11780
(631) 862-8095

SURVEYOR:
RENNER BURGESS INC.
1 SE 4TH AVE, SUITE 205
DELRAY BEACH, FL 33483
(561) 243- 4624

CIVIL ENGINEER:
GRUBER CONSULTING ENGINEERS
2475 MERCER AVE.
WEST PALM BEACH, FL 33401
(561) 312-2041

LANDSCAPE ARCHITECT:
ENVIRONMENT DESIGN GROUP
139 N COUNTY ROAD #20B
PALM BEACH, FL 33480
(561) 832-4600

PROPOSED RESIDENCE FOR:

"MIRAFLORES"

260 MIRAFLORES DRIVE
TOWN OF PALM BEACH, FLORIDA



*RENDERING FOR REPRESENTATIONAL PURPOSES ONLY. NOT TO SCALE.

RECEIVED

By yfigueroa at 10:08 am, Mar 11, 2024

FIRST RESUBMISSION

2024-03-11

FINAL SUBMITTAL

2023-12-07

SECOND SUBMITTAL

2023-11-20

FIRST SUBMITTAL

2023-11-02

SCOPE OF WORK:

- NEW 2-STORY SINGLE-FAMILY RESIDENCE WITH ATTACHED GARAGE
- NEW HARDSCAPE INCLUDING IN-GROUND POOL
- NEW LANDSCAPE AND ASSOCIATED DRAINAGE

PROJECTED ARCOM HEARING:

2024-03-27

2024-01-24: (DEFERRED TO 3/27 HEARING)

SHEET INDEX :

GENERAL REQUIREMENTS:

- D1. (CS-1) COVER SHEET
D2. PROPERTY SURVEY
D3/D4. (VM-1) VICINITY & LOCATION MAP
D5. (PS-1.0a) PHOTO SHEET (NEIGHBORHOOD)
D5. (PS-1.0b) PHOTO SHEET (NEIGHBORHOOD)
D5. (PS-1.1a) PHOTO SHEET (SITE)
D5. (PS-1.1b) PHOTO SHEET (SITE)
D6. (SP-1.0) SITE PLAN
D6. (SP-1.1) RENDERED SITE PLAN
D7/F1. (ZD-1.0) ZONING DIAGRAM
D7/F1. (ZD-1.1) CUBIC CONTENT CALCULATIONS

NEW CONSTRUCTION:

- F2. (A-1.1) FIRST FLOOR PLAN
F2. (A-1.2) SECOND FLOOR PLAN
F3. (A-1.3) ROOF PLAN
F4. (A-2.0) FRONT & RIGHT SIDE EXTERIOR ELEVS.
F4. (A-2.1) REAR & LEFT SIDE EXTERIOR ELEVS.
F5. (A-2.2) COLOR ELEVATIONS W/ LANDSCAPING
F5. (A-2.2a) COLOR ELEVATIONS W/O LANDSCAPING
F5/18. (A-2.3) EXTERIOR MATERIALS AND FINISHES
F6. (A-2.4) STREETScape ELEVATIONS
F7. (A-4.0) TYPICAL WALL SECTION
F7. (A-5.0) EAVE AND RAKE DETAILS
F7. (A-6.1) PORTICO DETAILS
F7. (A-6.1a) PORTICO DETAILS
F7. (A-6.2) EXTERIOR DETAILS
F7. (A-6.2a) EXTERIOR DETAILS
F7. (A-6.2b) EXTERIOR DETAILS
F7. (A-6.3) BAY WINDOW DETAILS
F8. (A-3.0) BUILDING SECTION DIAGRAMS
F8. (A-3.1) BUILDING SECTION DIAGRAMS
F8. (A-3.2) BUILDING SECTION DIAGRAMS
F9. (A-3.3) YARD SECTION DIAGRAMS
F9. (A-3.4) YARD SECTION DIAGRAMS
F9. (A-3.5) YARD SECTION DIAGRAMS
F10/I6. (CR-1.0) COLOR RENDERINGS (W/ PLANTING)
F10/I6. (CR-1.1) COLOR RENDERINGS (W/O PLANTING)
F11/I7. (A-6.4) FENCES, WALLS, AND GATES
F11/I7. (A-6.4a) FENCES, WALLS, AND GATES
F12/I9. (C-1) SITE CIVIL DRAINAGE PLAN/
STORMWATER MANAGEMENT PLAN
F13. (L-3.0) CONSTRUCTION SCREENING PLAN*
*INCLUDED IN LANDSCAPE AND HARDSCAPE (I10.)
F14. (L-5.0) CONSTRUCTION STAGING PLAN*
*INCLUDED IN LANDSCAPE AND HARDSCAPE (I11.)
F14. (L-6.0) TRUCK LOGISTICS PLAN*
* INCLUDED IN LANDSCAPE AND HARDSCAPE (I11.)

PRESENTED BY THE OFFICE OF:



KEAN DESIGNS LTD.

5 MAIN STREET
COLD SPRING HARBOR
NEW YORK, 11724

T: +1 (631)-367-9696
E: info@keandesigns.com

SHEET INDEX : CONT'D

LANDSCAPE AND HARDSCAPE:

- I3. (L-7.0) PROPOSED LANDSCAPE &HARDSCAPE PLANS
I2, I4. (L-7.1) SITE CALCS & OPEN SPACE GRAPHICS
I3. (L-8.0) LANDSCAPE PLAN
(L-8.1) PLANT SCHEDULE AND
TOWN OF PALM BEACH LANDSCAPE LEGEND
(L-9.0) LANDSCAPE LIGHTING PLAN
I1. (L-1.0) EXISTING CONDITIONS INVENTORY
(L-2.0) DEMOLITION AND
VEGETATION ACTION PLAN
I10. (L-3.0) CONSTRUCTION SCREENING PLAN
(L-4.0) EXISTING LANDSCAPE BUFFER IMAGES
I11. (L-5.0) CONSTRUCTION STAGING PLAN
I11. (L-6.0)CONSTRUCTION LOGISTICS PLAN
(L-8.2) PLANTING DETAILS AND SPECIFICATIONS
(L-8.3) PROPOSED PLANT IMAGES
(L-8.4) PROPOSED PLANT IMAGES
(L-8.5) PROPOSED PLANT IMAGES
15. NOT REQUIRED
16. (CR-1.0) COLOR RENDERINGS (W/ PLANTING)*
*INCLUDED IN NEW CONSTRUCTION (F10)
16. (CR-1.1) COLOR RENDERINGS (W/O PLANTING)*
*INCLUDED IN NEW CONSTRUCTION (F10)
17. (A-6.4) FENCES, WALLS, AND GATES*
*INCLUDED IN NEW CONSTRUCTION (F11)
17. (A-6.4a) FENCES, WALLS, AND GATES*
*INCLUDED IN NEW CONSTRUCTION (F11)
18. (A-2.3) EXTERIOR MATERIAL AND FINISHES*
*INCLUDED IN NEW CONSTRUCTION (F5)
19. (C-1) SITE CIVIL DRAINAGE PLAN*
*INCLUDED IN NEW CONSTRUCTION (F5)
19. (C-1) STORMWATER MANAGEMENT PLAN
*INCLUDED IN NEW CONSTRUCTION (F12)

PROPOSED RESIDENCE FOR:
KEAN INVESTMENTS INC.


260 MIRAFLORES DRIVE

TOWN OF PALM BEACH, FLORIDA 33480
PARCEL#: 50-43-43-14-02-000-0090

PROJECT NUMBER: ARC-24-009



N
2
LOCATION PLAN
VM-1.0 SCALE: 1:500

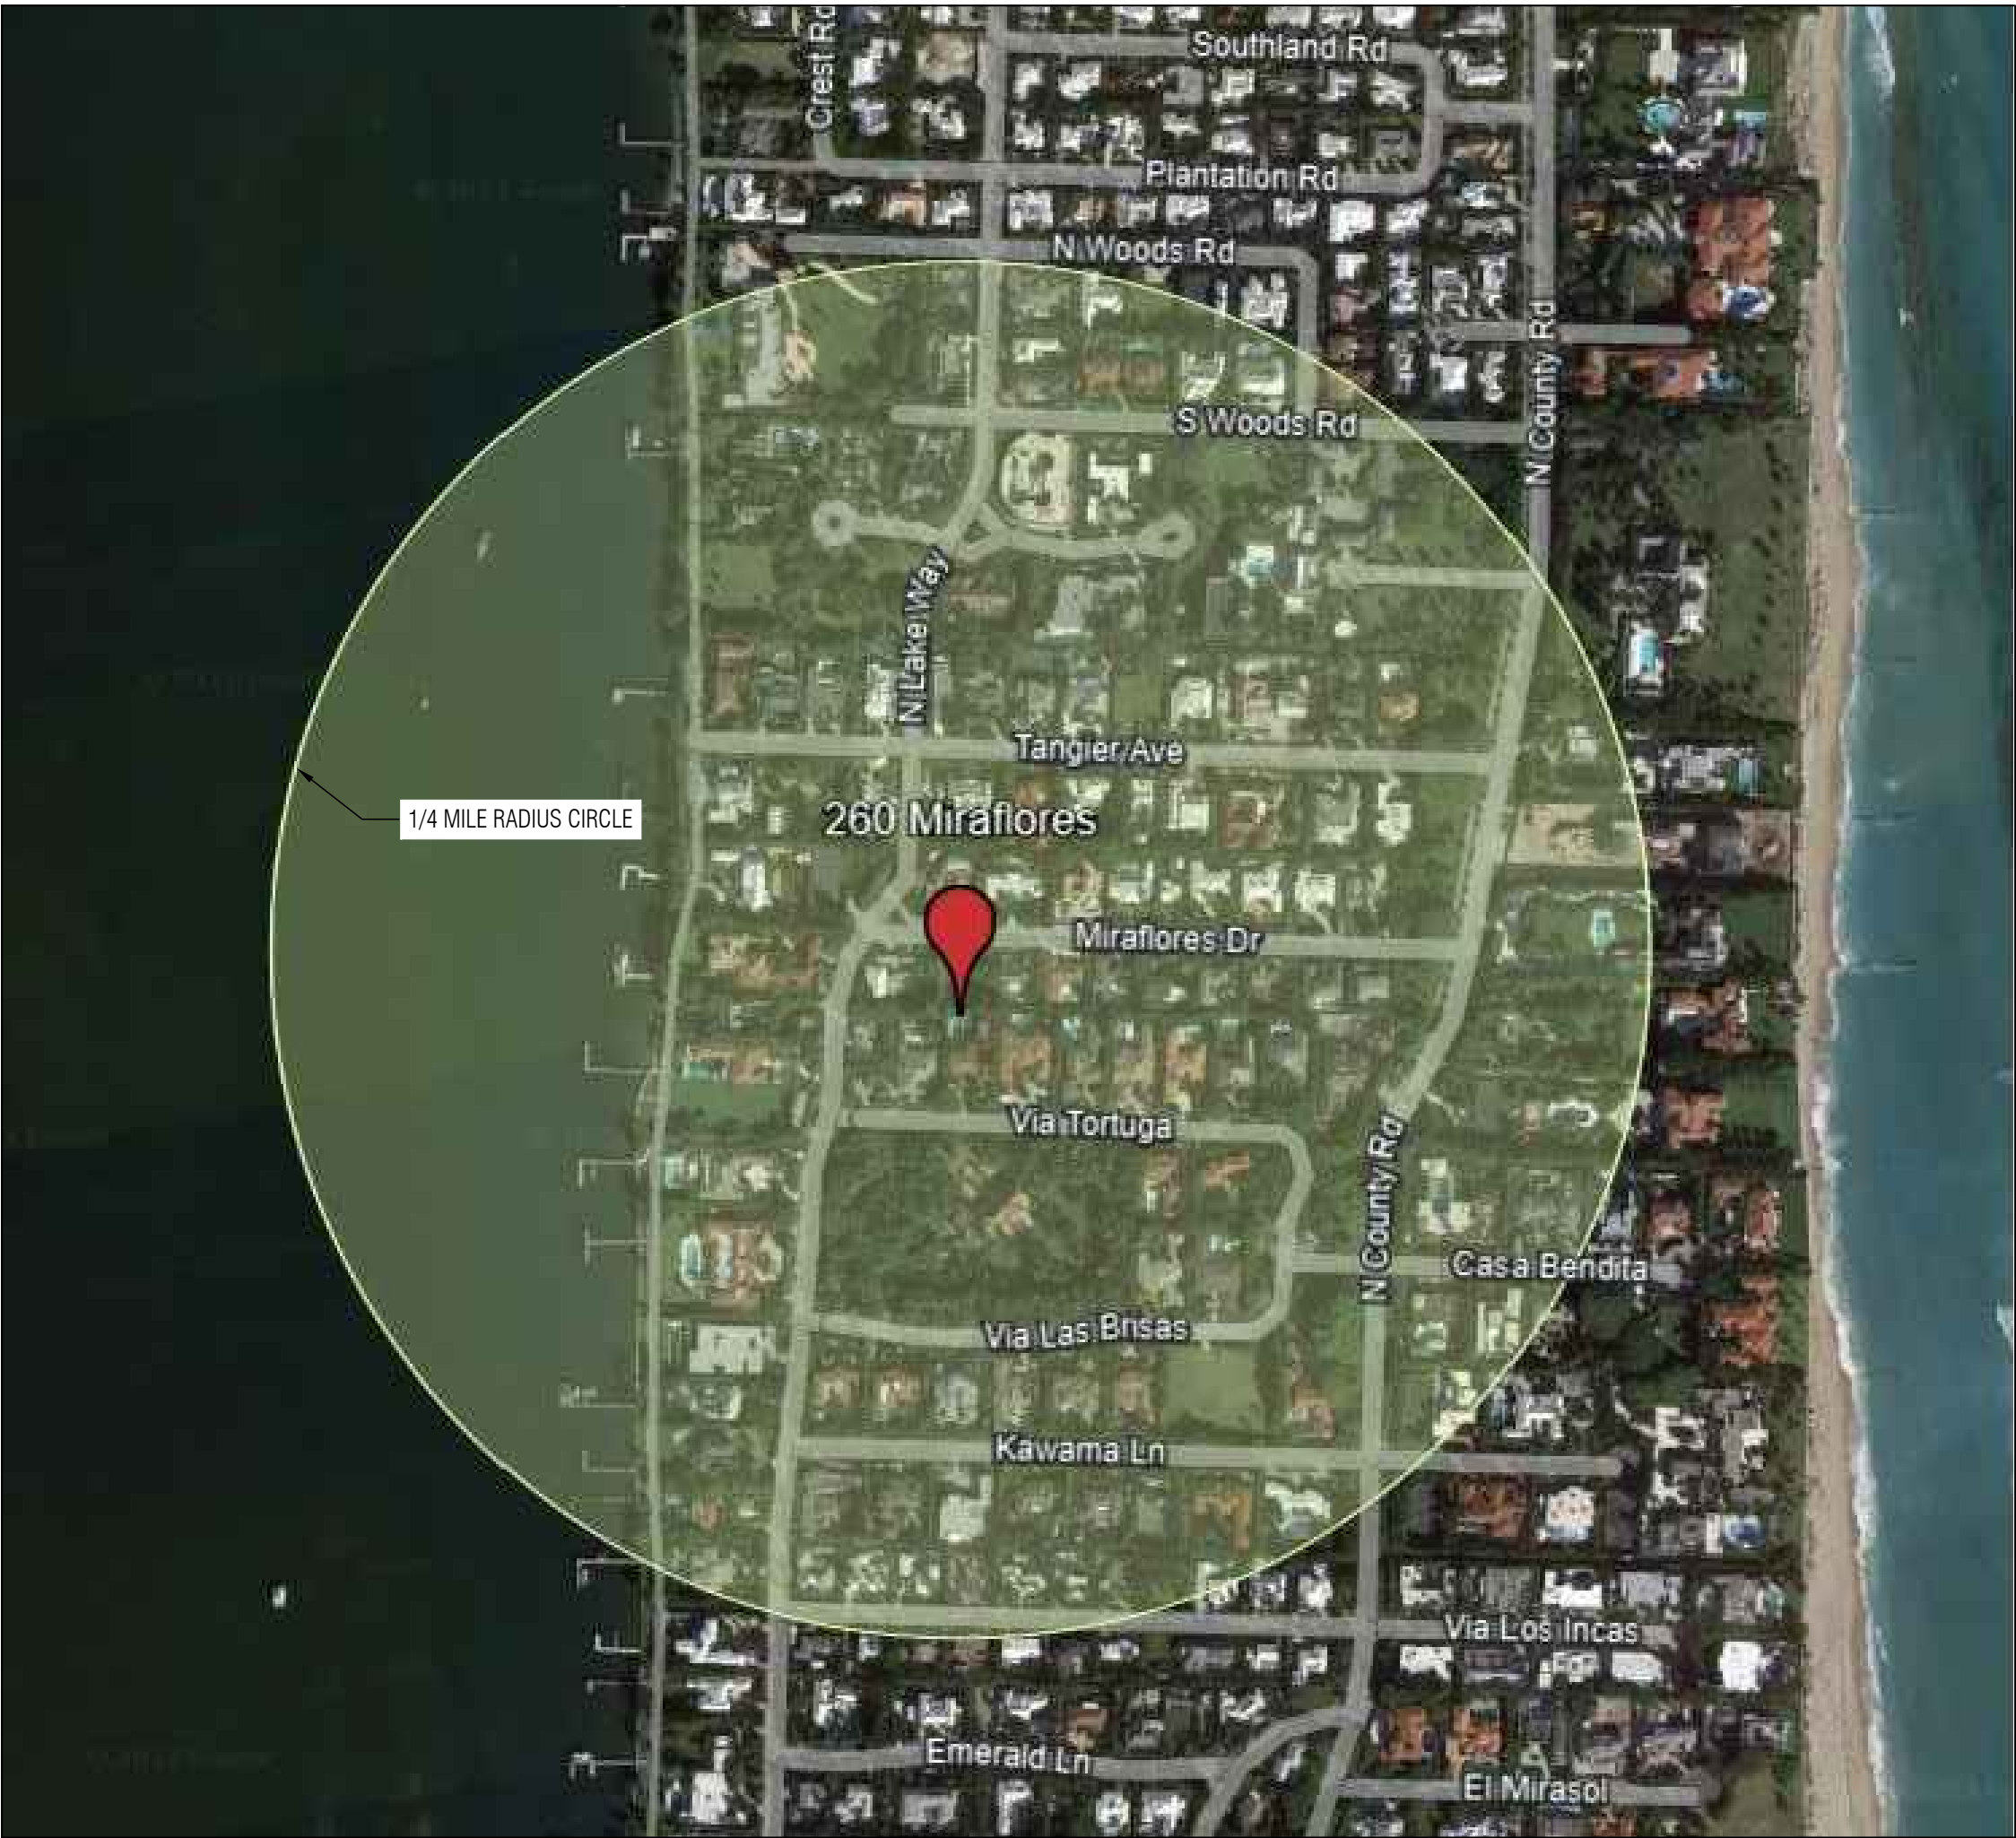

N
1
VICINITY LOCATION MAP
VM-1.0 SCALE: NTS

DATE LOG	
NO.	ISSUE DATE
1	FIRST SUBMITTAL (ARCOM) 11-03-2023
2	SECOND SUBMITTAL (ARCOM) 11-20-2023
3	FINAL SUBMITTAL (ARCOM) 12-07-2023
4	1st RESUBMISSION (ARCOM) 3-11-2024
5	
6	
7	
8	
9	
10	
11	
12	
13	
14	
15	
16	
17	
CONSULTANTS:	

PROFESSIONAL SEAL

THE DRAWINGS, SPECIFICATIONS, AND OTHER DOCUMENTS PREPARED BY KEAN DESIGNS LTD. FOR THE PROJECT ARE HEREBY SUBMITTED TO THE PROJECT. ALL OTHERS WILL BE PROVIDED. KEAN DESIGNS LTD. SHALL BE RESPONSIBLE FOR THE ACTIONS OF THESE DOCUMENTS AND SHALL BE RESPONSIBLE FOR THE ACTIONS OF THESE DOCUMENTS AND SHALL BE RESPONSIBLE FOR THE ACTIONS OF THESE DOCUMENTS. KEAN DESIGNS LTD. SHALL BE RESPONSIBLE FOR THE ACTIONS OF THESE DOCUMENTS AND SHALL BE RESPONSIBLE FOR THE ACTIONS OF THESE DOCUMENTS.

KEAN DESIGNS LTD.

5 MAIN STREET
COLD SPRING HARBOR
NEW YORK, 11724

T: +1 (631) 367-9696
E: info@keandesigns.com

PROJECT ADDRESS:

MIRAFLORES

260 MIRAFLORES DRIVE
TOWN OF PALM BEACH, FLORIDA

AS NOTED SCALE	JTD DRAWN
JOB	e 2016 KEAN DESIGNS

VM-1.0

VICINITY LOCATION MAP
AND LOCATION PLAN

DATE LOG	
NO.	ISSUE DATE
1	FIRST SUBMITTAL (ARCOM)
2	11-03-2023 SECOND SUBMITTAL (ARCOM)
3	11-20-2023 FINAL SUBMITTAL (ARCOM)
4	12-07-2023 FINAL PRESENTATION (ARCOM)
5	01-24-2024 1st RESUBMISSION (ARCOM)
6	3-11-2024
7	
8	
9	
10	
11	
12	
13	
14	
15	
16	
17	
CONSULTANTS:	



4

PS-1.0a

495 N. LAKE WAY

SCALE: NTS



3

PS-1.0a

495 N. LAKE WAY

SCALE: NTS



2

PS-1.0a

495 N. LAKE WAY

SCALE: NTS




1

PS-1.0a

496 N. LAKE WAY

SCALE: NTS

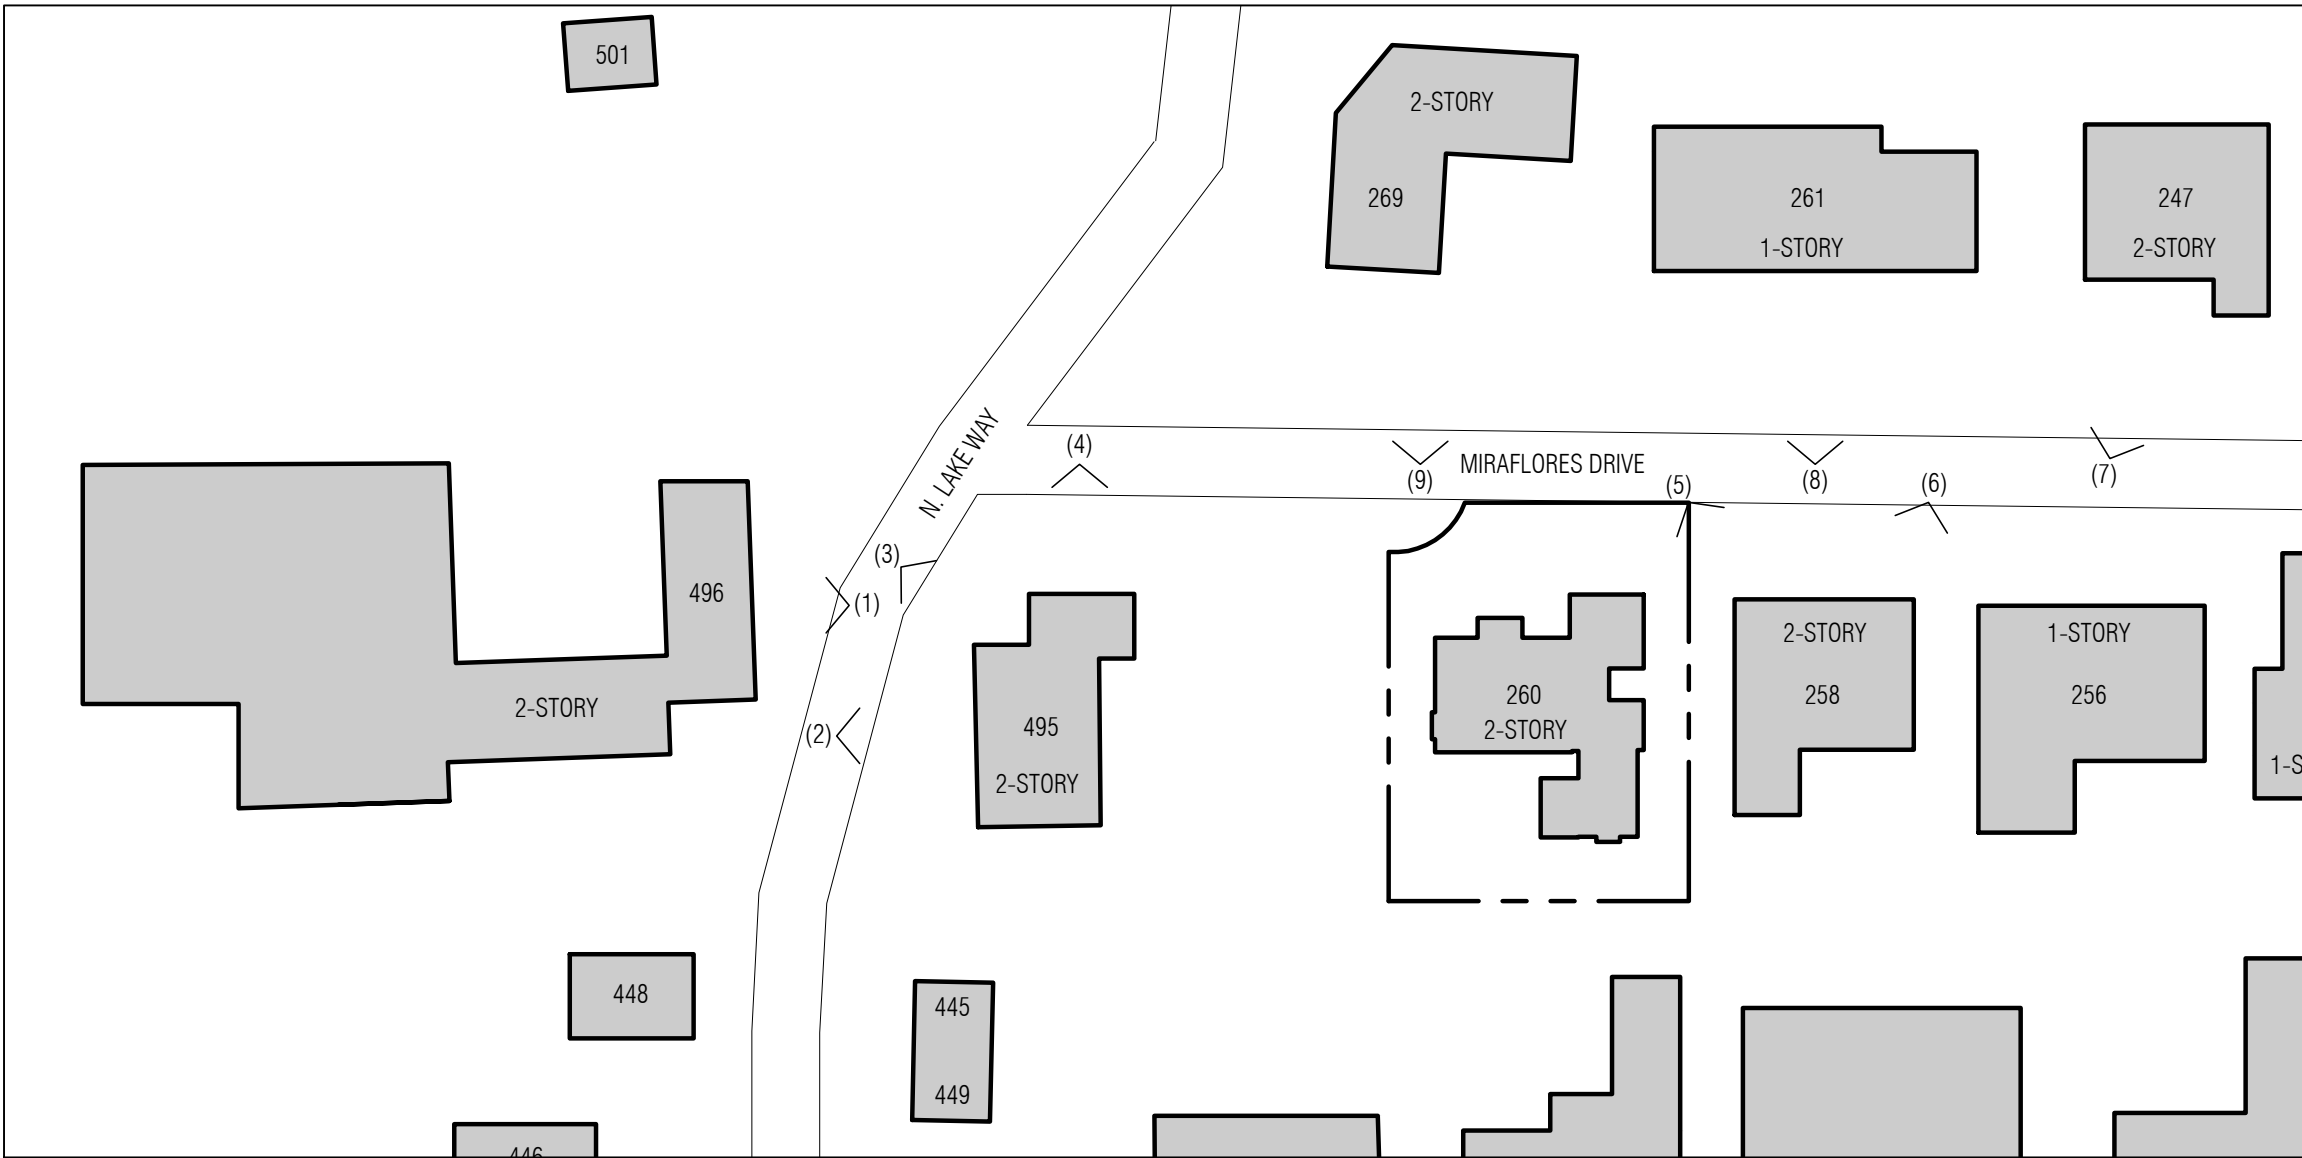

N

KP

PS-1.0a

PHOTO KEY PLAN

SCALE: NTS

PROFESSIONAL SEAL

THE DRAWINGS, SPECIFICATIONS, AND OTHER DOCUMENTS PREPARED BY KEAN DESIGNS LTD. FOR THE PROJECT, ARE HEREBY SUBMITTED TO THE PROJECT AND, SHALL BE USED ONLY FOR THE PROJECT AND SHALL NOT BE REPRODUCED OR USED FOR ANY OTHER PROJECT WITHOUT THE WRITTEN CONSENT OF KEAN DESIGNS LTD. ANY REPRODUCTION OR USE OF THESE DOCUMENTS FOR ANY OTHER PROJECT SHALL BE AT THE USER'S RISK AND WITHOUT LIABILITY TO KEAN DESIGNS LTD. ANY REPRODUCTION OR USE OF THESE DOCUMENTS FOR ANY OTHER PROJECT SHALL BE AT THE USER'S RISK AND WITHOUT LIABILITY TO KEAN DESIGNS LTD.

KEAN DESIGNS LTD.

5 MAIN STREET
COLD SPRING HARBOR
NEW YORK, 11724

T: +1 (631) 367-9696
E: info@keandesigns.com

PROJECT ADDRESS:

MIRAFLORES

260 MIRAFLORES DRIVE
TOWN OF PALM BEACH, FLORIDA

NTS
SCALE

JTD
DRAWN

e 2016
JOB

KEAN DESIGNS

PS-1.0a

PHOTO SHEET
NEIGHBORHOOD CONTEXT

DATE LOG	
NO.	ISSUE DATE
1	FIRST SUBMITTAL (ARCOM)
2	11-03-2023 SECOND SUBMITTAL (ARCOM)
3	11-20-2023 FINAL SUBMITTAL (ARCOM)
4	12-07-2023 FINAL PRESENTATION (ARCOM)
5	01-24-2024 1st RESUBMISSION (ARCOM)
6	3-11-2024
7	
8	
9	
10	
11	
12	
13	
14	
15	
16	
17	
CONSULTANTS:	



9

269 MIRAFLORES

PS-1.0b

SCALE: NTS



8

261 MIRAFLORES

PS-1.0b

SCALE: NTS



7

247 MIRAFLORES

PS-1.0b

SCALE: NTS



6

258 MIRAFLORES

PS-1.0b

SCALE: NTS




5

258 MIRAFLORES

PS-1.0b

SCALE: NTS

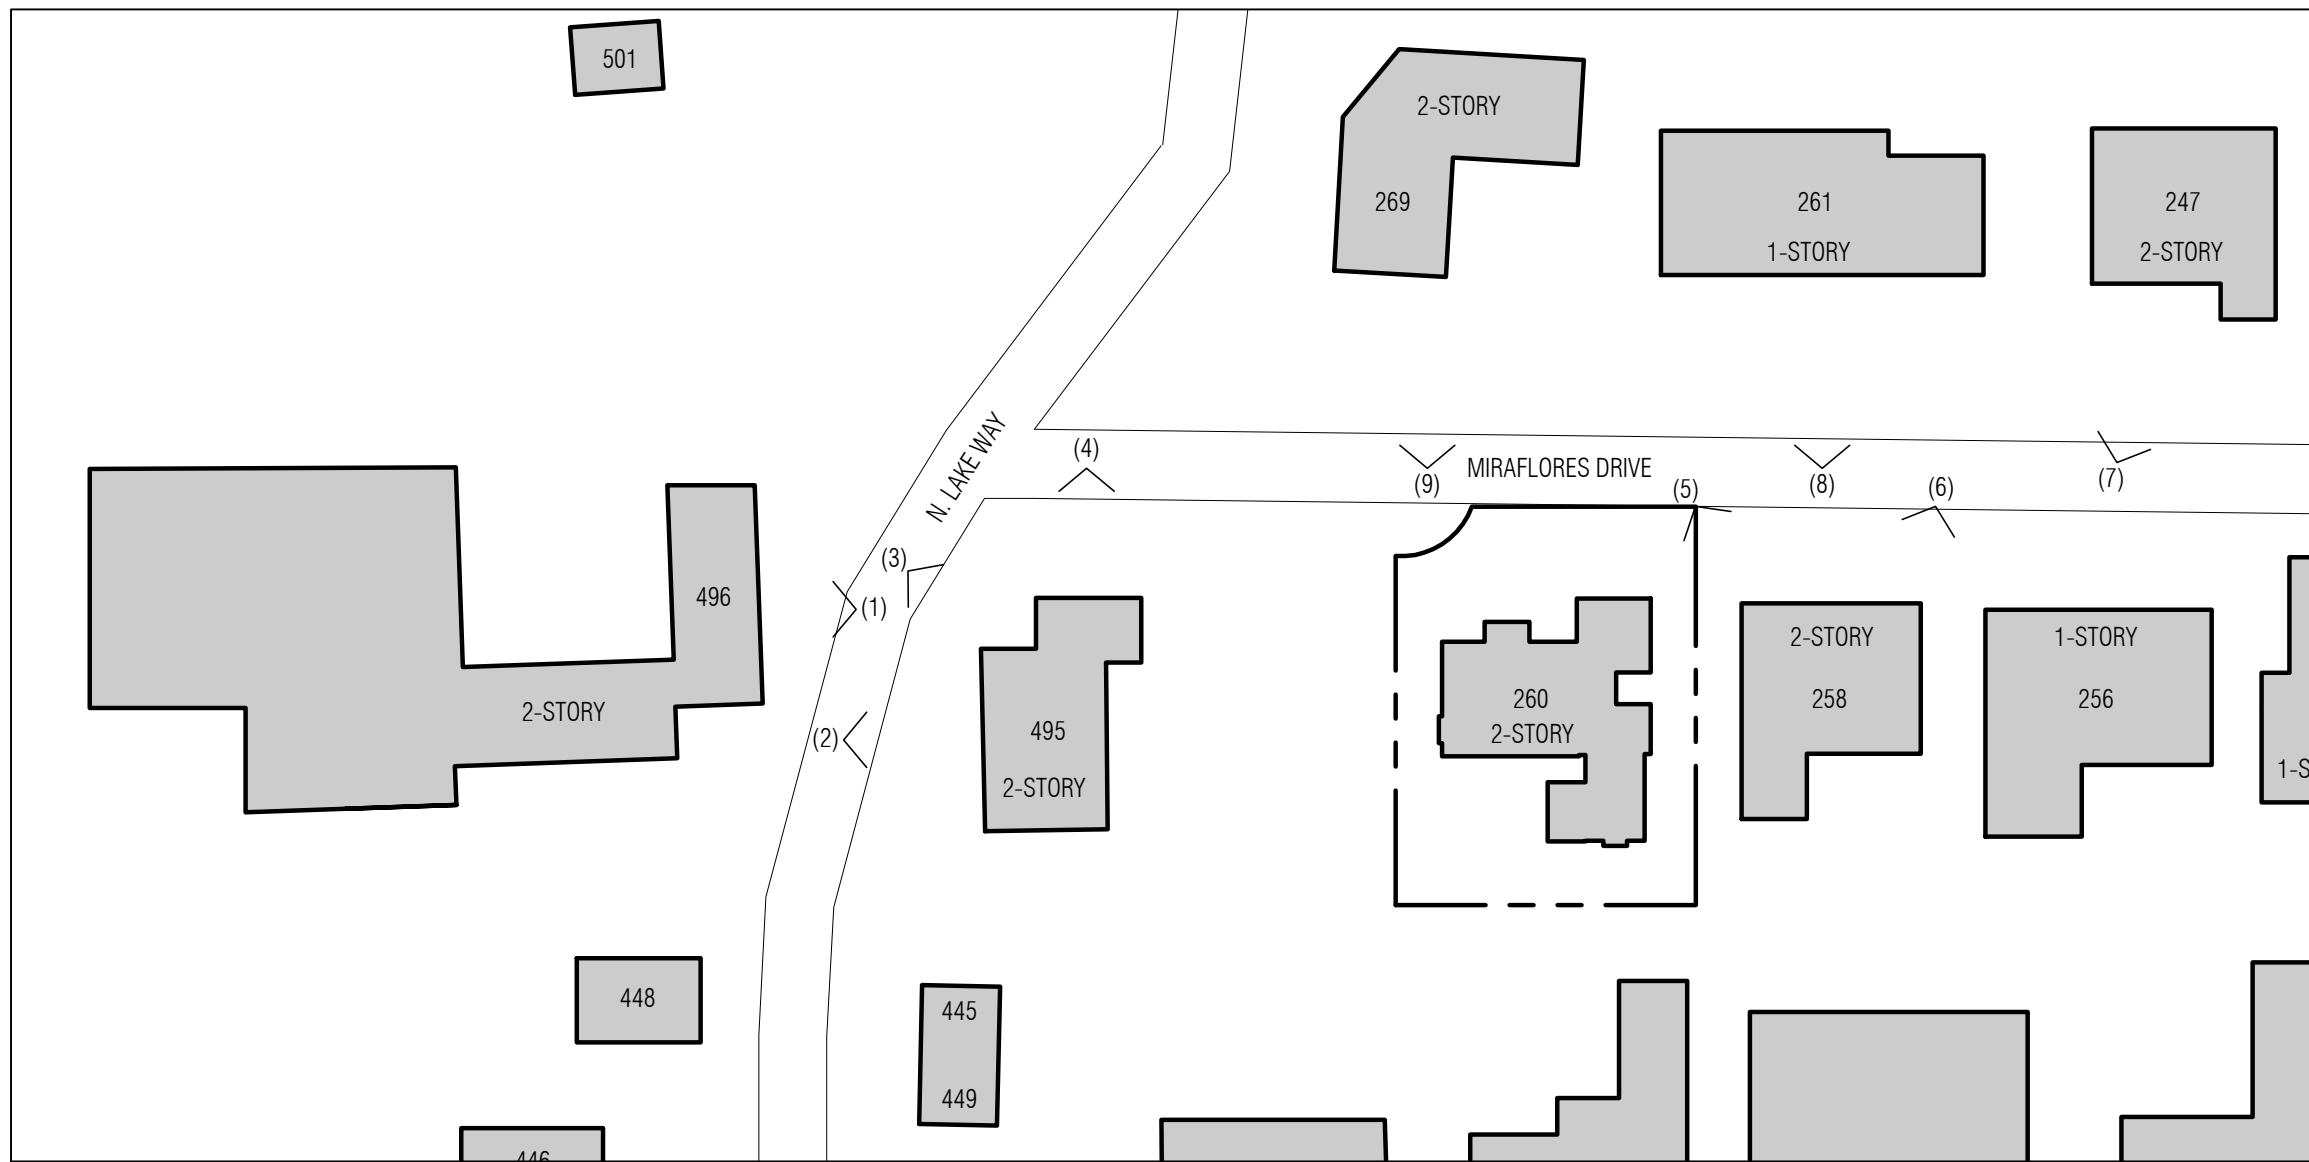

N

KP

PS-1.0b

PHOTO KEY PLAN

SCALE: NTS

PROFESSIONAL SEAL

THE DRAWINGS, SPECIFICATIONS, AND OTHER DOCUMENTS PREPARED BY KEAN DESIGNS LTD. FOR THE PROJECT ARE THE PROPERTY OF KEAN DESIGNS LTD. AND ARE NOT TO BE REPRODUCED OR TRANSMITTED IN ANY FORM OR BY ANY MEANS, ELECTRONIC OR MECHANICAL, INCLUDING PHOTOCOPYING, RECORDING, OR BY ANY INFORMATION STORAGE AND RETRIEVAL SYSTEM, WITHOUT PERMISSION IN WRITING FROM KEAN DESIGNS LTD. ANY UNAUTHORIZED REPRODUCTION OR TRANSMISSION OF THESE DOCUMENTS SHALL BE A VIOLATION OF THE COPYRIGHT LAWS OF THE UNITED STATES OF AMERICA AND OTHER COUNTRIES. THESE DOCUMENTS SHALL NOT BE USED BY THE USER OR OTHER PERSONS FOR ANY OTHER PROJECTS WITHOUT THE WRITTEN PERMISSION OF KEAN DESIGNS LTD.

KEAN DESIGNS LTD.

5 MAIN STREET
COLD SPRING HARBOR
NEW YORK, 11724

T: +1 (631) 367-9696
E: info@keandesigns.com

PROJECT ADDRESS:

MIRAFLORES

260 MIRAFLORES DRIVE
TOWN OF PALM BEACH, FLORIDA

NTS | JTD
SCALE | DRAWN

© 2016
JOB | KEAN DESIGNS

PS-1.0b

PHOTO SHEET
NEIGHBORHOOD CONTEXT



9

PS-1.1a

N PROPERTY LINE LOOKING N

SCALE: NTS



8

PS-1.1a

N PROPERTY LINE LOOKING S

SCALE: NTS



7

PS-1.1a

SW LOOKING N

SCALE: NTS



6

PS-1.1a

SW LOOKING E

SCALE: NTS



5

PS-1.1a

SE LOOKING W

SCALE: NTS



4

PS-1.1a

SE LOOKING N

SCALE: NTS



3

PS-1.1a

NW LOOKING SE

SCALE: NTS




2

PS-1.1a

NE LOOKING SW

SCALE: NTS

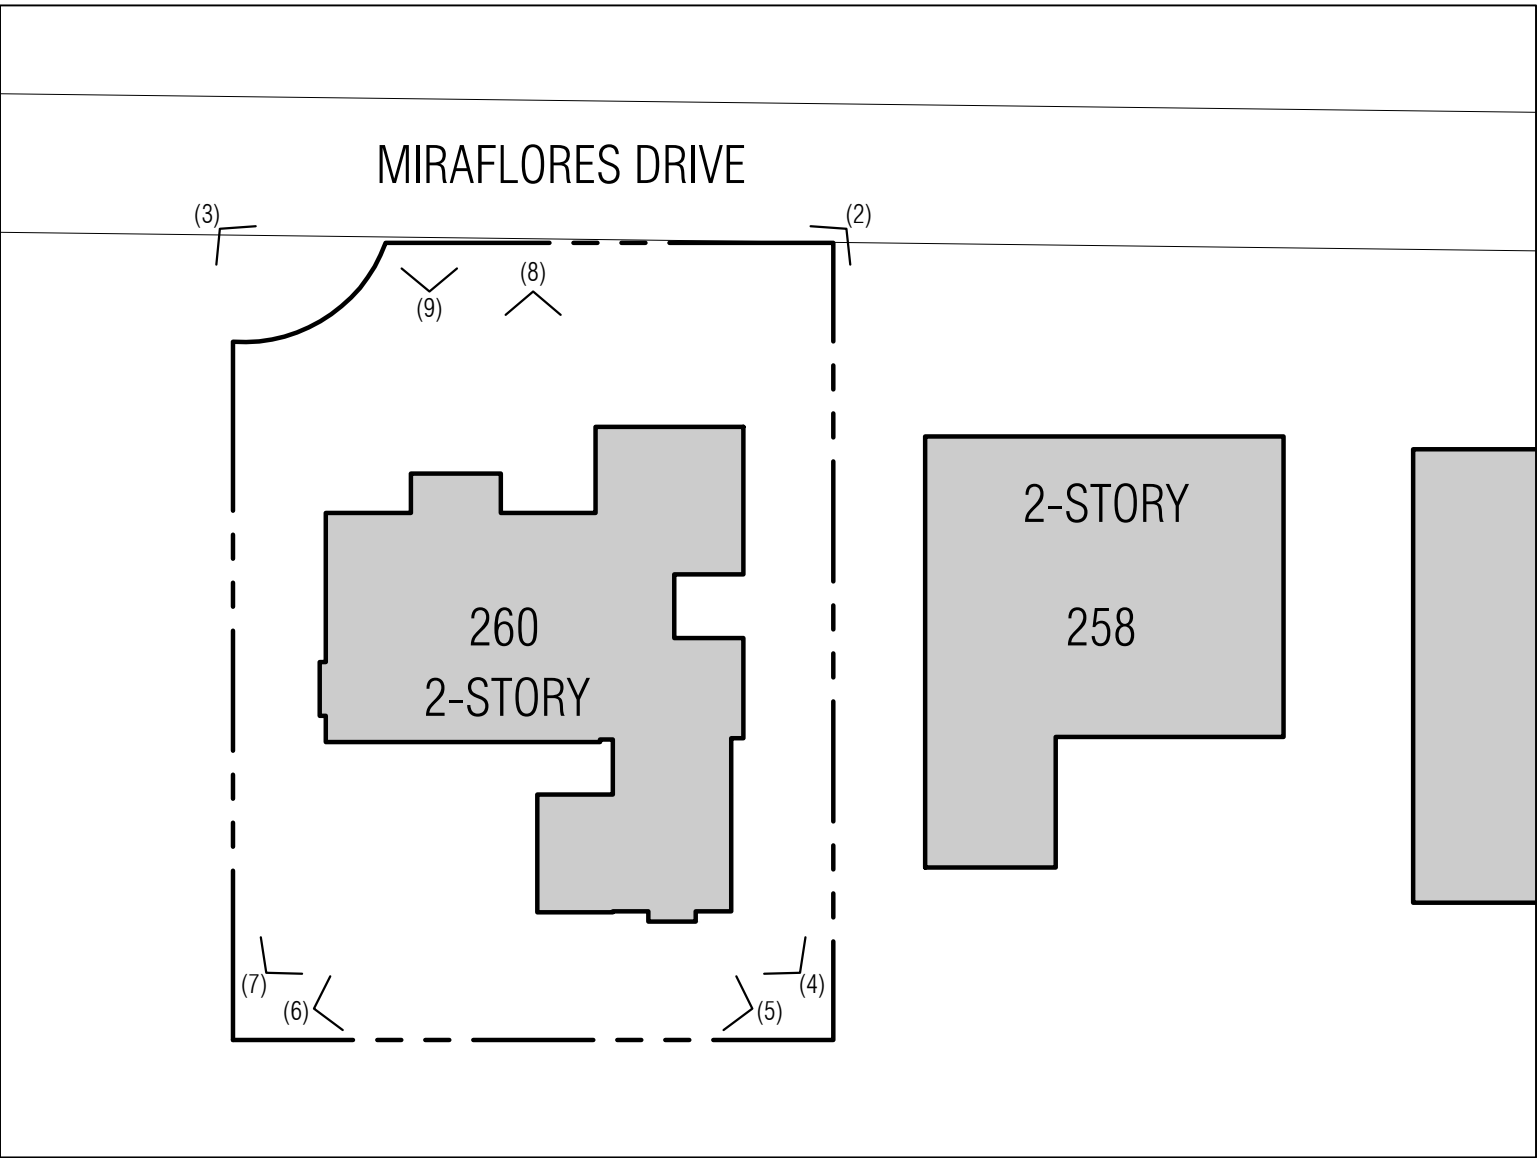

1

PS-1.1a

PHOTO KEY PLAN

SCALE: NTS

DATE LOG	
NO.	ISSUE DATE
1	FIRST SUBMITTAL (ARCOM) 11-03-2023
2	SECOND SUBMITTAL (ARCOM) 11-20-2023
3	FINAL SUBMITTAL (ARCOM) 12-07-2023
4	1st RESUBMISSION (ARCOM) 3-11-2024
5	
6	
7	
8	
9	
10	
11	
12	
13	
14	
15	
16	
17	
CONSULTANTS	

PROFESSIONAL SEAL

THE DRAWINGS, SPECIFICATIONS, AND OTHER DOCUMENTS PREPARED BY KEAN DESIGNS LTD. FOR THE PROJECT ARE THE PROPERTY OF KEAN DESIGNS LTD. NO PART OF THIS DOCUMENT SHALL BE REPRODUCED OR TRANSMITTED IN ANY FORM OR BY ANY MEANS, ELECTRONIC OR MECHANICAL, INCLUDING PHOTOCOPYING, RECORDING, OR BY ANY INFORMATION STORAGE AND RETRIEVAL SYSTEM, WITHOUT PERMISSION IN WRITING FROM KEAN DESIGNS LTD. ANY UNAUTHORIZED USE OF THIS DOCUMENT SHALL BE AT THE USER'S SOLE RISK AND WITHOUT LIABILITY TO KEAN DESIGNS LTD. FOR THE PROJECT OR FOR THE COMPLETION OF THIS PROJECT FOR OTHERS.

KEAN DESIGNS LTD.

5 MAIN STREET
COLD SPRING HARBOR
NEW YORK, 11724

T: +1 (631) 367-9696
E: info@keandesigns.com

PROJECT ADDRESS:

MIRAFLORES

260 MIRAFLORES DRIVE
TOWN OF PALM BEACH, FLORIDA

NTS | JTD
SCALE | DRAWN

JOB | e 2016
KEAN DESIGNS

PS-1.1a

PHOTO SHEET
EXISTING SITE



9

PS-1.1b

E LOOKING W

SCALE: NTS



8

PS-1.1b

SW LOOKING NE

SCALE: NTS



7

PS-1.1b

S LOOKING N

SCALE: NTS



6

PS-1.1b

SW LOOKING NE

SCALE: NTS



5

PS-1.1b

E LOOKING W

SCALE: NTS



4

PS-1.1b

NE LOOKING SW

SCALE: NTS



3

PS-1.1b

N LOOKING S

SCALE: NTS




2

PS-1.1b

NW LOOKING SE

SCALE: NTS

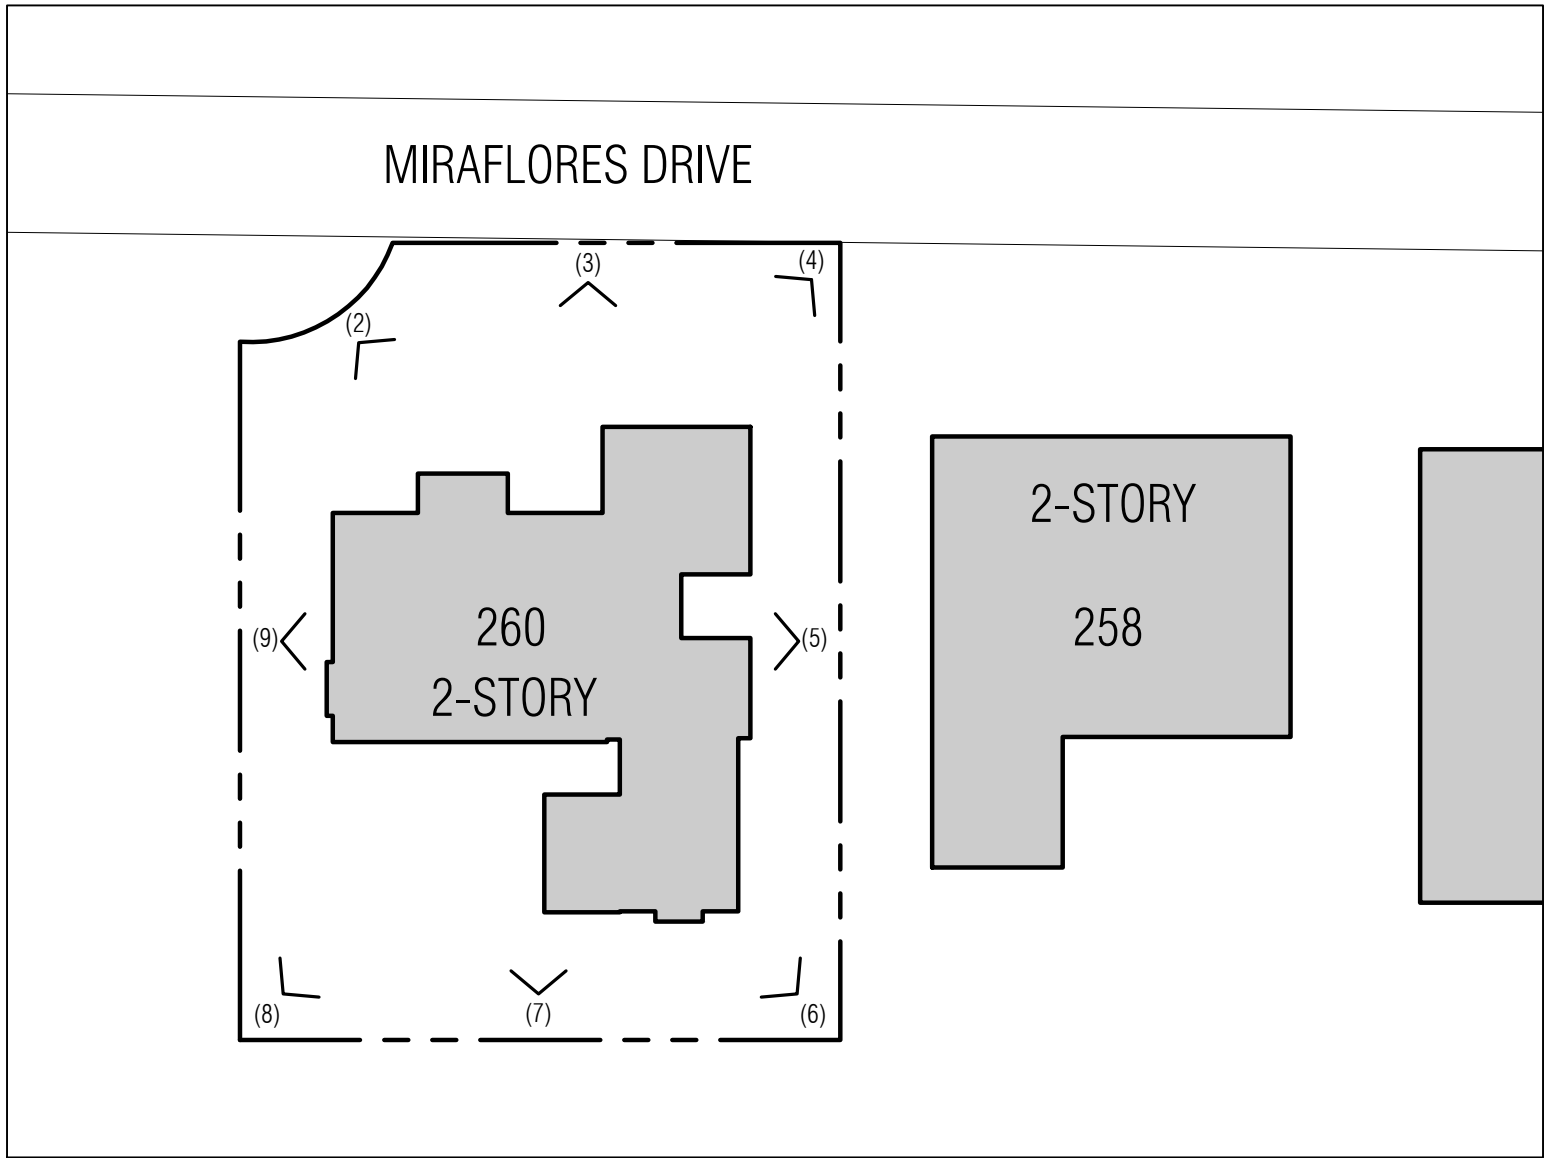

1

PS-1.1b

PHOTO KEY PLAN

SCALE: NTS

DATE LOG	
NO.	ISSUE DATE
1	1st RESUBMISSION (ARCOM)
2	3-11-2024
3	
4	
5	
6	
7	
8	
9	
10	
11	
12	
13	
14	
15	
16	
17	
CONSULTANTS	

PROFESSIONAL SEAL

THE DRAWINGS, SPECIFICATIONS, AND OTHER DOCUMENTS PREPARED BY KEAN DESIGNS LTD. FOR THE PROJECT, ARE HEREBY SUBMITTED TO THE PROJECT AND, SHALL BE THE PROPERTY OF KEAN DESIGNS LTD. AND SHALL REMAIN THE PROPERTY OF KEAN DESIGNS LTD. ANY REUSE OR REPRODUCTION OF THESE DOCUMENTS WITHOUT THE WRITTEN CONSENT OF KEAN DESIGNS LTD. IS STRICTLY PROHIBITED. ANY SUCH REUSE OR REPRODUCTION SHALL BE AT THE USER'S SOLE RISK AND WITHOUT LIABILITY TO KEAN DESIGNS LTD.

KEAN DESIGNS LTD.

5 MAIN STREET
COLD SPRING HARBOR
NEW YORK, 11724

T: +1 (631) 367-9696
E: info@keandesigns.com

PROJECT ADDRESS:

MIRAFLORES



260 MIRAFLORES DRIVE
TOWN OF PALM BEACH, FLORIDA

NTS | JTD
SCALE | DRAWN

JOB | e 2016
KEAN DESIGNS

PS-1.1b

PHOTO SHEET
EXISTING SITE

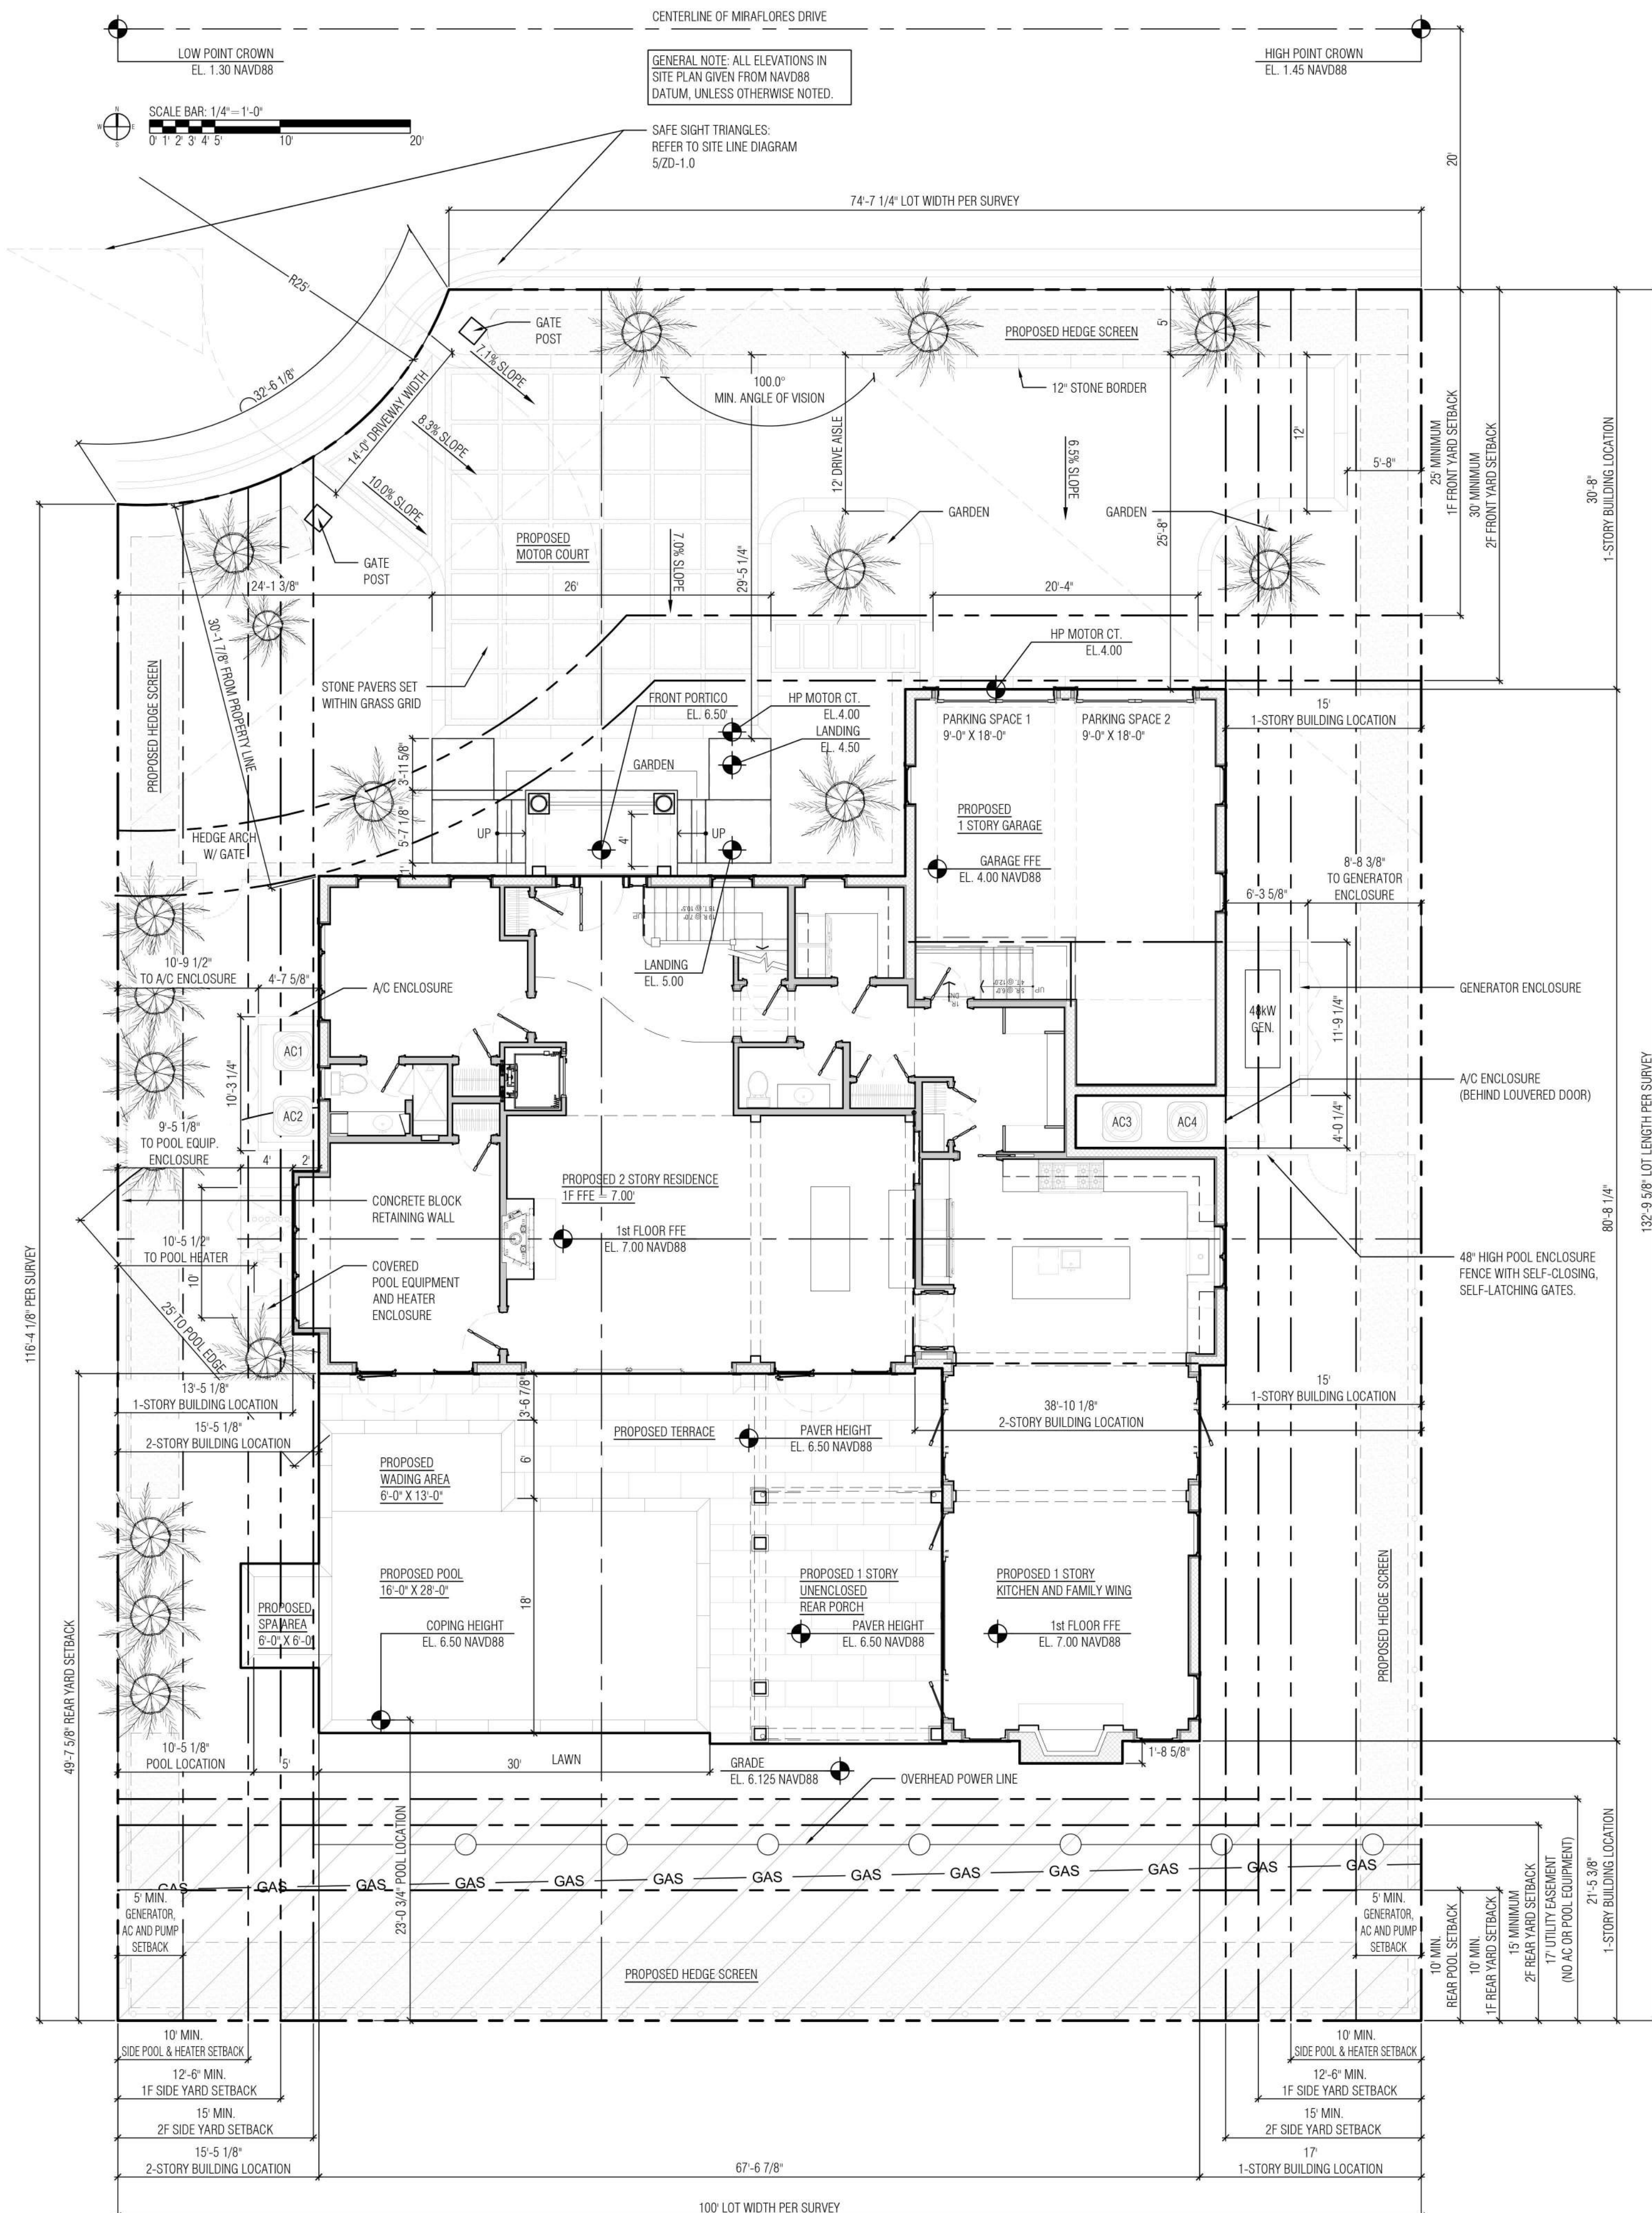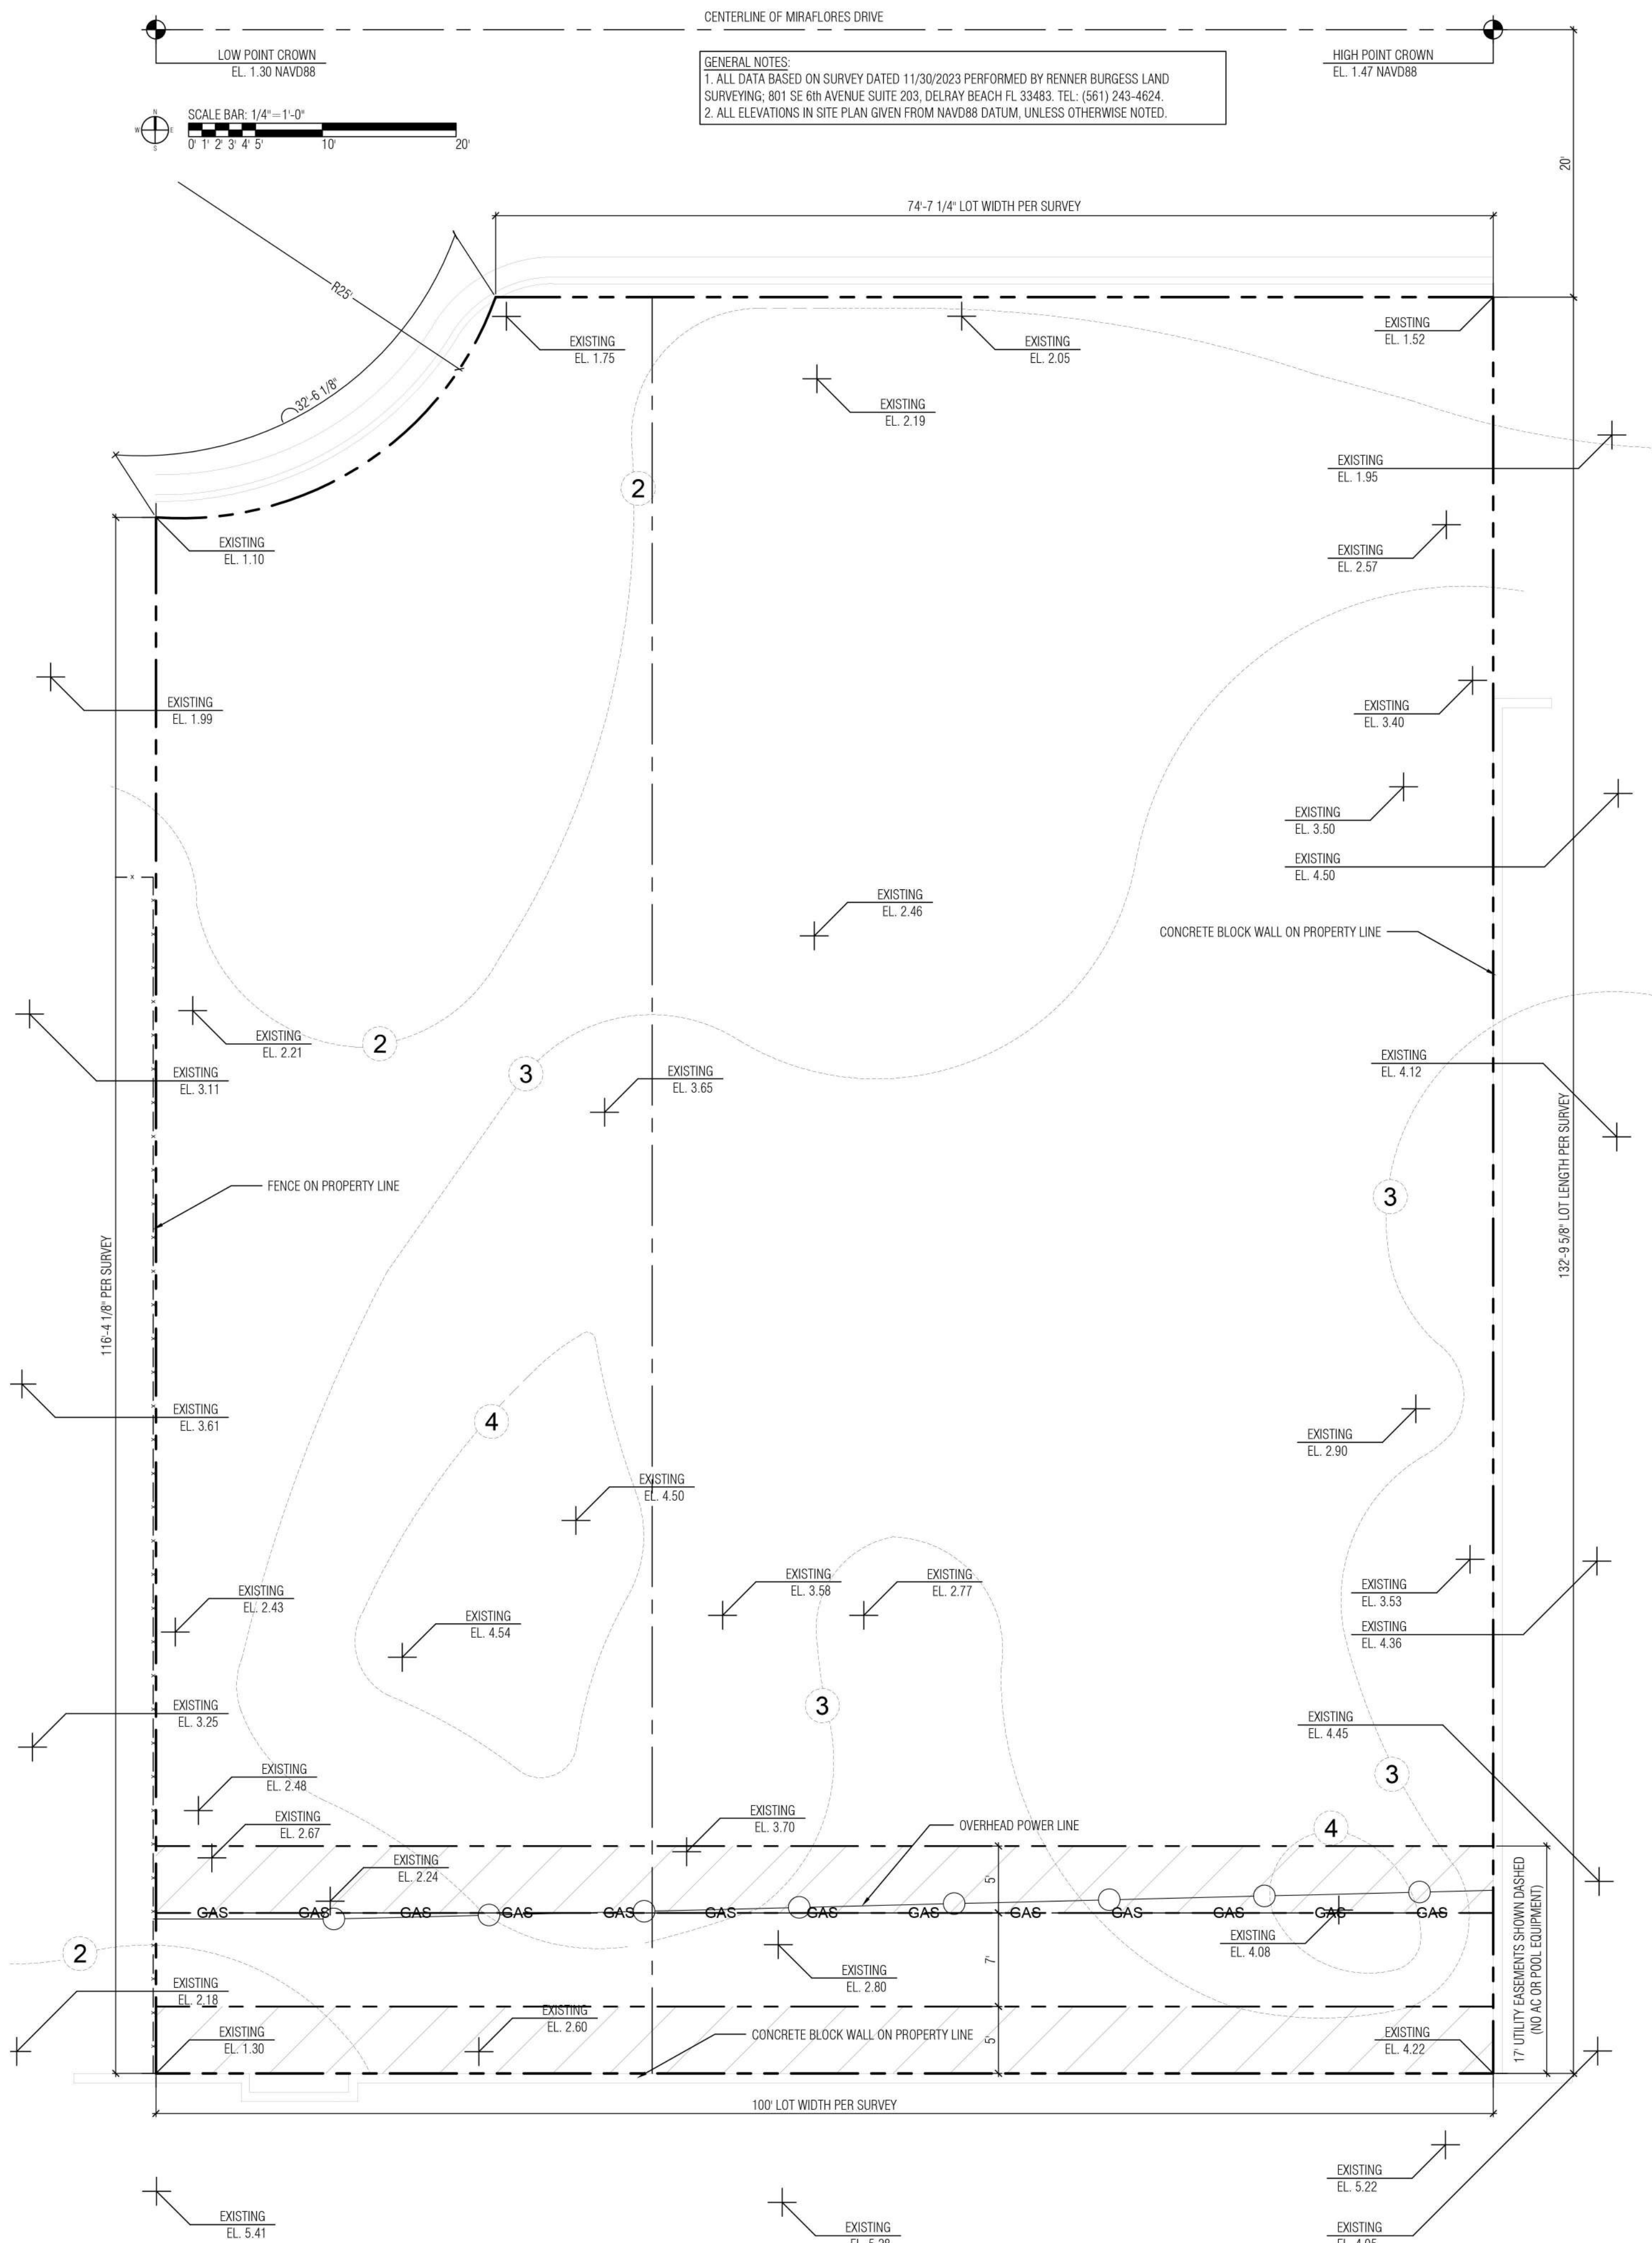


DATE LOG

NO.	ISSUE	DATE
1	PRELIMINARY FOR REVIEW ONLY (ARCOM)	10-14-2023
2	FIRST SUBMITTAL (ARCOM)	11-02-2023
3	FINAL SUBMITTAL (ARCOM)	12-07-2023
4	1st RESUBMISSION (ARCOM)	3-11-2024
5		
6		
7		
8		
9		
10		
11		
12		
13		
14		
15		
16		
17		

CONSULTANTS:

PROFESSIONAL SEAL

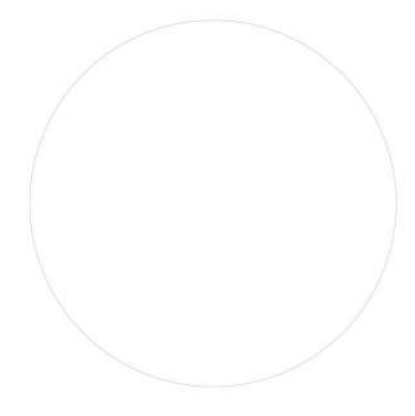

THE DRAWINGS, SPECIFICATIONS, AND OTHER DOCUMENTS PREPARED BY KEAN DESIGNS LTD. FOR THE PROJECT AND FOR THE PURPOSES OF ARCHITECTURAL, ENGINEERING, AND OTHER PROFESSIONAL SERVICES, ARE THE PROPERTY OF KEAN DESIGNS LTD. AND ARE NOT TO BE REPRODUCED, COPIED, OR DISTRIBUTED IN ANY MANNER WITHOUT THE WRITTEN CONSENT OF KEAN DESIGNS LTD. ANY REPRODUCTION OR DISTRIBUTION OF THESE DOCUMENTS WITHOUT THE WRITTEN CONSENT OF KEAN DESIGNS LTD. IS STRICTLY PROHIBITED. ANY VIOLATION OF THIS NOTICE SHALL BE CONSIDERED A VIOLATION OF THE PROFESSIONAL ETHICS OF THE ENGINEER OR ARCHITECT AND MAY BE SUBJECT TO LEGAL ACTION.

KEAN DESIGNS LTD.

5 MAIN STREET
COLD SPRING HARBOR
NEW YORK, 11724

T: +1 (631) 367-9696
E: info@keandesigns.com

PROJECT ADDRESS:

MIRAFLORES

260 MIRAFLORES DRIVE
TOWN OF PALM BEACH, FLORIDA

AS NOTED	JTD
SCALE	DRAWN
e 2016	
JOB	KEAN DESIGNS

SP-1.0

EXISTING AND PROPOSED
SITE PLAN



N

1

SP-1.1

RENDERED SITE PLAN

SCALE: NTS


DATE LOG

NO.	ISSUE
	DATE

1	FIRST SUBMITTAL (ARCOM)
2	11-07-2023 SECOND SUBMITTAL (ARCOM)
3	11-20-2023 FINAL SUBMITTAL (ARCOM)
4	12-07-2023 1st RESUBMISSION (ARCOM)
5	3-11-2024
6	
7	
8	
9	
10	
11	
12	
13	
14	
15	
16	
17	

CONSULTANTS:

PROFESSIONAL SEAL:

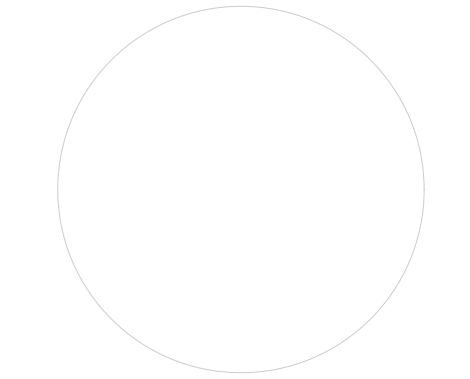

THE DRAWINGS, SPECIFICATIONS, AND OTHER DOCUMENTS PREPARED BY KEAN DESIGNS LTD. FOR THE PROJECT, ARE HEREBY SUBMITTED TO THE PROJECT OWNER, AS NOTED, FOR THEIR REVIEW AND APPROVAL. THE PROJECT OWNER'S REVIEW AND APPROVAL OF THESE DOCUMENTS DOES NOT CONSTITUTE A GUARANTEE OF THE ACCURACY OR COMPLETENESS OF THE INFORMATION CONTAINED HEREIN. THE PROJECT OWNER'S REVIEW AND APPROVAL OF THESE DOCUMENTS DOES NOT CONSTITUTE A GUARANTEE OF THE ACCURACY OR COMPLETENESS OF THE INFORMATION CONTAINED HEREIN. THE PROJECT OWNER'S REVIEW AND APPROVAL OF THESE DOCUMENTS DOES NOT CONSTITUTE A GUARANTEE OF THE ACCURACY OR COMPLETENESS OF THE INFORMATION CONTAINED HEREIN.



KEAN DESIGNS
LTD.

5 MAIN STREET
COLD SPRING HARBOR
NEW YORK, 11724

T: +1 (631) 367-9696
E: info@keandesigns.com

PROJECT ADDRESS:

MIRAFLORES
260 MIRAFLORES DRIVE
TOWN OF PALM BEACH, FLORIDA


AS NOTED | CW

SCALE | DRAWN


JOB | © 2016

KEAN DESIGNS


[SP-1.1]

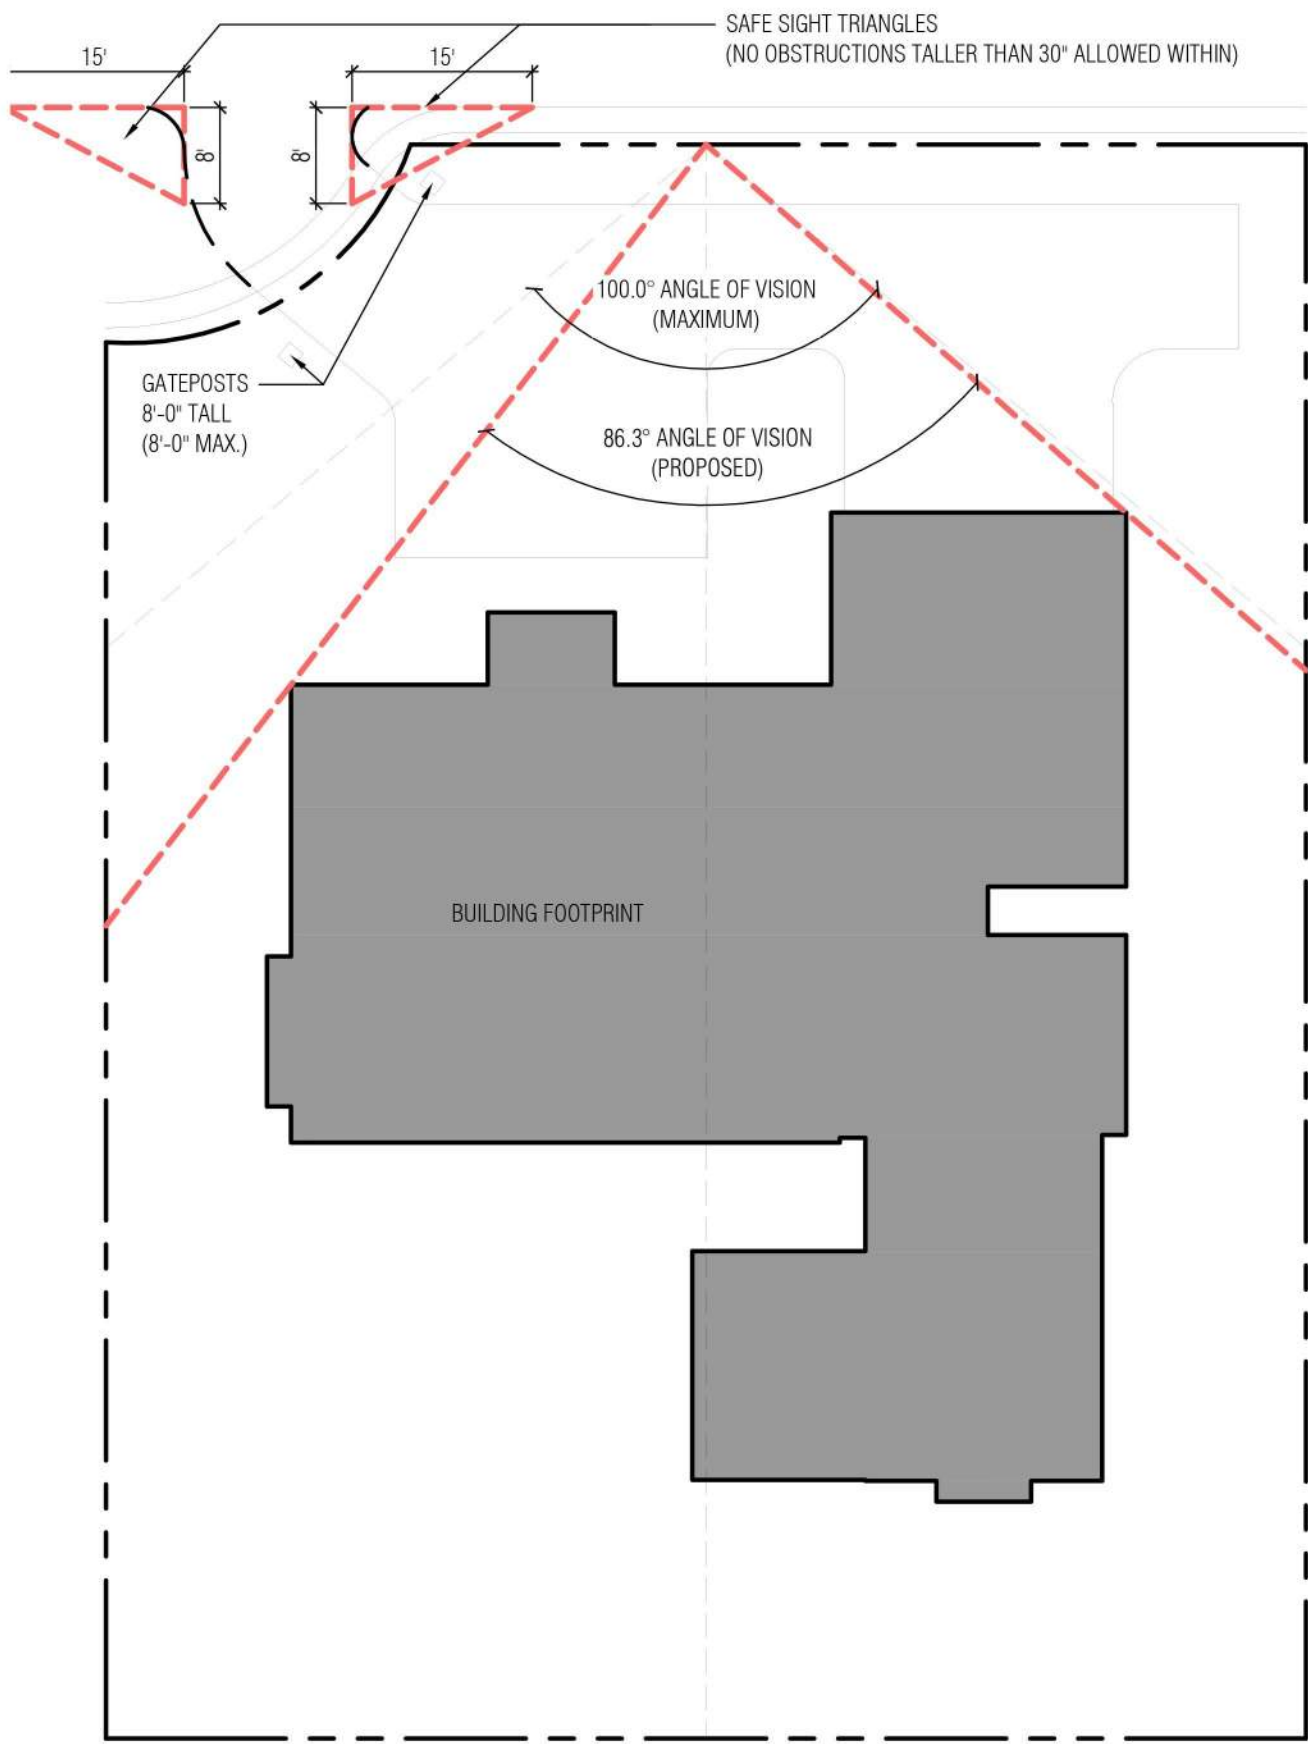


5 SIGHT LINES DIAGRAM
ZD-1.0 SCALE: 1/16"=1'-0"

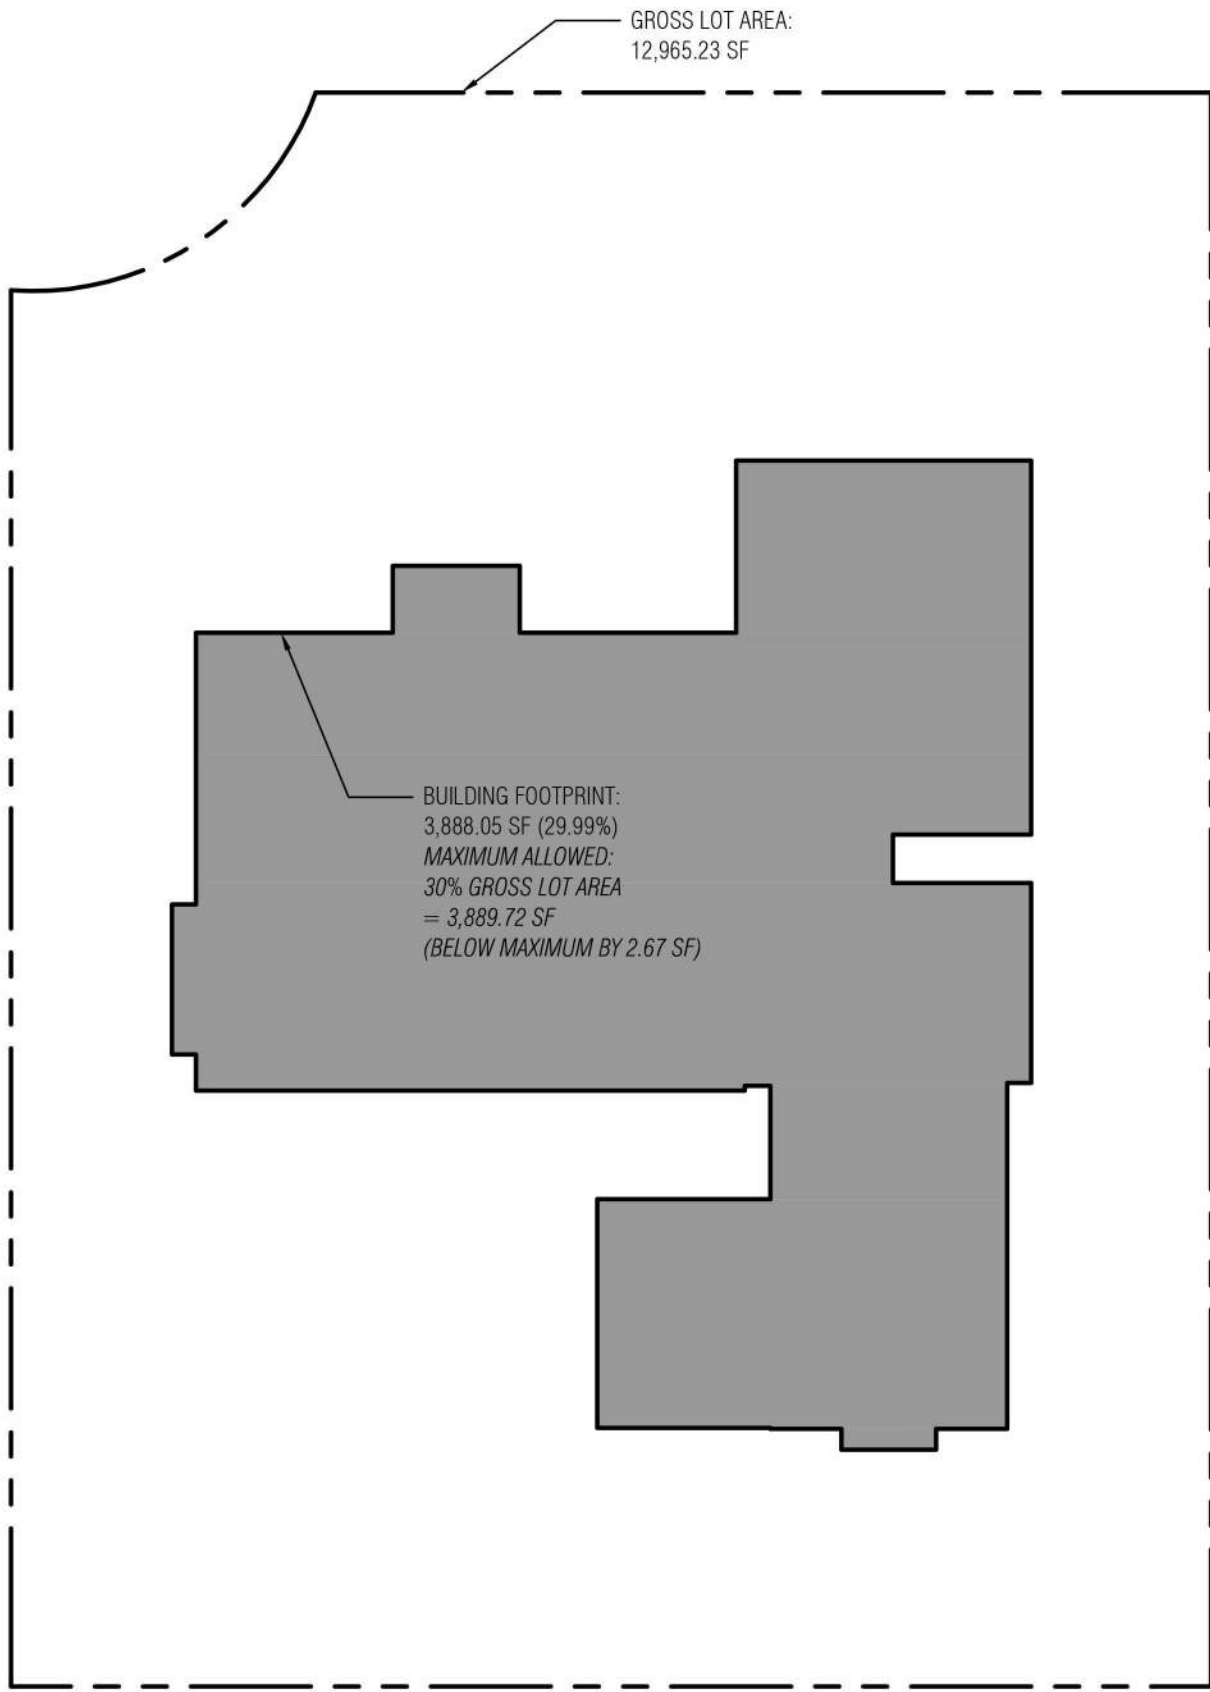

4 LOT COVERAGE DIAGRAM
ZD-1.0 SCALE: 1/16"=1'-0"

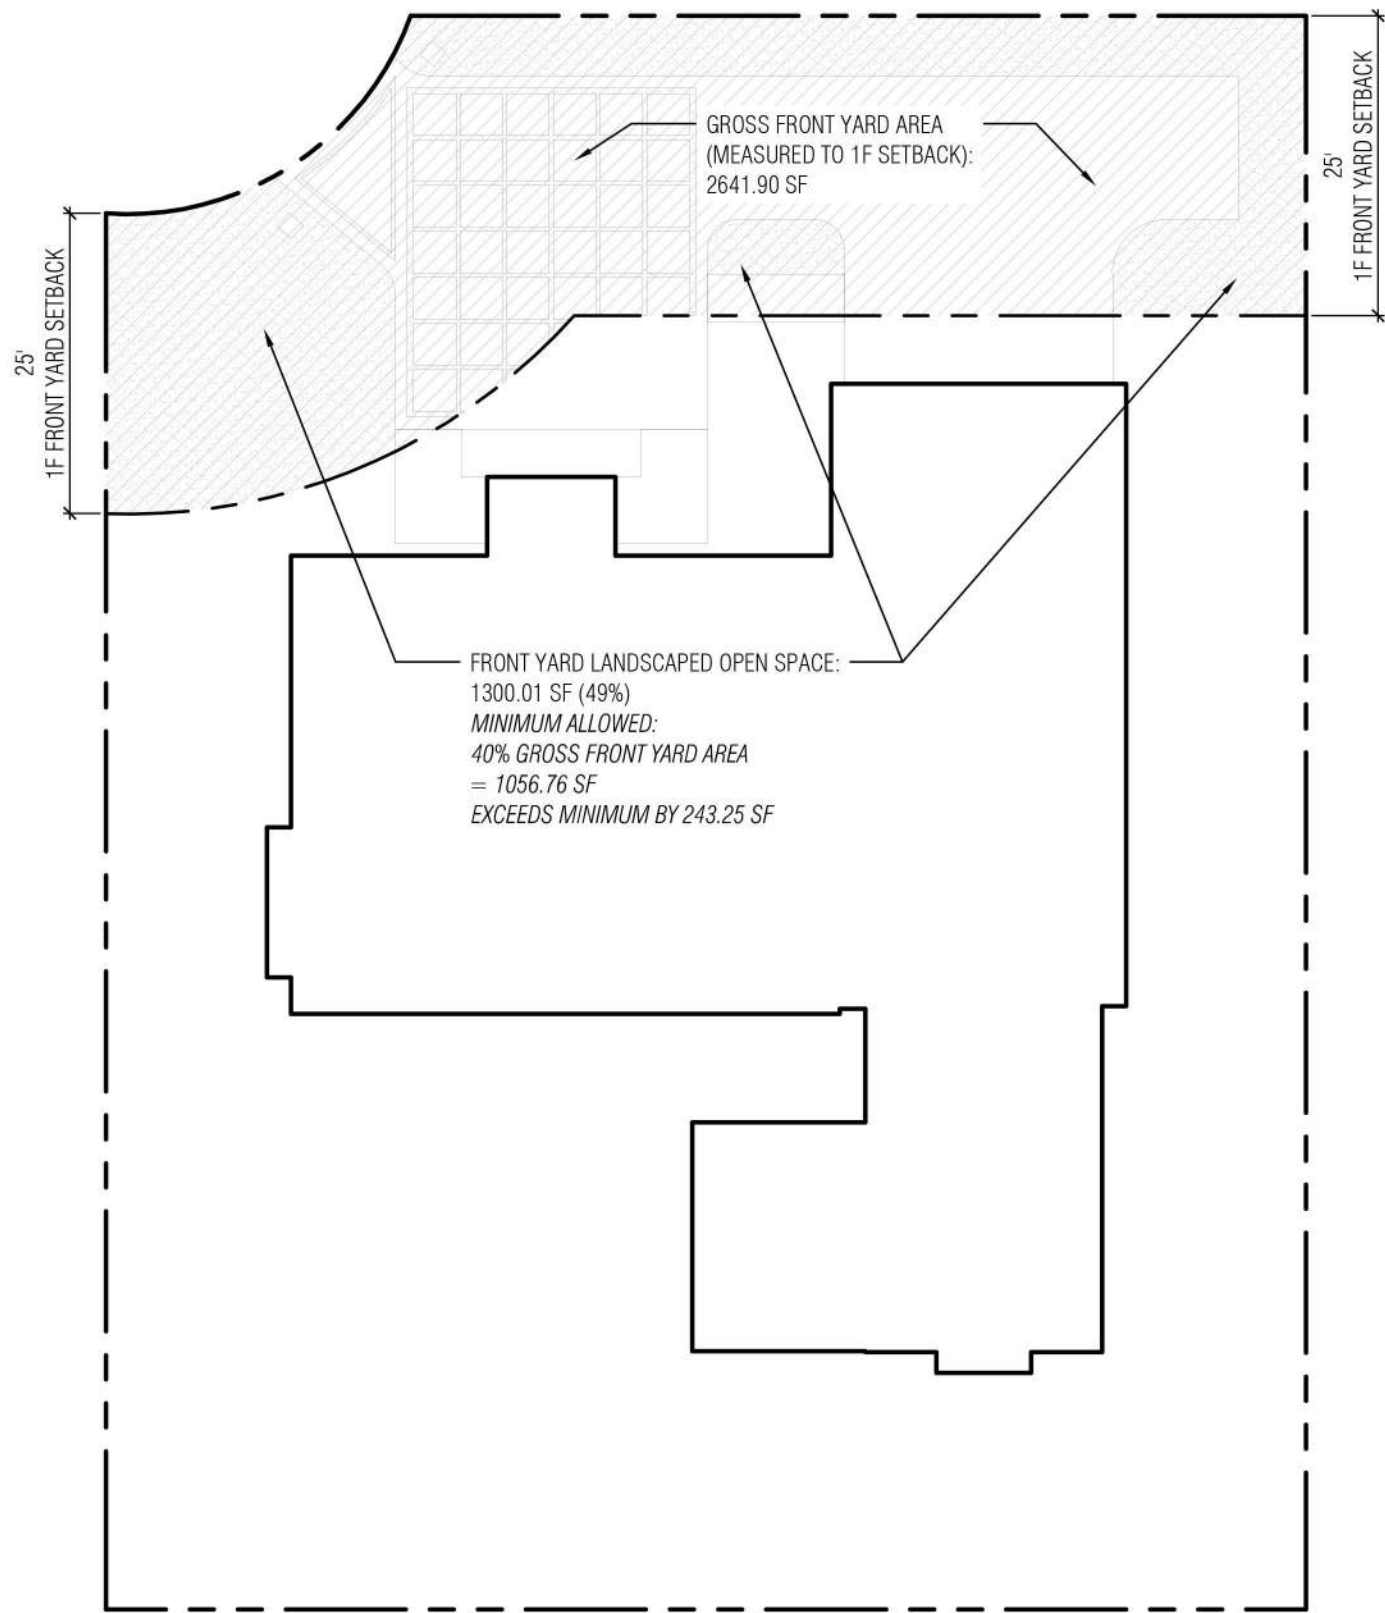

3 FRONT YARD DIAGRAM
ZD-1.0 SCALE: 1/16"=1'-0"

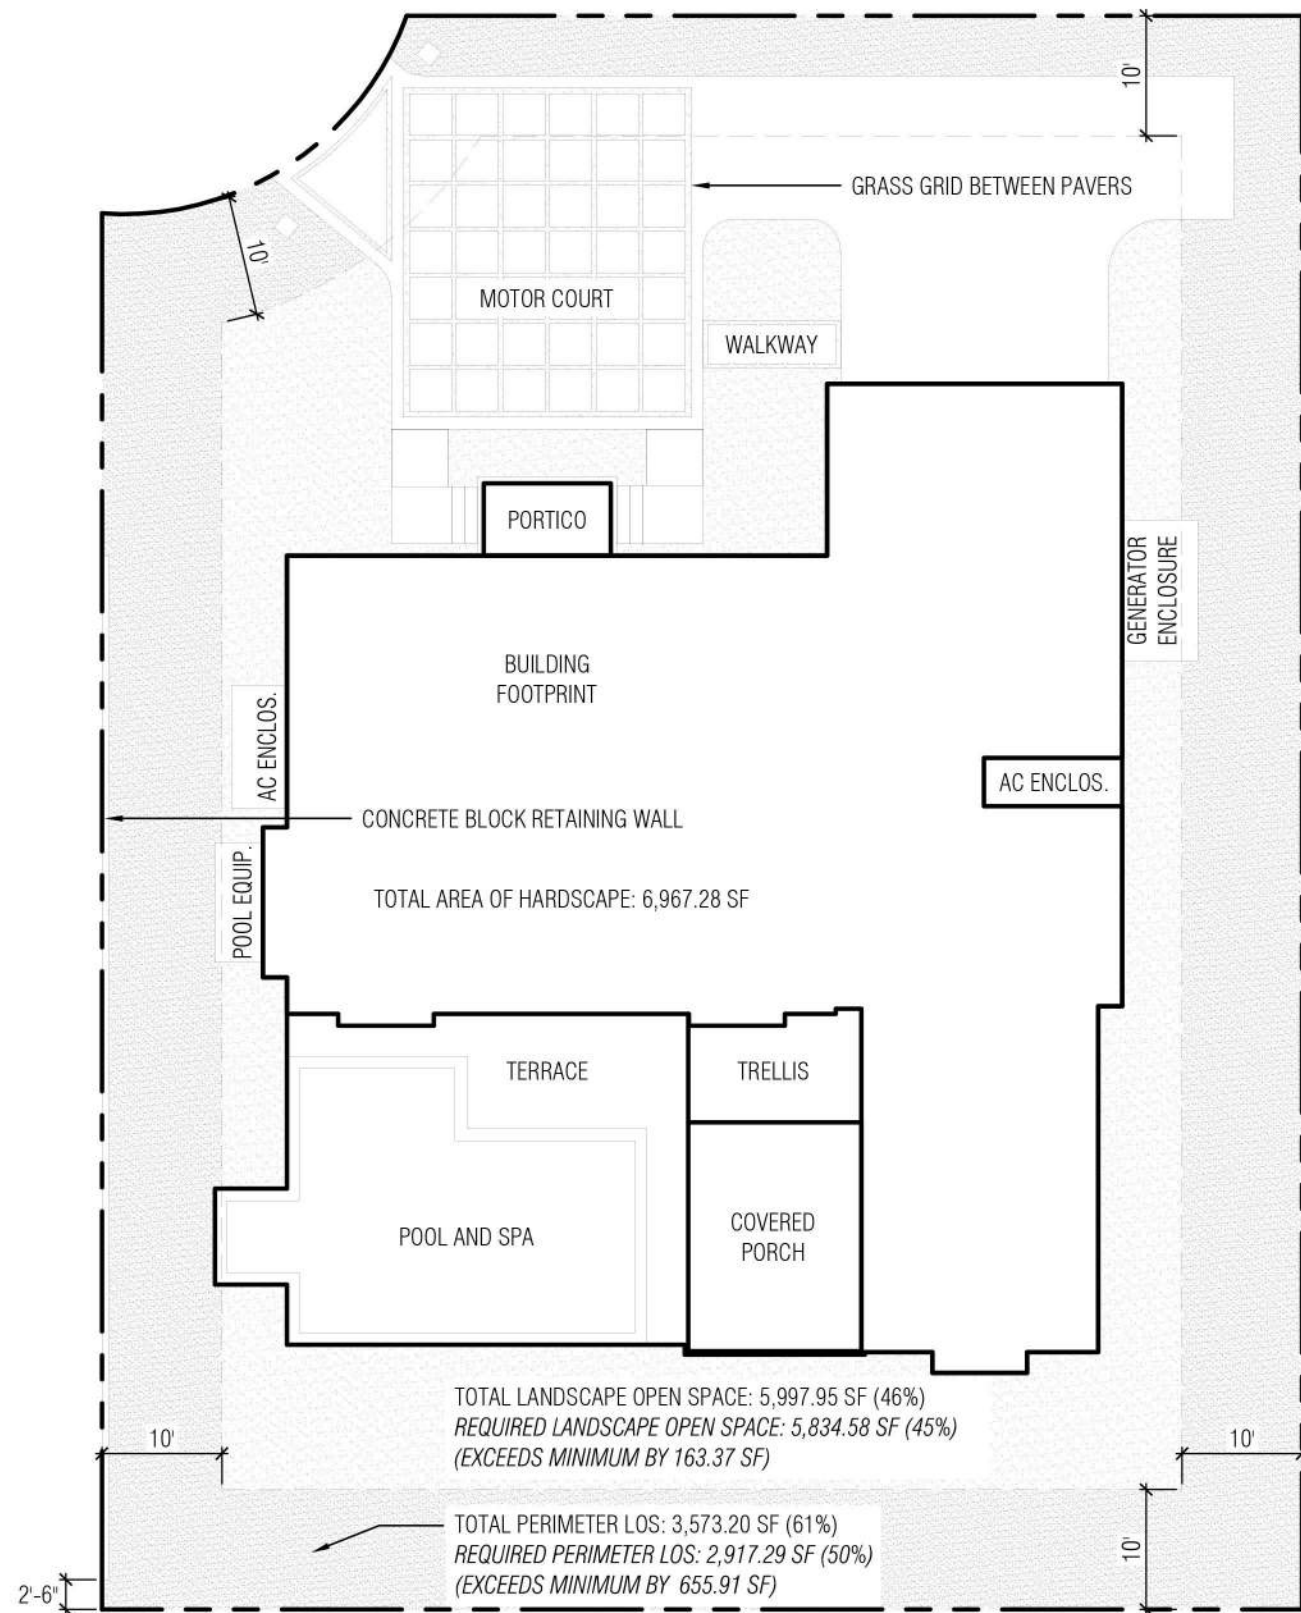

2 OPEN SPACE DIAGRAM
ZD-1.0 SCALE: 1/16"=1'-0"

Town of Palm Beach Planning Zoning and Building 360 S County Rd Palm Beach, FL 33480 www.townofpalmbeach.com			
Line #	Zoning Legend		
1	Property Address:	260 Miraflores Drive, Palm Beach, FL 33480	
2	Zoning District:	R-B Residential District	
3	Lot Area (sq. ft.):	12,965.73 SF	
4	Lot Width (W) & Depth (D) (ft.):	100'-0" Wide x 132'-9 5/8" Deep	
5	Structure Type:	Single Family Residential	
6	FEMA Flood Zone Designation:	Zone "AE" EL. 6.00 (Per FIRM Map #12099C0581F (Dated 10/5/2017)	
7	Zero Datum for point of meas. (NAVD)	EL. 7.00 NAVD88 (Used as Architectural 0'-0")	
8	Crown of Road (COR) (NAVD)	EL. 1.45 NAVD88	
9		REQ'D / PERMITTED	EXISTING / PROPOSED
10	Lot Coverage (Sq Ft and %)	3,889.27 SF, 30%	0 / 3,888.05 SF, 29.99%
11	Enclosed Square Footage (1st & 2nd Fl., Basement, Accs., Structure, etc.)	N/A	5,727.46 SF
12	*Front Yard Setback (Ft.)	N 25'-0" (1F), 30'-0" (2F)	N 30'-8" (1F), 30'-1 7/8" (2F)
13	*Side Yard Setback (1st Story) (Ft.)	E 12'-6", W 12'-6"	E 15'-0", W 13'-5 1/8"
14	*Side Yard Setback (2nd Story) (Ft.)	E 15'-0", W 15'-0"	E 38'-10 1/8", W 15'-5 1/8"
15	*Rear Yard Setback (Ft.)	S 10'-0" (1F), 15'-0" (2F)	S 21'-5 3/8" (1F), 49'-7 5/8" (2F)
16	Angle of Vision (Deg.)	100°	N/A / 86.3°
17	Building Height (Ft.)	14'-0" (1F), 22'-0" (SF)	N/A / 9'-1 11/16" (1F), 19'-0 7/8" (2F)
18	Overall Building Height (Ft.)	30'-0"	N/A / 27'-2 1/4"
19	Cubic Content Ratio (CCR) (R-B ONLY)	3.97	N/A / 3.95
20	** Max. Fill Added to Site (Ft.)	2.77 FT	N/A / 2.77 FT
21	Finished Floor Elev. (FFE)(NAVD)	EL. 7.00 NAVD88	N/A / EL. 7.00 NAVD88
22	Base Flood Elevation (BFE)(NAVD)	EL. 6.00 NAVD88	N/C / N/C
23	Landscape Open Space (LOS) (Sq Ft and %)	5,834.58 SF, 45%	12,965.73 SF, 100% / 5,997.95 SF, 46%
24	Perimeter LOS (Sq Ft and %)	2,917.29, 50%	4,157.13, 71% / 3,577.70 SF, 61%
25	Front Yard LOS (Sq Ft and %)	1,056.76 SF, 40%	2,641.90 SF (100%) / 1,300.01 SF, 49%
26	*** Native Plant Species %	Please refer to TOPB Landscape Legend.	


* Indicate each yard area with cardinal direction (N,S,E,W)
** Difference of Fin. Floor Elev. (FFE) and highest Crown of Rd (COR) divided by two. (FFE - COR) / 2 = Max. Fill (Sec. 134-1600)
*** Provide Native plant species info per category as required by Ord. 003-2023 on separate TOPB Landscape Legend

Enter N/A if value is not applicable.
Enter N/C if value is not changing.

REV BF 20230626

1 PALM BEACH ZONING LEGEND
ZD-1.0 SCALE: N/A

DATE LOG	
NO.	ISSUE DATE
1	FIRST SUBMITTAL (ARCOM)
2	11-03-2023 SECOND SUBMITTAL (ARCOM)
3	11-20-2023 FINAL SUBMITTAL (ARCOM)
4	12-07-2023 1st RESUBMISSION (ARCOM)
5	3-11-2024
6	
7	
8	
9	
10	
11	
12	
13	
14	
15	
16	
17	
CONSULTANTS:	

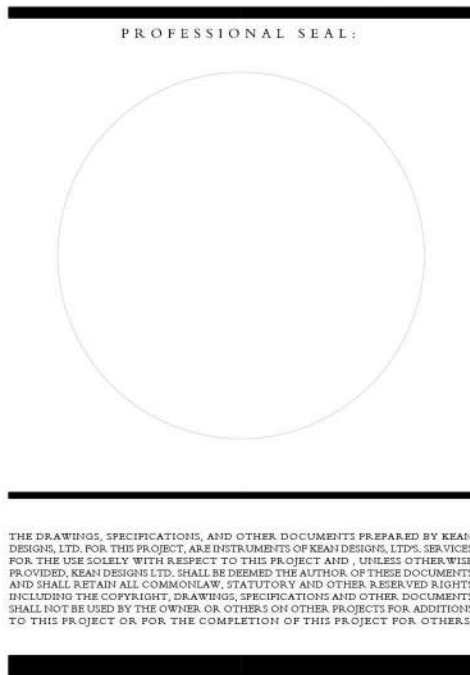

KEAN DESIGNS LTD.

5 MAIN STREET
COLD SPRING HARBOR
NEW YORK, 11724

T: +1 (631) 367-9696
E: info@keandesigns.com

PROJECT ADDRESS:
MIRAFLORES
260 MIRAFLORES DRIVE
TOWN OF PALM BEACH, FLORIDA

AS NOTED	JTD
SCALE	DRAWN
JOB	e 2016
	KEAN DESIGNS

ZD-1.0

DATE LOG	
NO.	ISSUE DATE
1	FIRST SUBMITTAL (ARCOM) 11-01-2023
2	SECOND SUBMITTAL (ARCOM) 11-20-2023
3	FINAL SUBMITTAL (ARCOM) 12-07-2023
4	1st RESUBMISSION (ARCOM) 3-11-2024
5	
6	
7	
8	
9	
10	
11	
12	
13	
14	
15	
16	
17	

CONSULTANTS:

PROFESSIONAL SEAL:

THE DRAWINGS, SPECIFICATIONS, AND OTHER DOCUMENTS PREPARED BY K&N DESIGNS LTD. FOR THE PROJECT, AND ANY SUBSEQUENT REVISIONS, SHALL BE THE PROPERTY OF K&N DESIGNS LTD. AND SHALL NOT BE REPRODUCED, COPIED, OR TRANSMITTED IN ANY FORM OR BY ANY MEANS, WITHOUT THE WRITTEN PERMISSION OF K&N DESIGNS LTD. ANY UNAUTHORIZED USE OF THESE DOCUMENTS SHALL BE AT THE USER'S SOLE RISK AND WITHOUT LIABILITY TO K&N DESIGNS LTD.




KEAN DESIGNS LTD.
5 MAIN STREET
COLD SPRING HARBOR
NEW YORK, 11724
T: +1 (631) 367-9696
E: info@keandesigns.com
PROJECT ADDRESS:
MIRAFLORES
260 MIRAFLORES DRIVE
TOWN OF PALM BEACH, FLORIDA

AS NOTED	JTD
SCALE	DRAWN

	e 2016
JOB	KEAN DESIGNS

ZD-1.1

CUBIC CONTENT RATIO DIAGRAM
AND CALCULATIONS

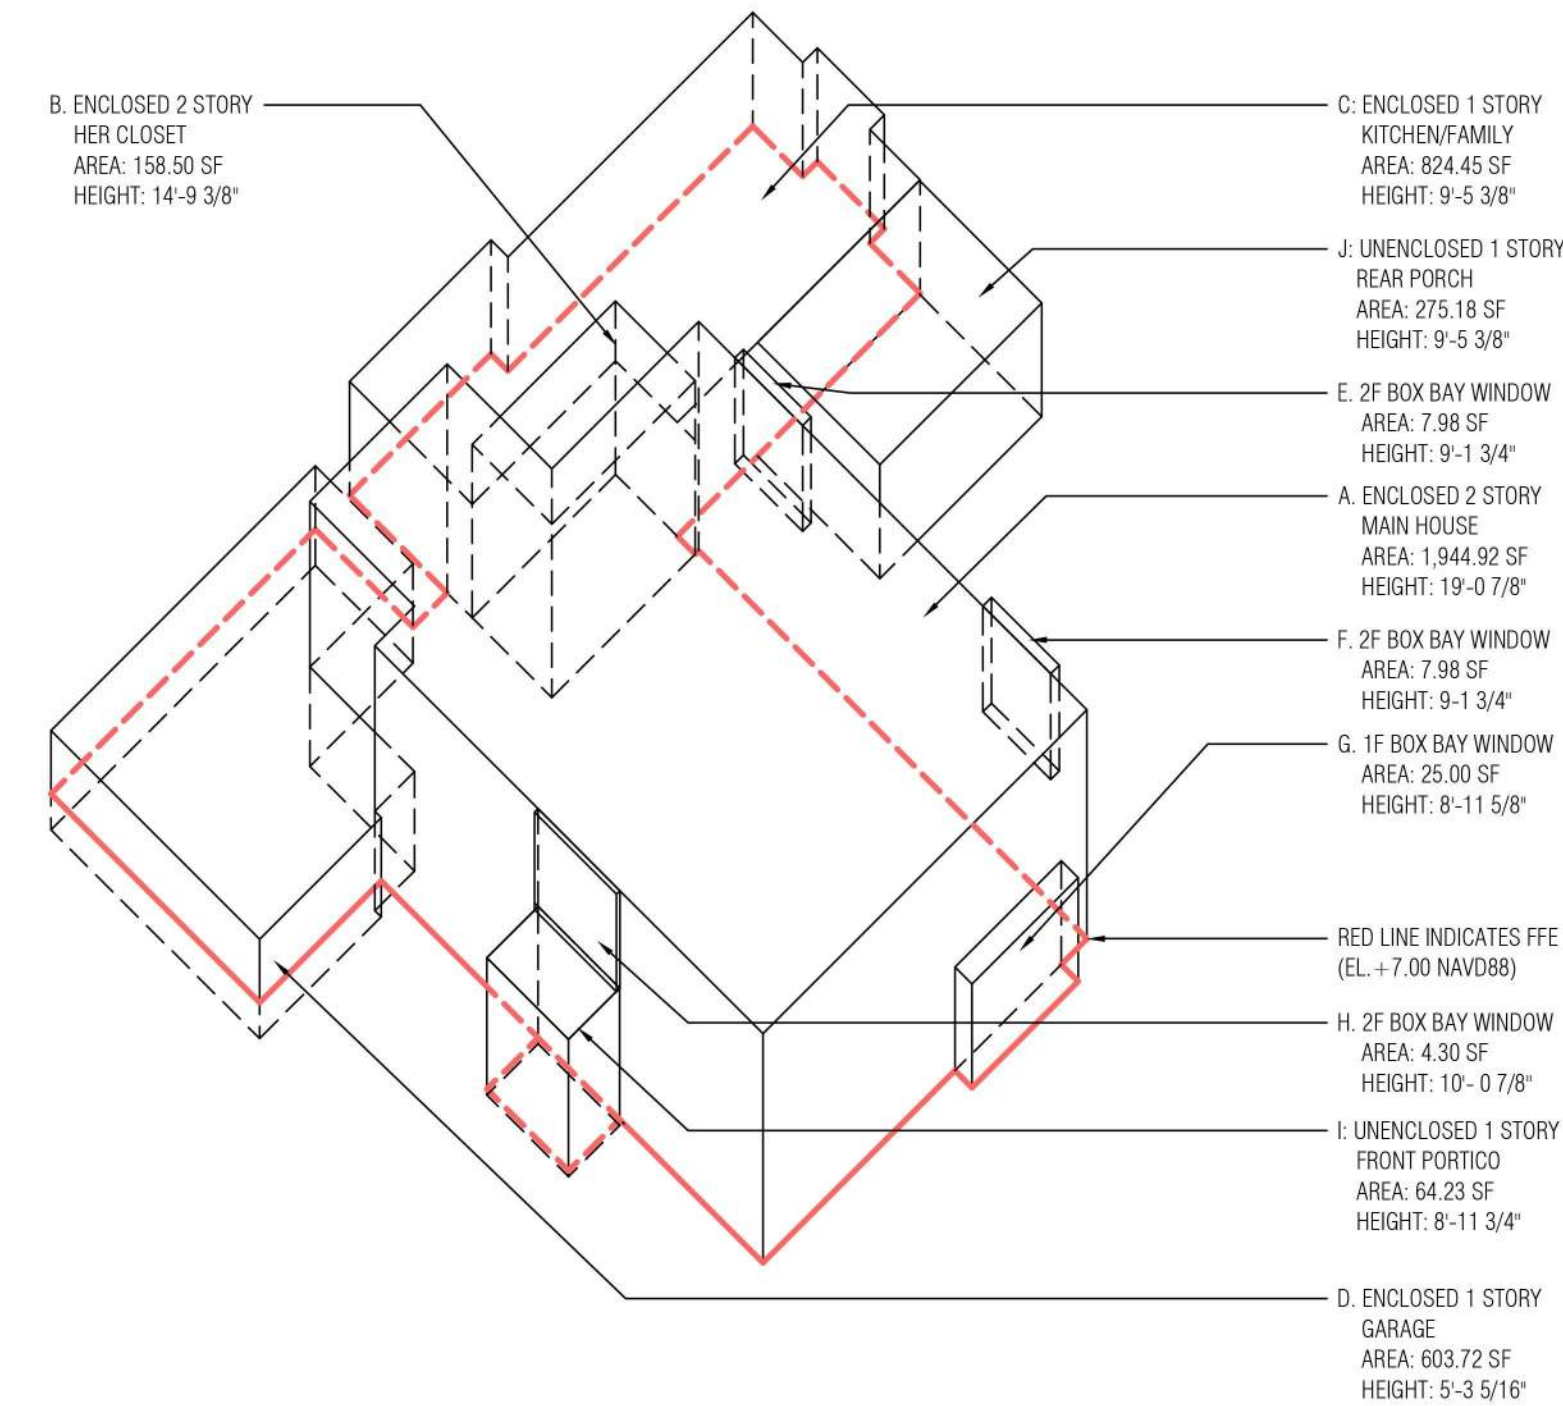


CCR AXONOMETRIC DIAGRAM

SCALE: NTS

CUBIC CONTENT RATIO FOR ZONING DISTRICT R - B			
LOT SIZE: 13,000 SF (ROUNDED PER CODE)	SQ. FT. (SQUARE FOOT) AREA	HEIGHT FROM ZERO DATUM	CU. FT. (CUBIC FEET) VOLUME
A. ENCLOSED 2 STORY MAIN HOUSE	1,944.92 SF.	19'-0 7/8" (19.073)	37,095.46 CU. FT.
B. ENCLOSED 2 STORY HER CLOSET	158.50 SF.	14'-9 3/8" (14.781)	2,342.79 CU. FT.
C. ENCLOSED 1 STORY KITCHEN/FAMILY	824.45 SF.	9'-5 3/8" (9.448)	7,789.40 CU. FT.
D. ENCLOSED 1 STORY GARAGE	603.72 SF.	5'-3 5/16" (5.276)	3,185.23 CU. FT.
E. 2nd STORY BOX BAY WINDOW	7.98 SF.	9'-1 3/4" (9.146)	72.99 CU. FT.
F. 2nd STORY BOX BAY WINDOW	7.98 SF.	9'-1 3/4" (9.146)	72.99 CU. FT.
G. 1st STORY BOX BAY WINDOW	25.00 SF.	8'-11 5/8" (8.968)	224.20 CU. FT.
H. 2nd STORY BOX BAY WINDOW	4.30 SF.	10'-0 7/8" (10.073)	43.31 CU. FT.
TOTAL ENCLOSED:			50,803.74 CU. FT.
I. UNENCLOSED 1 STORY: FRONT PORTICO	64.23 SF.	8'-11 3/4" (8.979)	576.72 CU. FT.
J. UNENCLOSED 1 STORY: REAR PORCH	275.18 SF.	9'-5 3/8" (9.448)	2,599.90 CU. FT.
TOTAL UNENCLOSED:			3,176.62 CU. FT.
K. TRELLIS	150.46 SF.		
MAXIMUM ALLOWABLE CCR = $3.50 + \frac{((60,000 - 13,000) \div 50,000) \times 0.5}{1} = 3.97$ OR 51,610 CU. FT.			
MAXIMUM EXEMPT CCR FOR UNENCLOSED COVERED = 5% OF MAXIMUM ALLOWABLE CCR (51,610) = 2,580 CU. FT. (MAXIMUM ALLOWED) 3,176.62 (PROPOSED) - 2,580 (ALLOWED) = 596.12 CU. FT. NON-EXEMPT (TO BE ADDED TO CCR)			
MAXIMUM EXEMPT TRELLIS: = 3% OF GROSS LOT AREA (12,965.73 SF) = 388.97 SF (MAXIMUM ALLOWED) 123.20 SF PROPOSED; TRELLIS DOES NOT CONTRIBUTE TO CCR OR LOT COVERAGE. (PER §134-895)			
TOTAL CCR = 50,803.74 (TOTAL PROPOSED ENCLOSED) + 596.12 (NON-EXEMPT UNENCLOSED) = 51,399.86 CU. FT. < 51,610 CU. FT. (210.14 CU. FT. UNDER) 51,399.86/13,000 = 3.95 CCR ≤ 3.97 MAX. CCR			


CUBIC CONTENT RATIO CALCULATIONS

SCALE: NTS

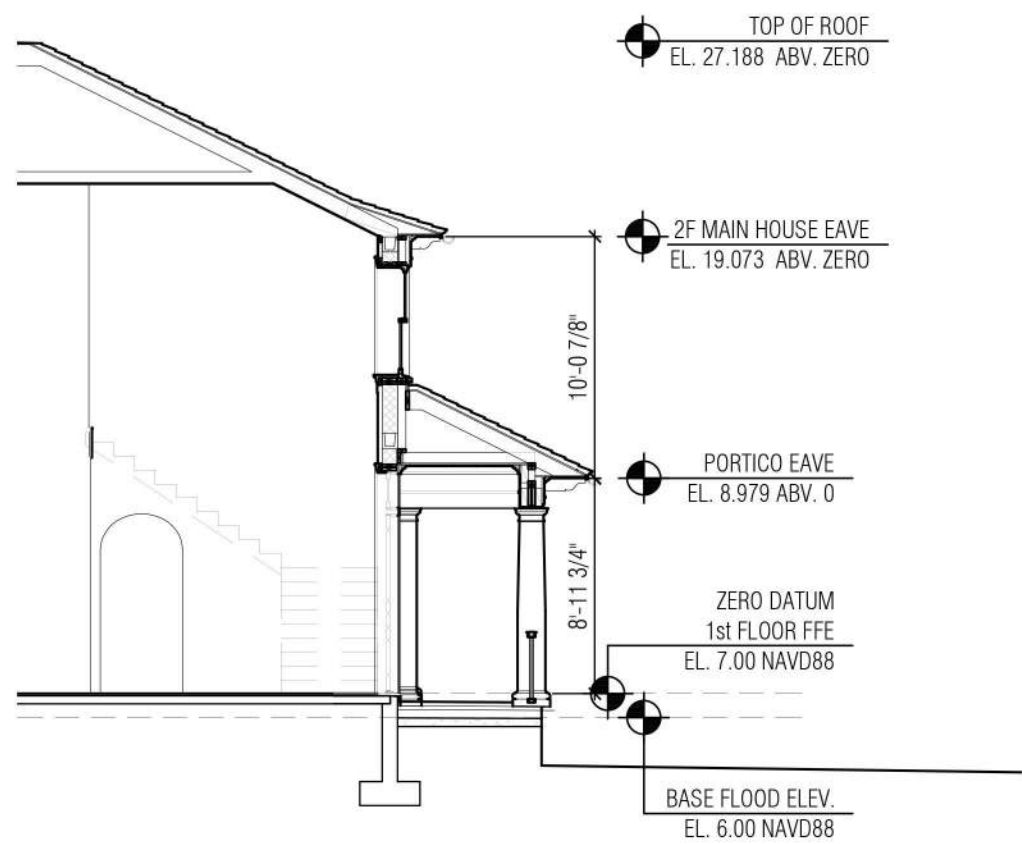


CCR SECTIONS A,H,I

SCALE: 1/8"=1'-0"

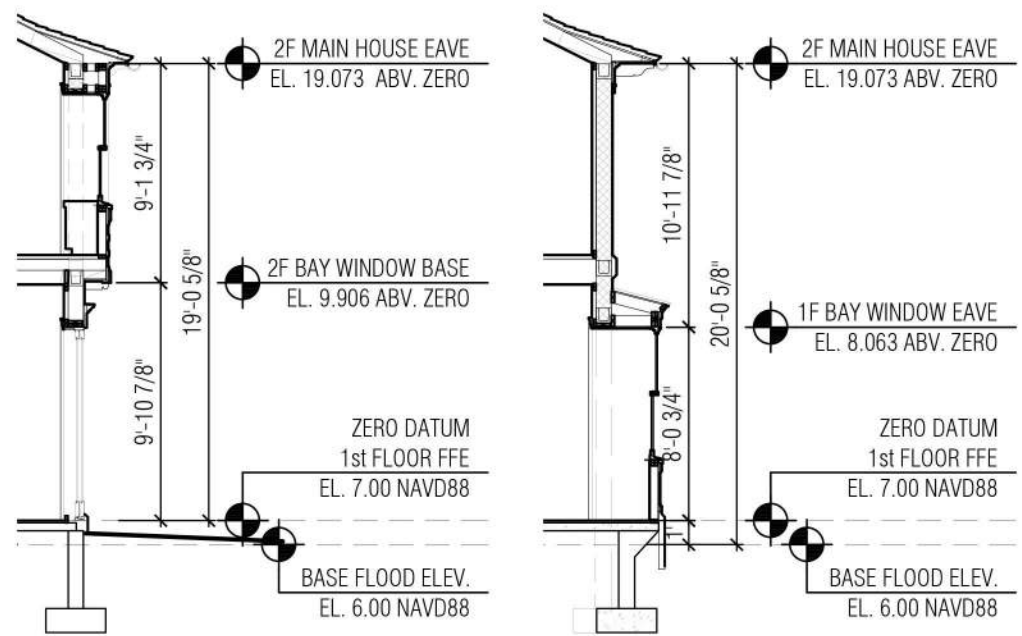


CCR SECTIONS E,F,G

SCALE: 1/8"=1'-0"

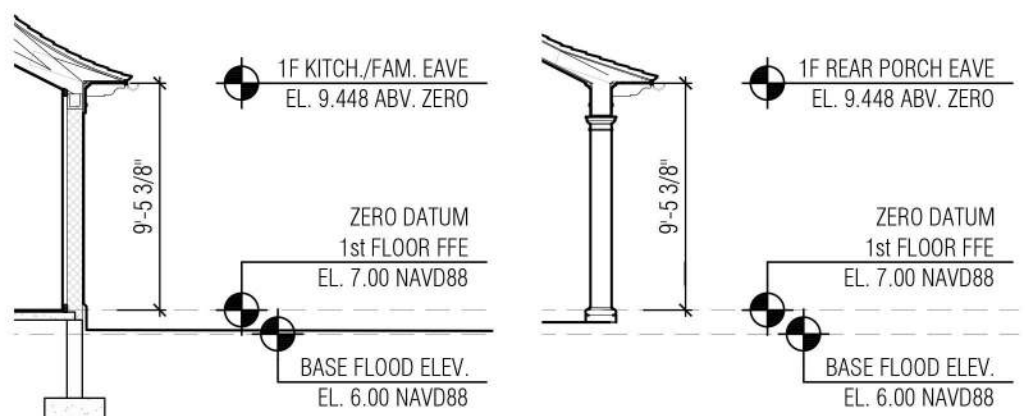


CCR SECTIONS C,J

SCALE: 1/8"=1'-0"

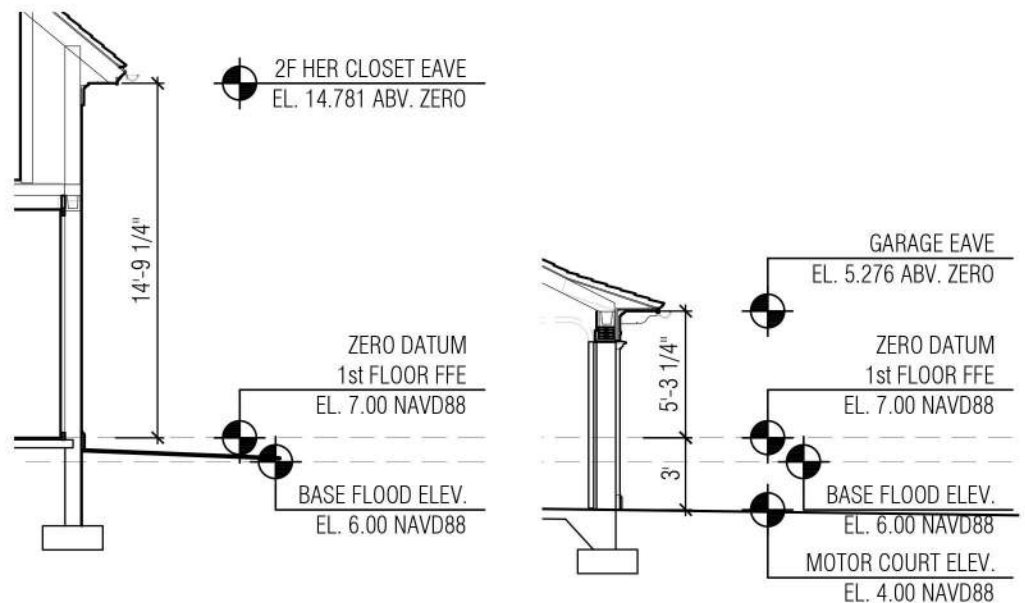


CCR SECTIONS B,D

SCALE: 1/8"=1'-0"

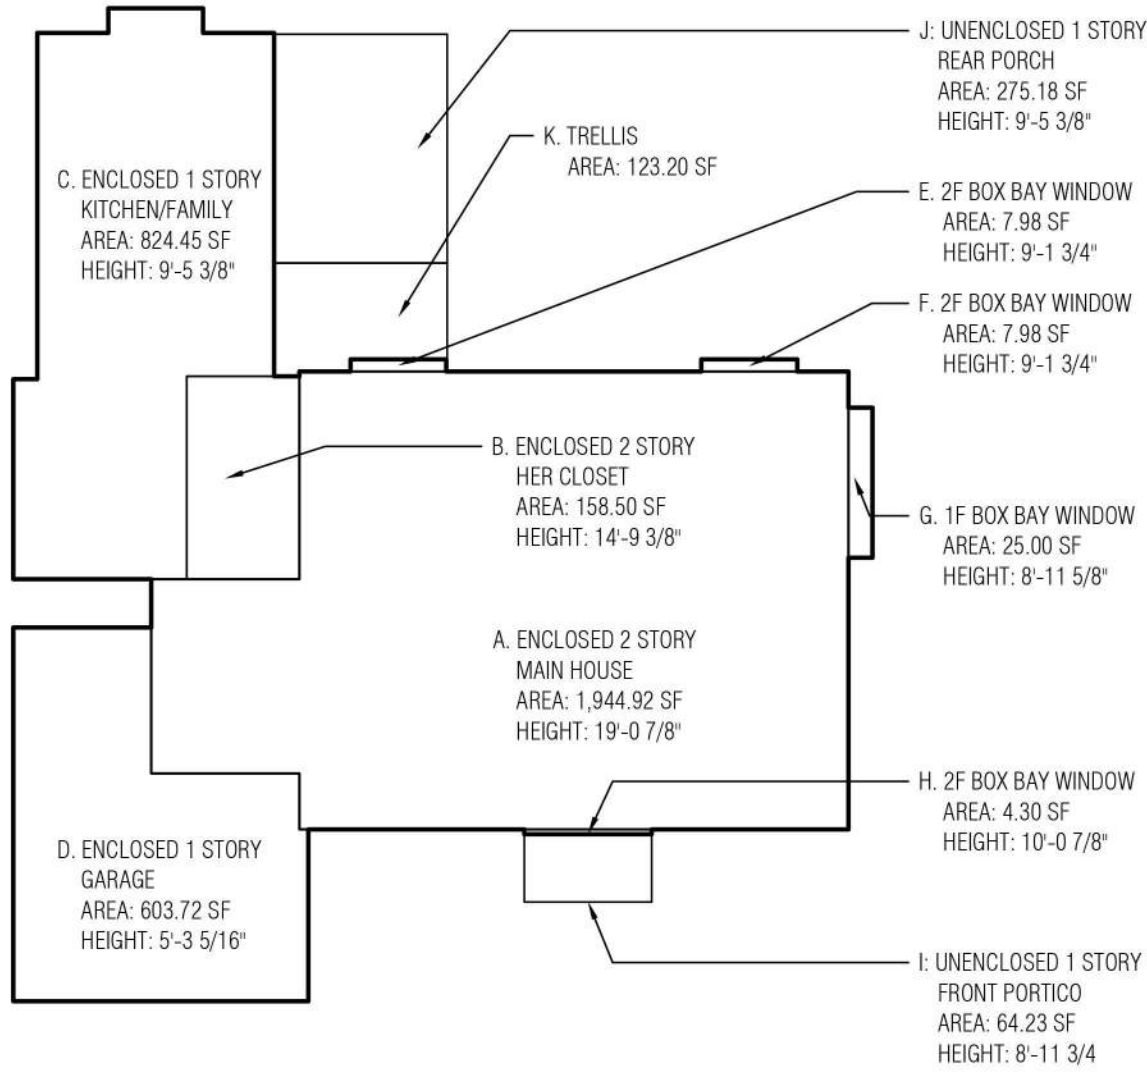

CCR PLAN DIAGRAM

SCALE: NTS

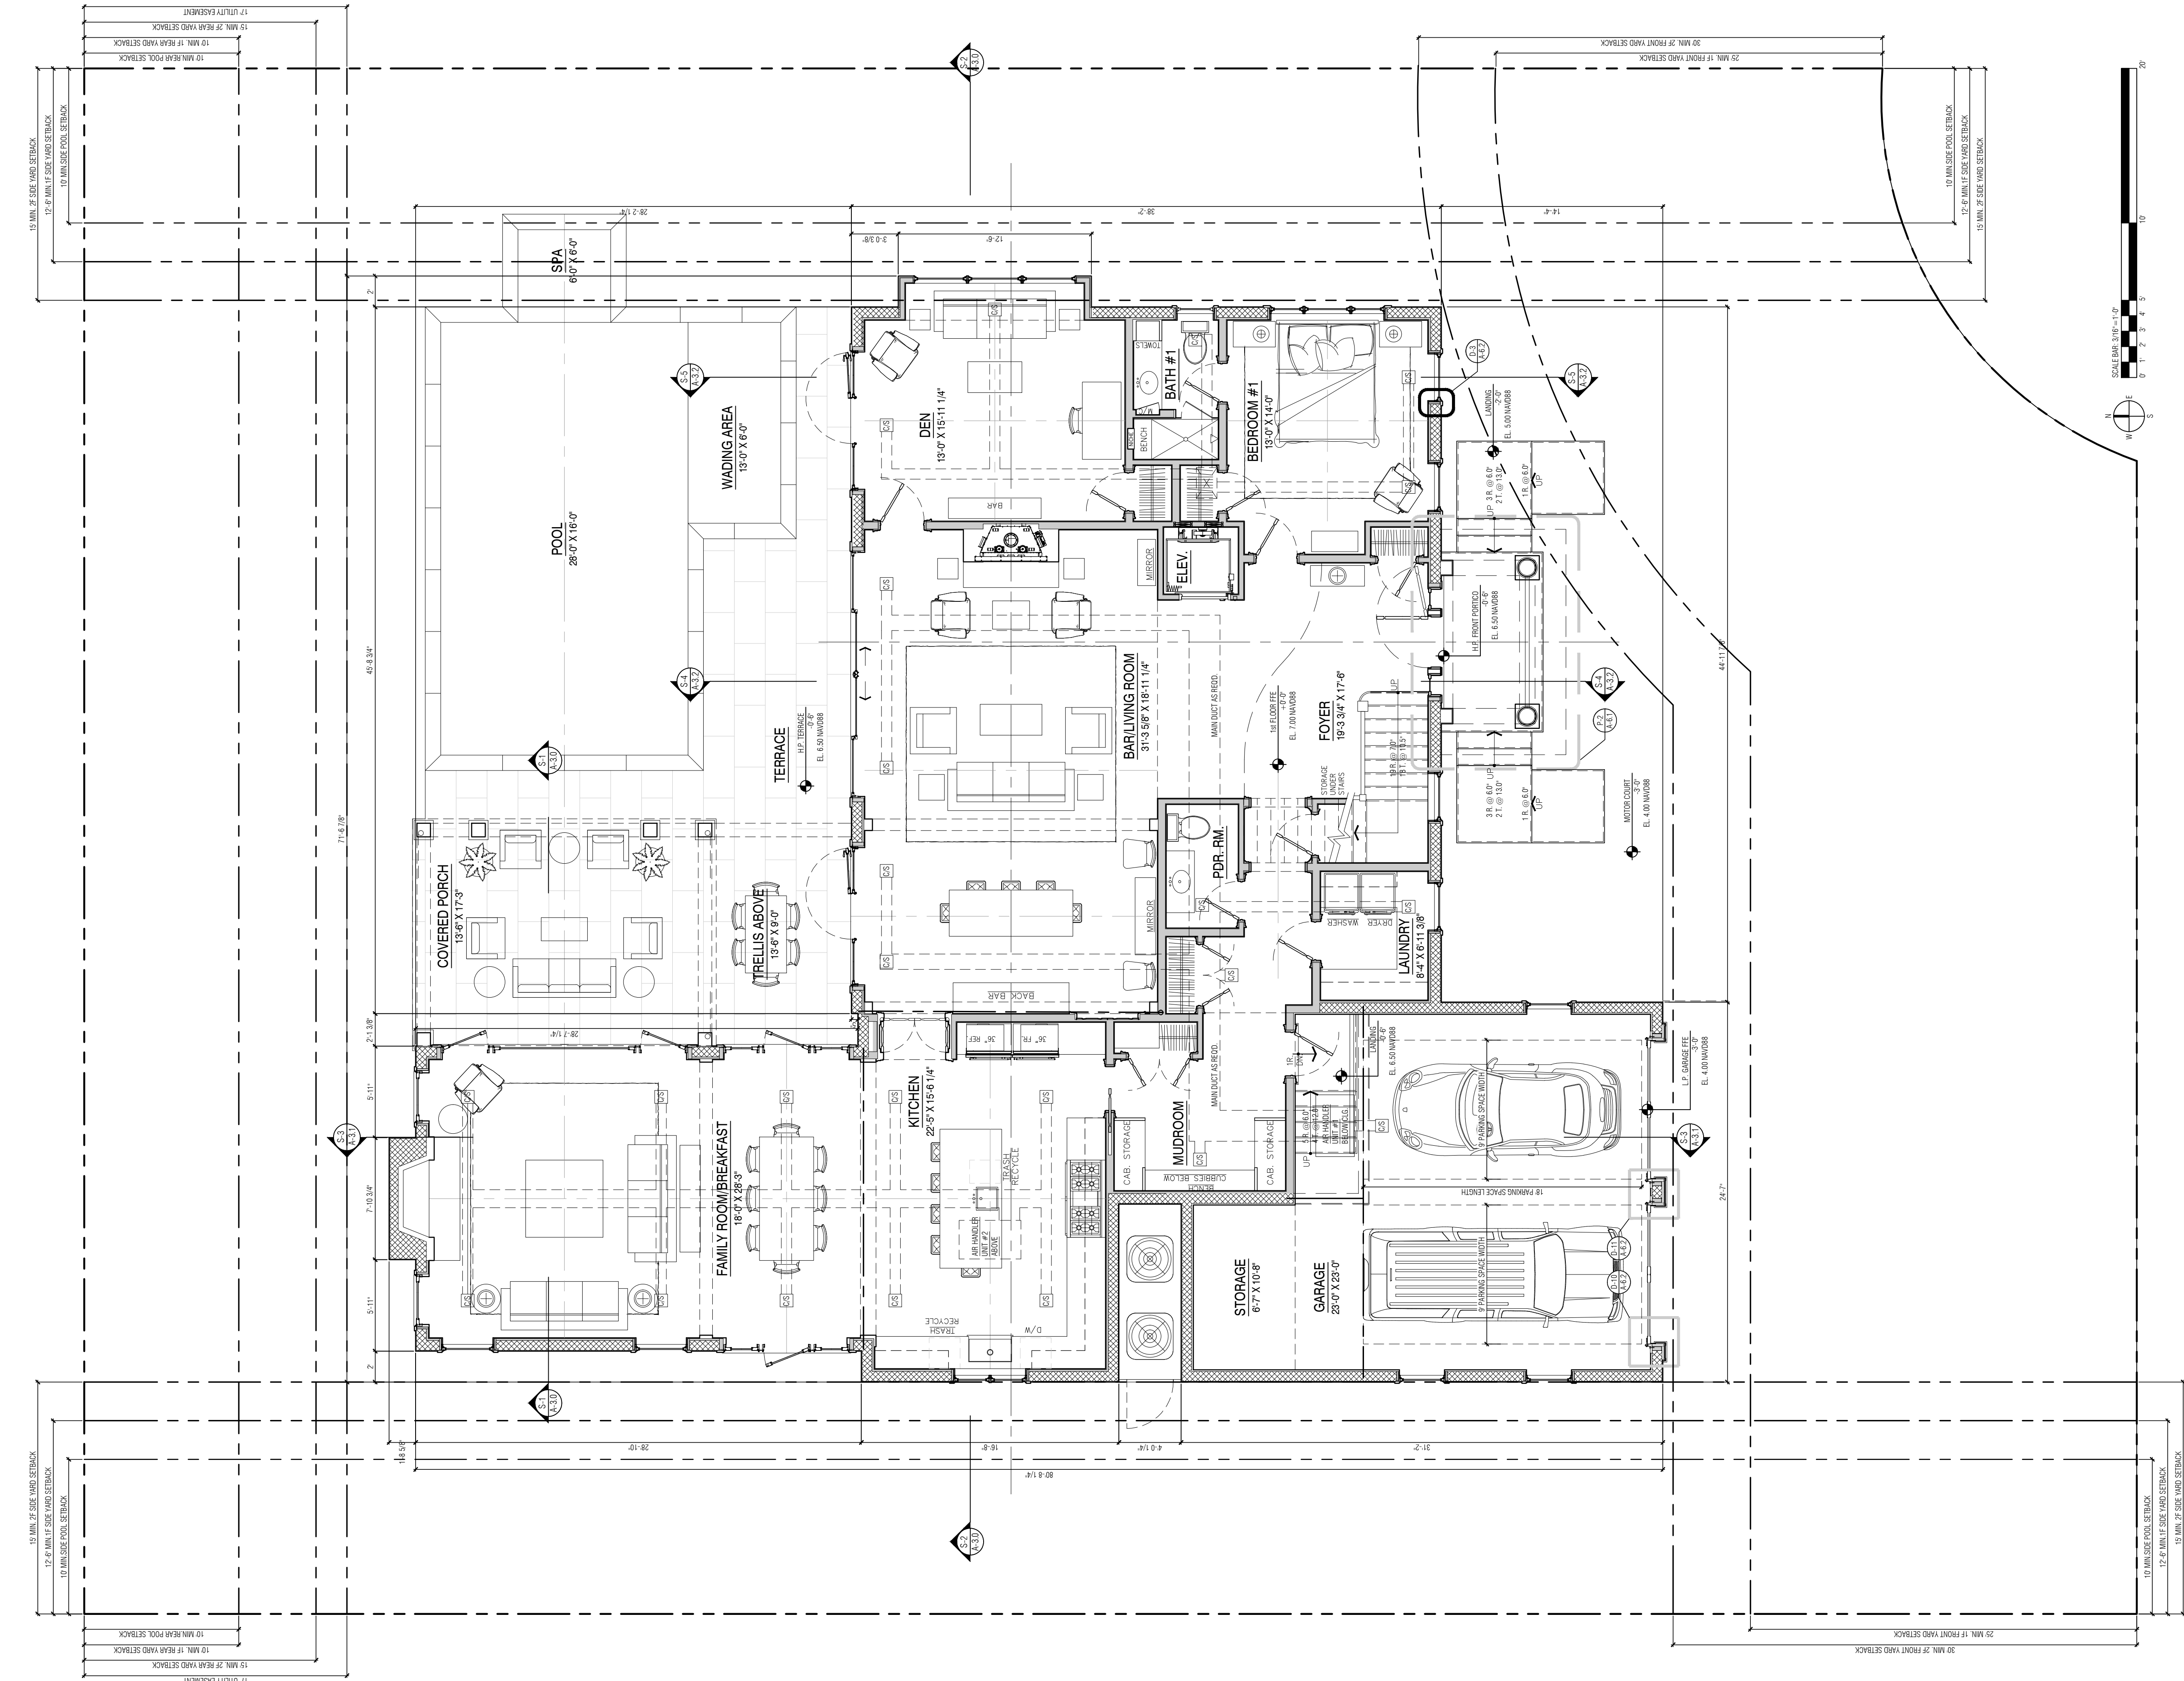

P-1 FIRST FLOOR PLAN
A-1.1 SCALE: 3/16"=1'-0"

NO. 1
DATE

1 FOR REVIEW
10-25-2019
2 FOR REVIEW
12-13-2019
3 PRELIMINARY, FOR REVIEW ONLY (ARCOM)
10-14-2023
4 FIRST SUBMITTAL (ARCOM)
11-02-2023
5 SECOND SUBMITTAL (ARCOM)
11-20-2023
6 FINAL SUBMITTAL (ARCOM)
12-07-2023
7 1st RESUBMISSION (ARCOM)
3-11-2024

CONSULTANTS:

PROFESSIONAL SEAL

THE DRAWINGS, SPECIFICATIONS, AND OTHER DOCUMENTS PREPARED BY KEAN DESIGNS LTD. FOR THE PROJECT, ARE PREPARED BY ARCHITECTURAL, CIVIL, MECHANICAL, ELECTRICAL, AND PLUMBING ENGINEERS. THE PROJECT IS A RESIDENTIAL DEVELOPMENT. THE DRAWINGS, SPECIFICATIONS, AND OTHER DOCUMENTS PREPARED BY KEAN DESIGNS LTD. FOR THE PROJECT, ARE PREPARED BY ARCHITECTURAL, CIVIL, MECHANICAL, ELECTRICAL, AND PLUMBING ENGINEERS. THE PROJECT IS A RESIDENTIAL DEVELOPMENT.

KEAN DESIGNS LTD.
5 MAIN STREET
COLD SPRING HARBOR
NEW YORK, 11724
T: +1 (631) 367-9696
E: info@keandesigns.com

PROJECT ADDRESS:
MIRAFLORES
260 MIRAFLORES DRIVE
TOWN OF PALM BEACH, FLORIDA


3/16" = 1'-0"
SCALE

ED, JTD
DRAWN

e 2016
JOB KEAN DESIGNS

A-1.1

FIRST FLOOR PLAN

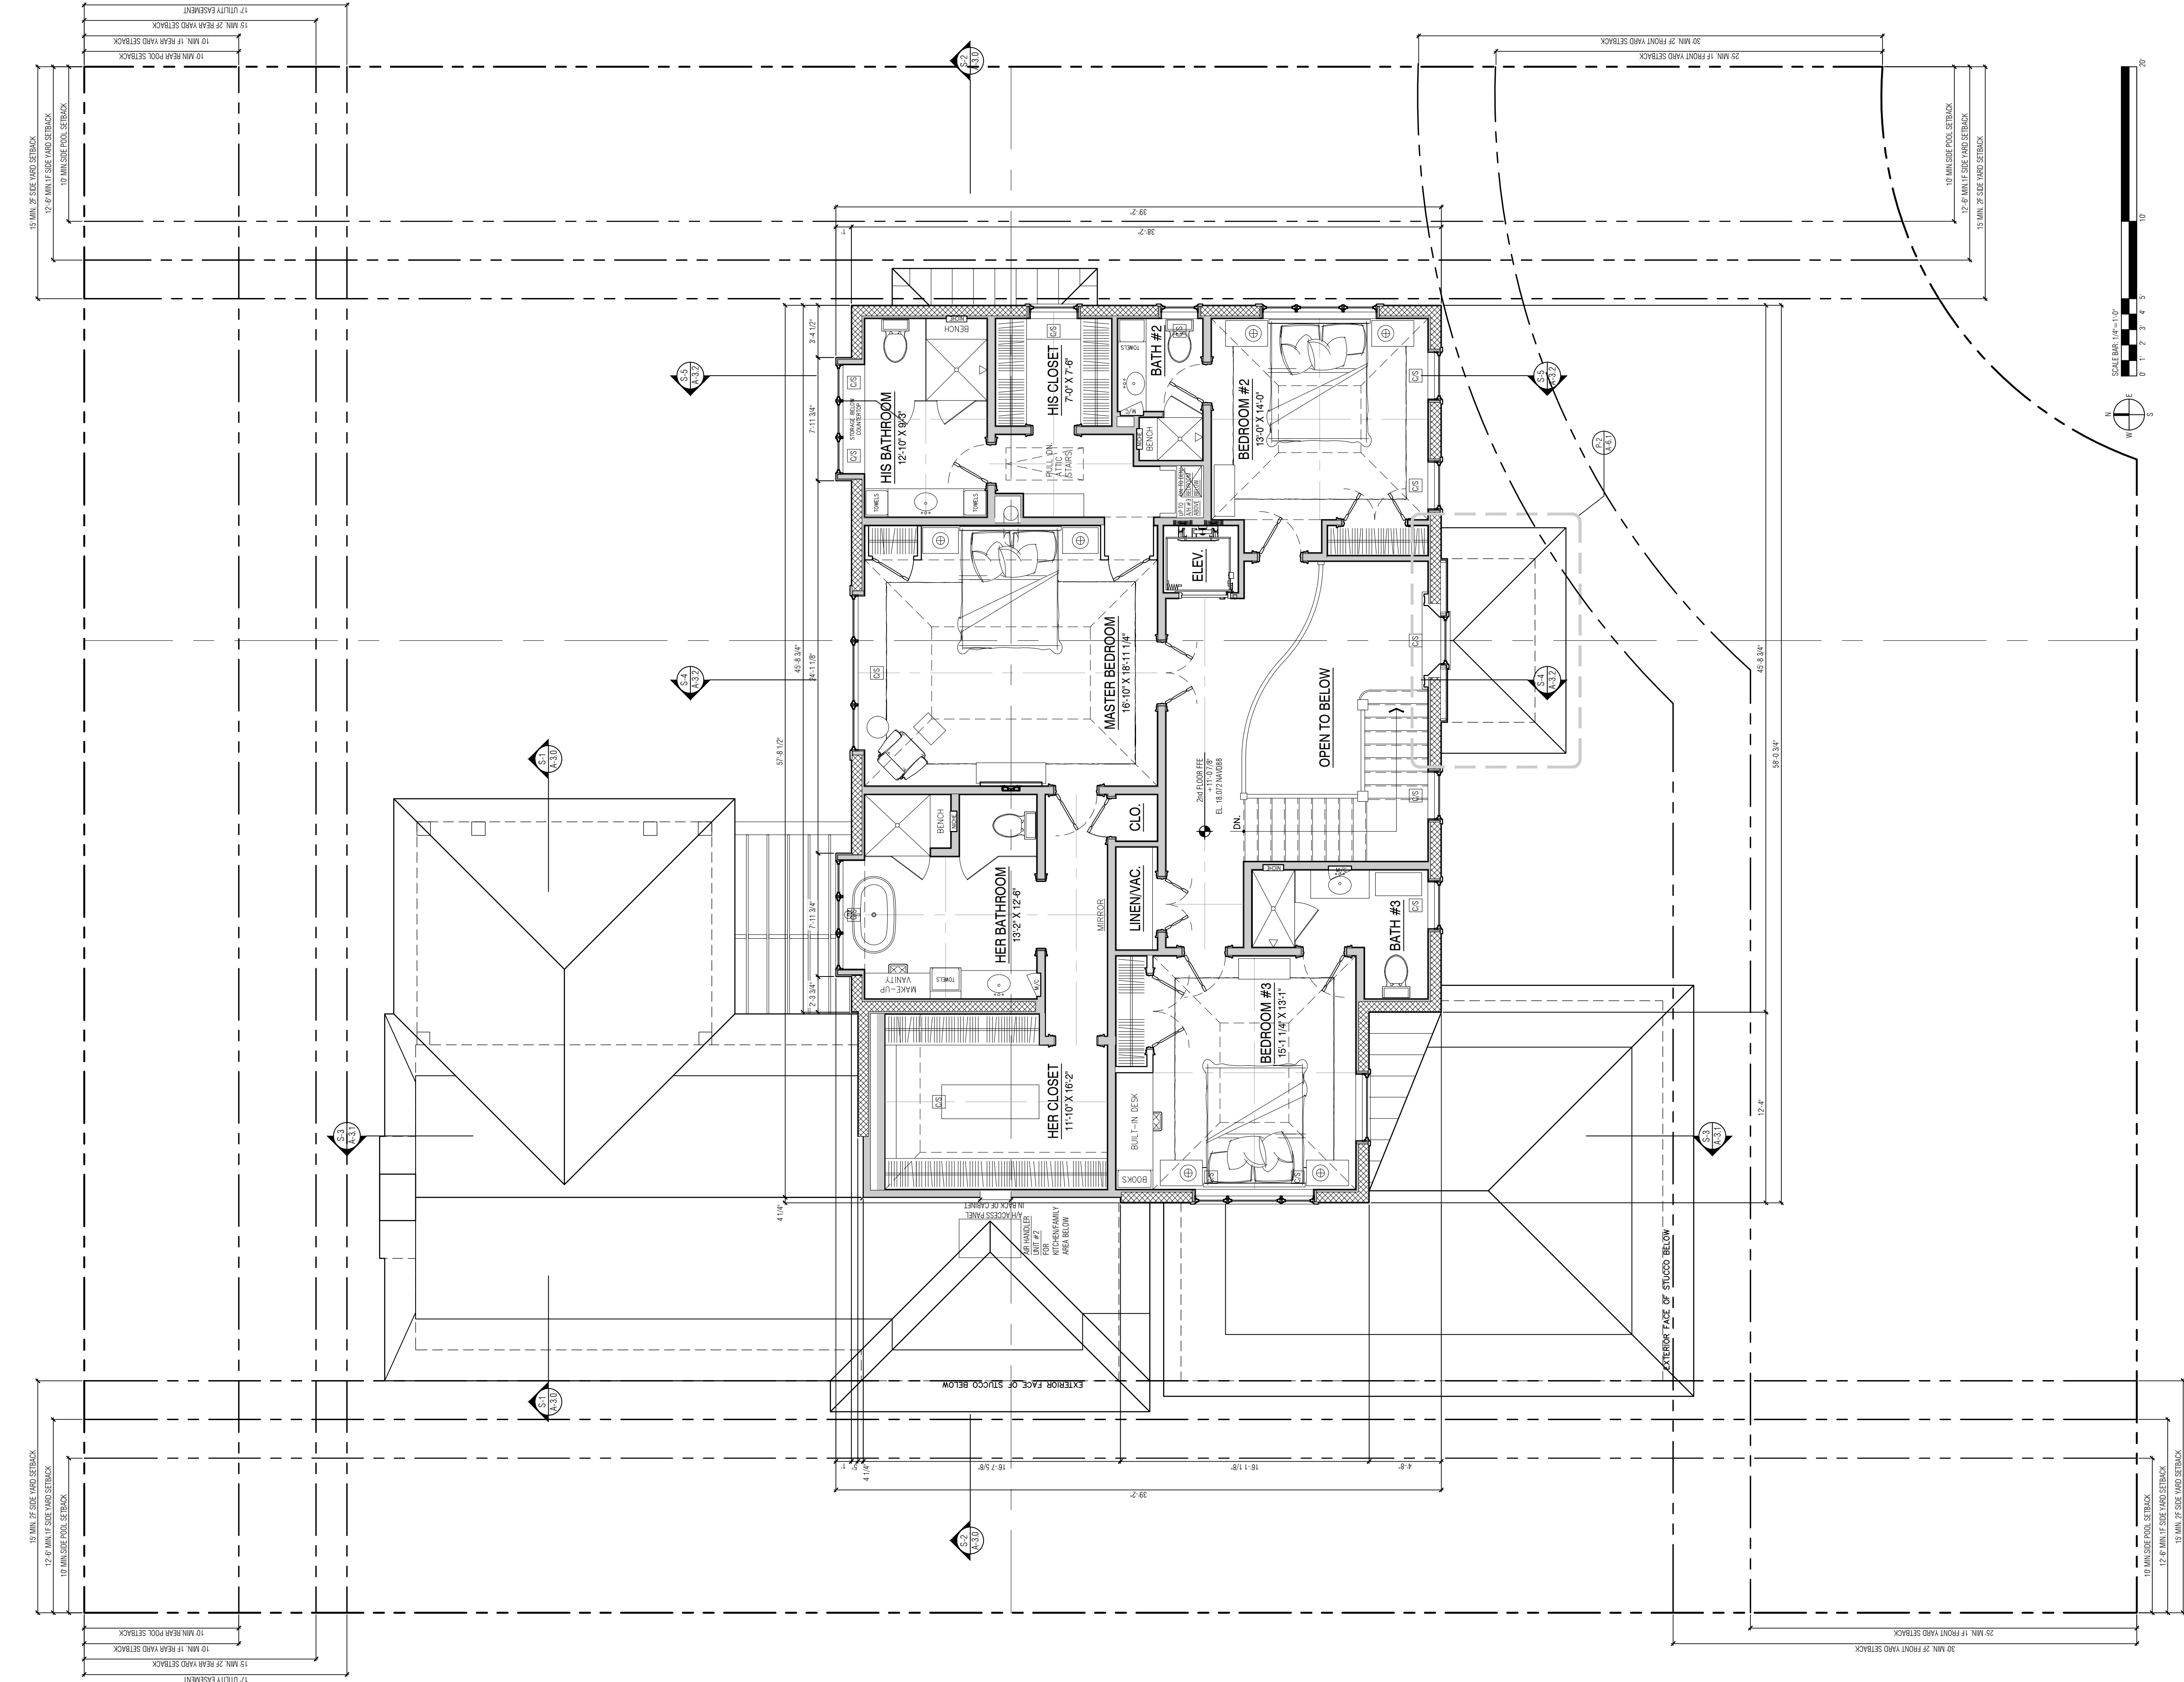

P-2 SECOND FLOOR PLAN
A-1.2 SCALE: 3/16"=1'-0"

DATE LOG	
NO.	ISSUE DATE
1	FOR REVIEW 10-15-2014
2	PRELIMINARY FOR REVIEW ONLY (ARCOM) 10-16-2014
3	FIRST SUBMITTAL (ARCOM) 11-03-2014
4	SECOND SUBMITTAL (ARCOM) 11-20-2014
5	FINAL SUBMITTAL (ARCOM) 12-07-2014
6	1st RESUBMISSION (ARCOM) 3-11-2015
7	
8	
9	
10	
11	
12	
13	
14	
15	
16	
17	

CONSULTANTS:

PROFESSIONAL SEAL:

THE DRAWINGS, SPECIFICATIONS, AND OTHER DOCUMENTS PREPARED BY KEAN DESIGNS LTD. FOR THE PROJECT, AND ANY SUPPLEMENTAL DOCUMENTS, SHALL BE THE PROPERTY OF KEAN DESIGNS LTD. AND SHALL REMAIN THE PROPERTY OF KEAN DESIGNS LTD. NO PART OF THESE DOCUMENTS SHALL BE REPRODUCED OR TRANSMITTED IN ANY FORM OR BY ANY MEANS, ELECTRONIC OR MECHANICAL, INCLUDING PHOTOCOPYING, RECORDING, OR BY ANY INFORMATION STORAGE AND RETRIEVAL SYSTEM, WITHOUT PERMISSION IN WRITING FROM KEAN DESIGNS LTD. THESE DOCUMENTS SHALL NOT BE USED BY THE USER FOR OTHER PROJECTS WITHOUT THE WRITTEN PERMISSION OF KEAN DESIGNS LTD. THE USER SHALL BE RESPONSIBLE FOR OBTAINING ALL NECESSARY PERMITS AND APPROVALS FROM THE APPROPRIATE AGENCIES FOR THE PROJECT AND FOR THE COMPLETION OF THE PROJECT AND FOR THE USER'S PROTECTION.



KEAN DESIGNS LTD.

5 MAIN STREET
COLD SPRING HARBOR
NEW YORK, 11724

T: +1 (631) 367-9696
E: info@keandesigns.com

PROJECT ADDRESS:


MIRAFLORES

260 MIRAFLORES DRIVE
TOWN OF PALM BEACH, FLORIDA

3/16" = 1'-0" | ED, JTD
SCALE | DRAWN

JOB | c 2016
KEAN DESIGNS


A-1.2

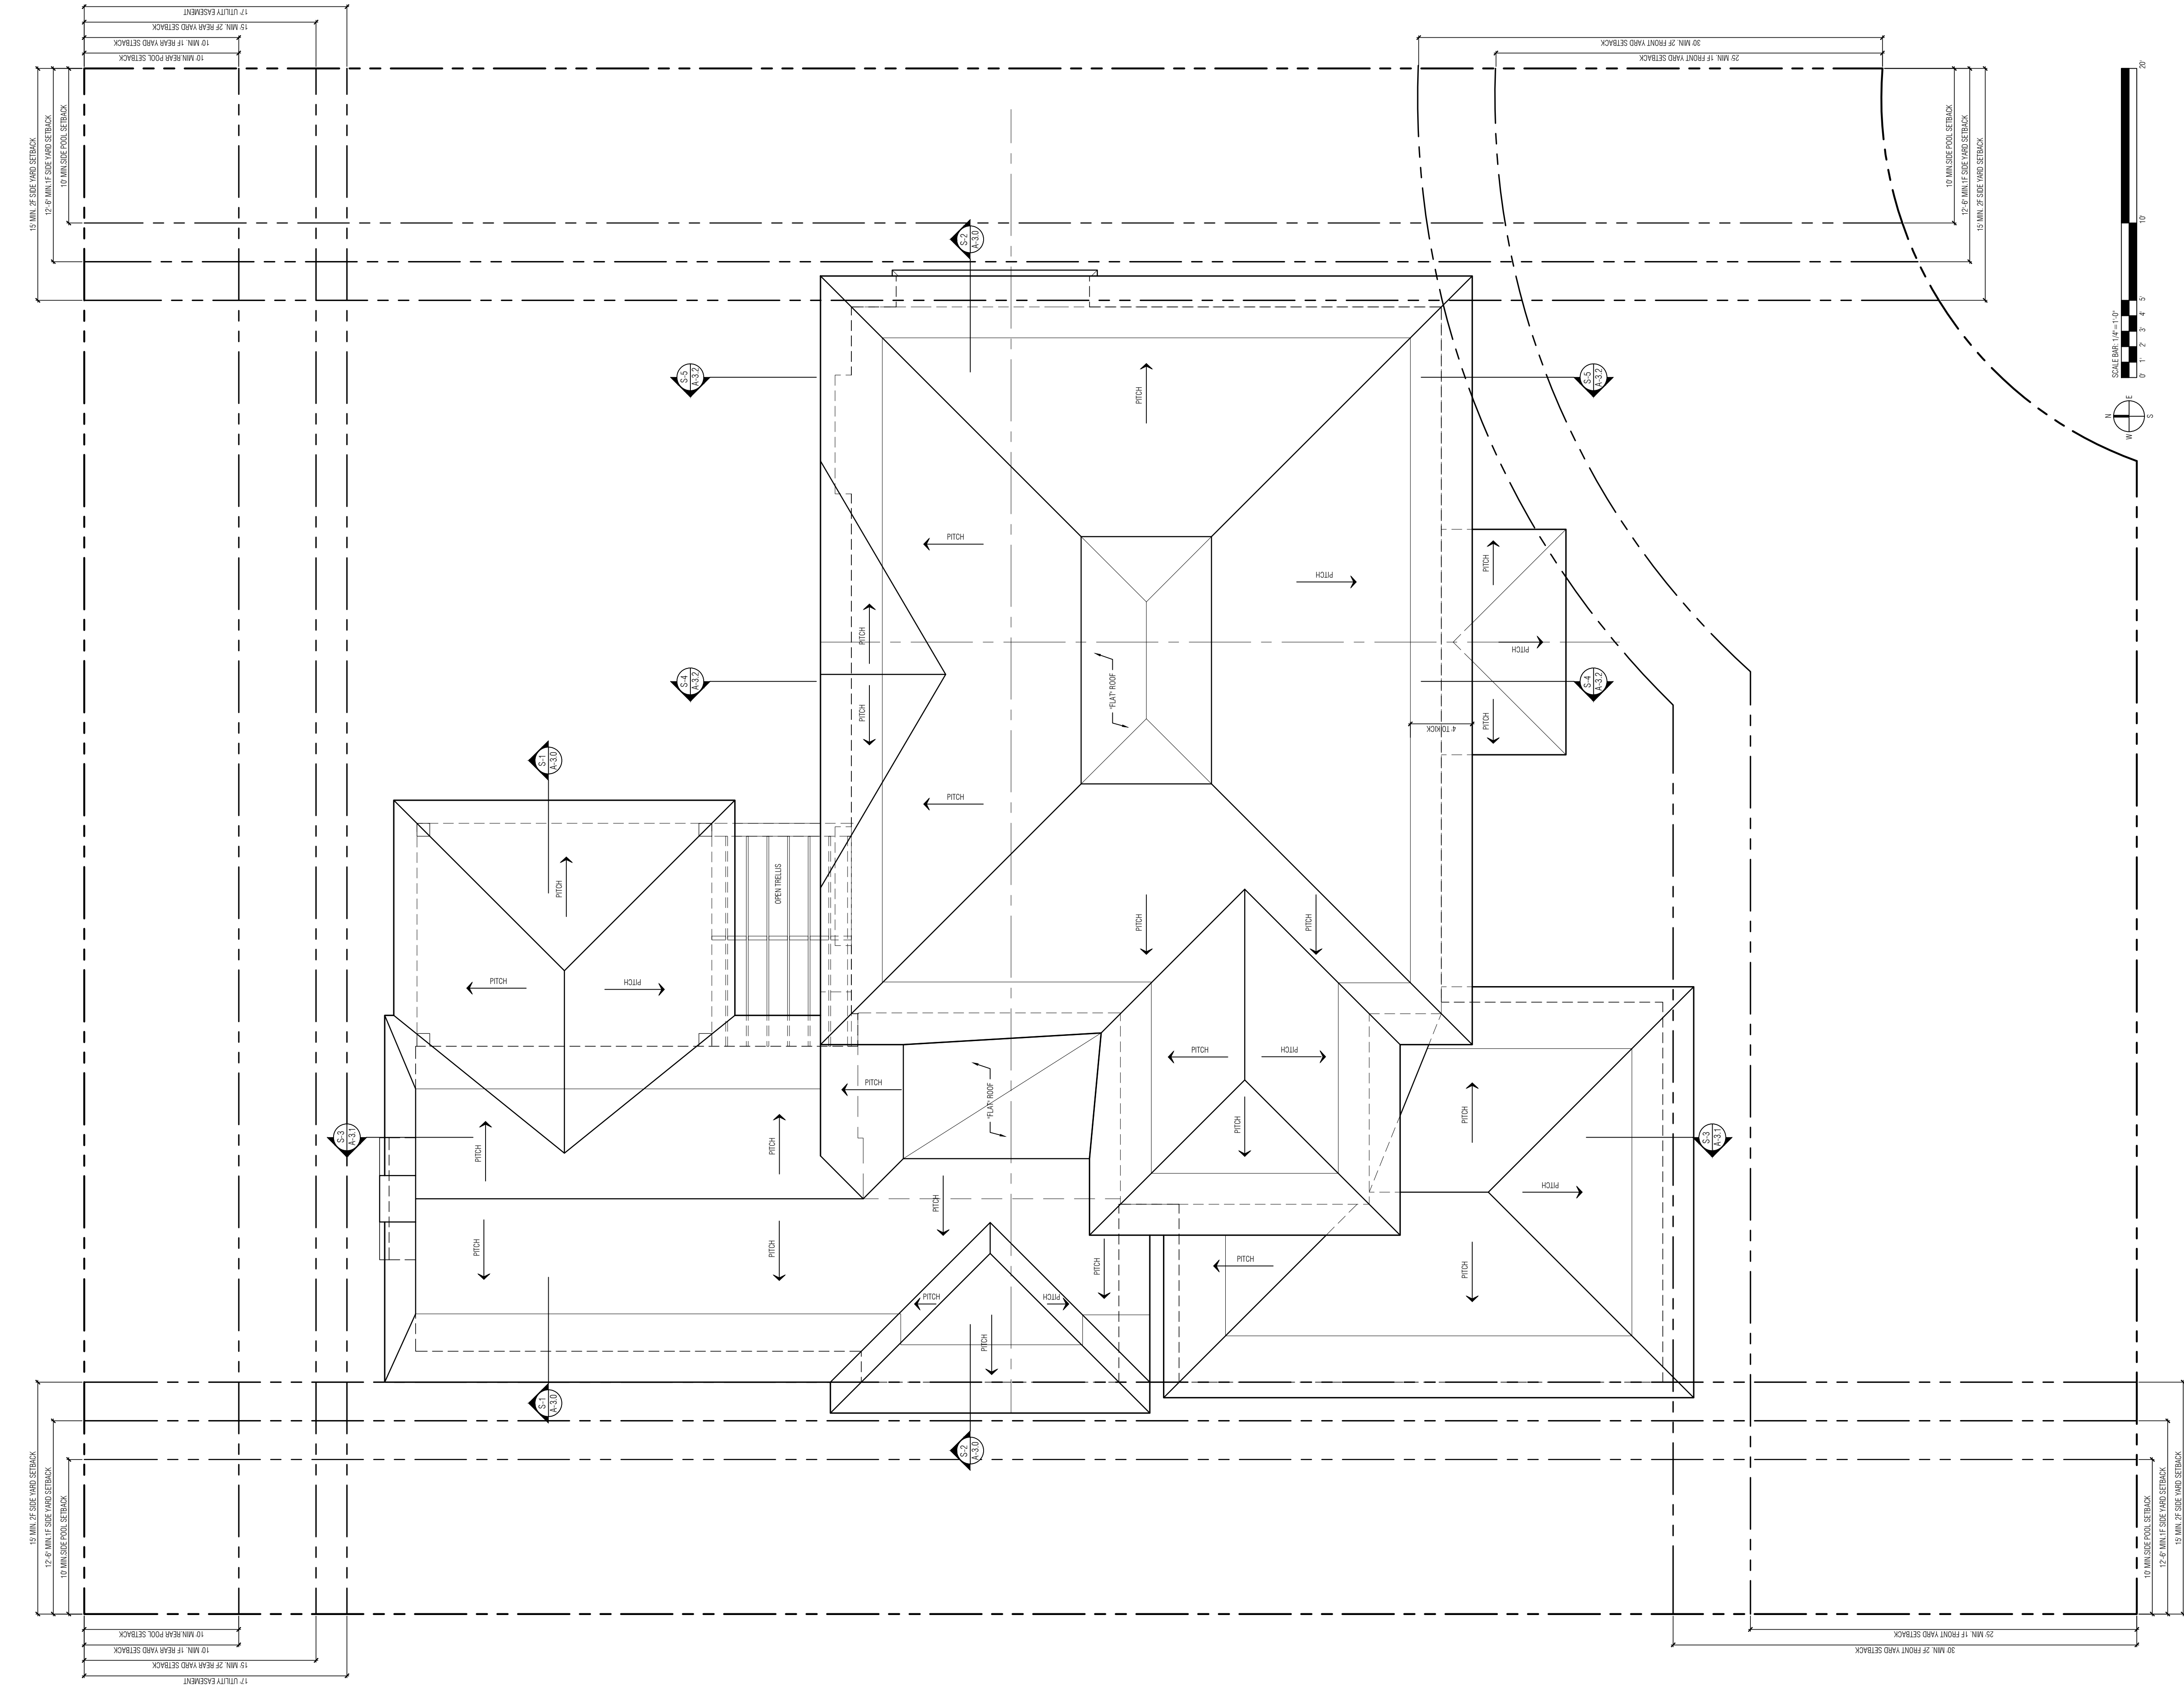

P-3
A-1.3

ROOF PLAN

 
SCALE: 3/16"=1'-0"



DATE LOG	
NO.	ISSUE DATE
1	FOR REVIEW 10-23-2019
2	PRELIMINARY FOR REVIEW ONLY (ARCOM) 10-16-2023
3	FIRST SUBMITTAL (ARCOM) 11-03-2023
4	SECOND SUBMITTAL (ARCOM) 11-20-2023
5	FINAL SUBMITTAL (ARCOM) 12-07-2023
6	1st RESUBMISSION (ARCOM) 3-11-2024
7	
8	
9	
10	
11	
12	
13	
14	
15	
16	
17	

CONSULTANTS:

PROFESSIONAL SEAL:

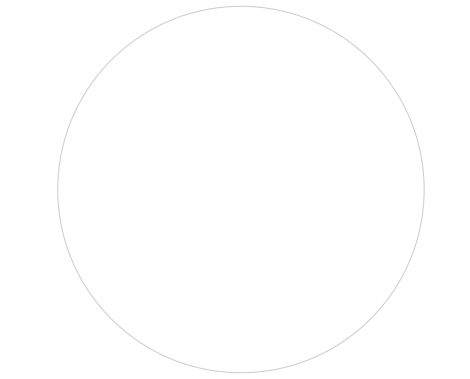

THE DRAWINGS, SPECIFICATIONS, AND OTHER DOCUMENTS PREPARED BY KEAN DESIGNS LTD. FOR THE PROJECT, AND ANY SUPPLEMENTAL NOTATIONS, CORRECTIONS, OR ADDENDUMS, SHALL BE THE PROPERTY OF KEAN DESIGNS LTD. AND SHALL REMAIN THE PROPERTY OF KEAN DESIGNS LTD. NO PART OF THESE DOCUMENTS SHALL BE REPRODUCED OR TRANSMITTED IN ANY FORM OR BY ANY MEANS, ELECTRONIC OR MECHANICAL, WITHOUT PERMISSION IN WRITING FROM KEAN DESIGNS LTD. THE USER OF THESE DOCUMENTS SHALL BE SOLELY RESPONSIBLE FOR OBTAINING ALL NECESSARY PERMITS AND APPROVALS FROM THE APPROPRIATE AGENCIES AND FOR THE COMPLETION OF THIS PROJECT AND OTHERS.



KEAN DESIGNS LTD.

5 MAIN STREET
COLD SPRING HARBOR
NEW YORK, 11724

T: +1 (631) 367-9696
E: info@keandesigns.com

PROJECT ADDRESS:

MIRAFLORES

260 MIRAFLORES DRIVE
TOWN OF PALM BEACH, FLORIDA

3/16" = 1'-0" | ED, LTD
SCALE DRAWN


JOB | e 2016
KEAN DESIGNS

A-1.3

ROOF PLAN



E-1 FRONT ELEVATION
A-2.0 SCALE: 1/4" = 1'-0"

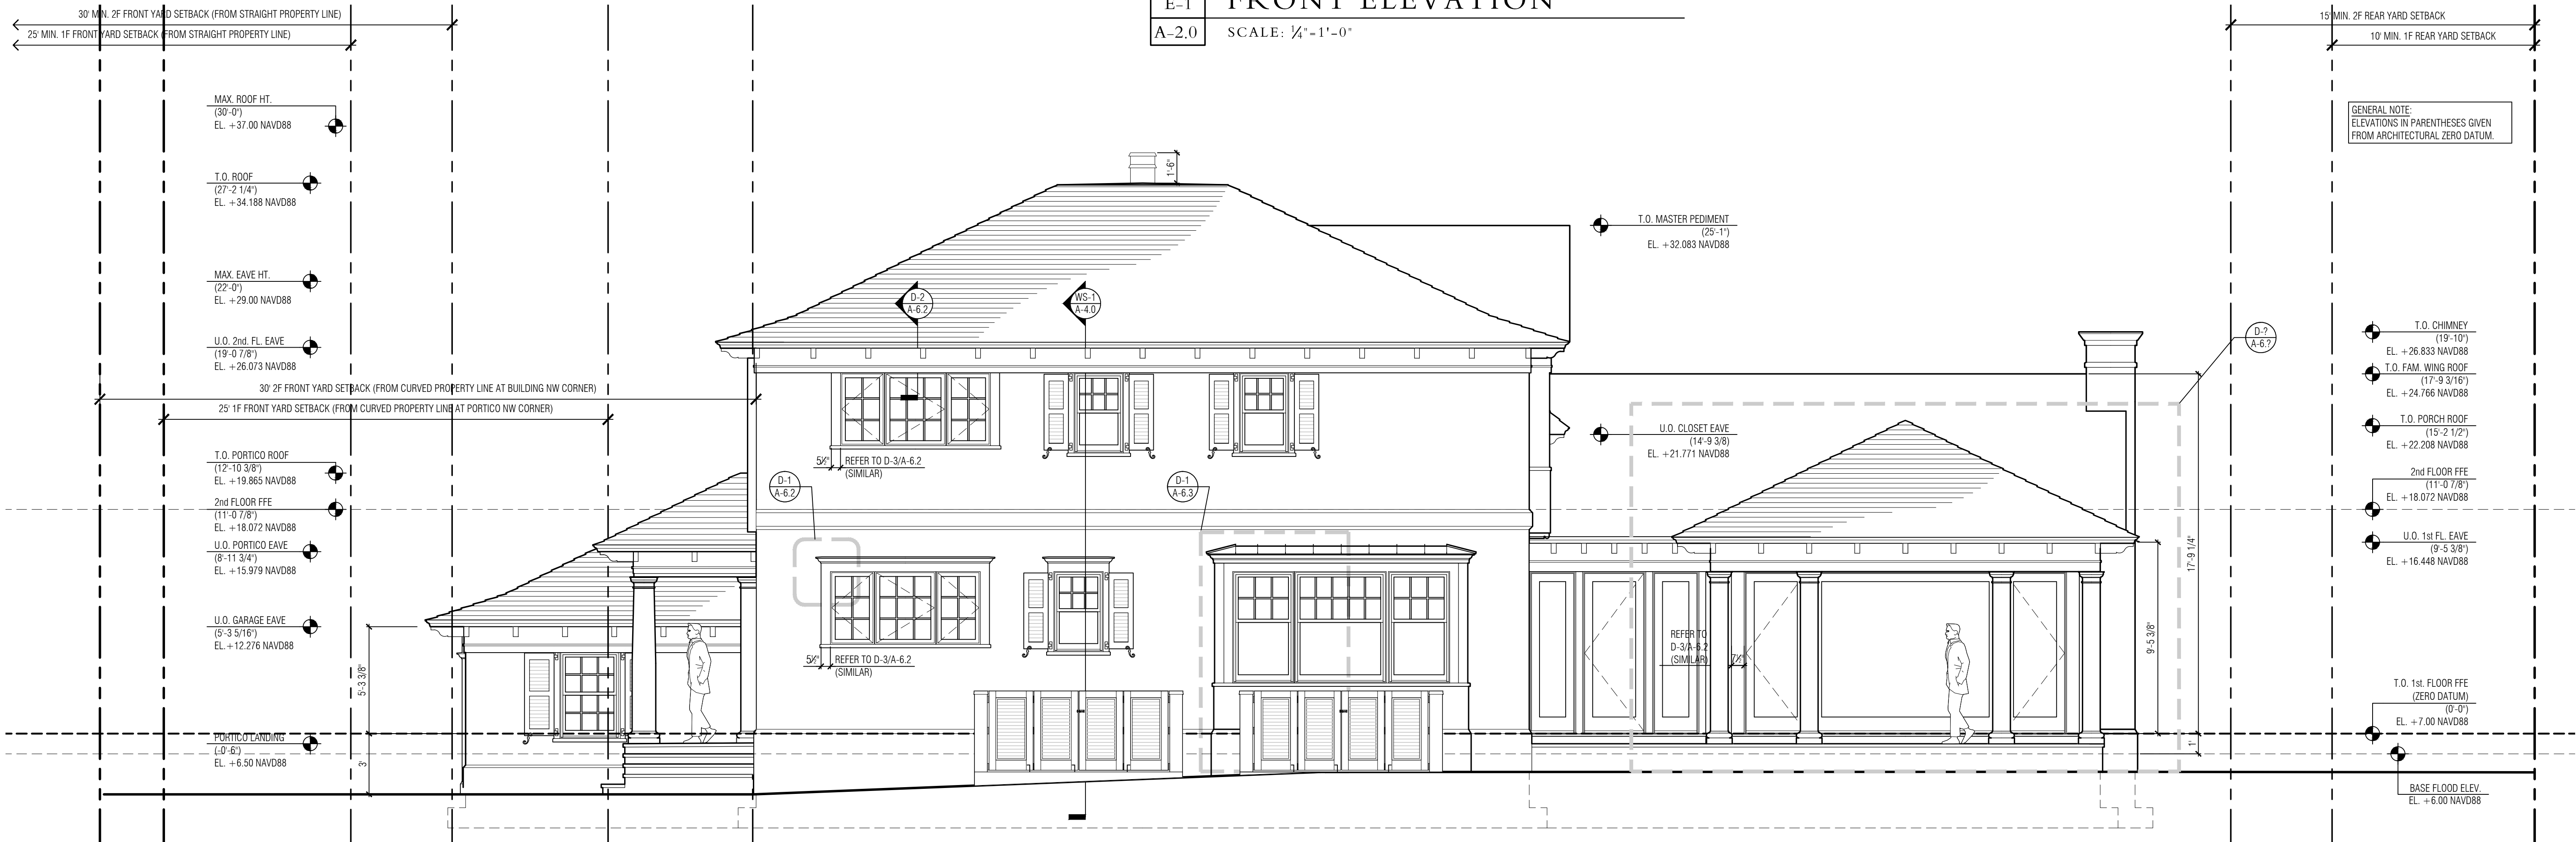

E-2 RIGHT SIDE ELEVATION
A-2.0 SCALE: 1/4" = 1'-0"


EXTERIOR MATERIAL NOTES:

- ROOF MATERIAL NOTES:**
- CEDAR SHAKES AS SELECTED BY OWNER, WITH HIP AND RIDGE CAPS; COPPER FLASHING WHERE APPLICABLE.
 - RED COPPER STANDING SEAM ROOF.
 - RED COPPER GUTTERS AND LEADERS.
 - REFER TO ROOF PLAN DWG. A-1.3 FOR ADDITIONAL INFORMATION.
- SIDING AND TRIM MATERIAL NOTES:**
- WHITE STUCCO WALL SURFACES.
 - PAINTED AZEK CASINGS AND TRIM.
 - PAINTED AZEK FRIEZE, FASCIAS AND TRIM.
 - TIMBERLINE ENDURIAN SHUTTERS W/ HARDWARE AS SELECTED. (STYLE, COLOR AND HARDWARE SHUTTER SCHEDULE TO BE DETERMINED)
- WINDOW NOTES:**
- MARVIN SIGNATURE ULTIMATE CLAD HURRICANE-RATED WINDOWS.
 - LITE-CUTS AS SHOWN ON ELEVATIONS.
- MASONRY NOTES:**
- STUCCO VENEER CHIMNEYS.
 - LIMESTONE PAVERS AT ALL PORCHES AND TREADS.

DATE LOG	
NO.	ISSUE DATE
1	FOR REVIEW 10-25-2019
2	FOR REVIEW 12-13-2019
3	PRELIMINARY, FOR REVIEW ONLY (ARCOM) 10-14-2023
4	FIRST SUBMITTAL (ARCOM) 11-02-2023
5	SECOND SUBMITTAL (ARCOM) 11-20-2023
6	FINAL SUBMITTAL (ARCOM) 12-07-2023
7	1st RESUBMISSION (ARCOM) 3-11-2024
8	
9	
10	
11	
12	
13	
14	
15	
16	
17	

CONSULTANTS:

PROFESSIONAL SEAL:

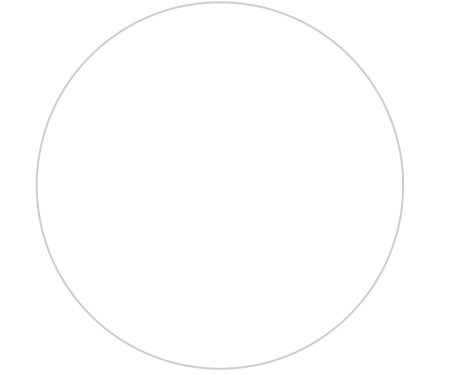

THE DRAWINGS, SPECIFICATIONS, AND OTHER DOCUMENTS PREPARED BY KEAN DESIGNS LTD. FOR THE PROJECT, ARE HEREBY SUBMITTED TO THE PROJECT OWNER, AS A PROFESSIONAL SERVICE, FOR THE REVIEW AND APPROVAL OF THE PROJECT OWNER. THE PROJECT OWNER'S REVIEW AND APPROVAL OF THESE DOCUMENTS DOES NOT CONSTITUTE A GUARANTEE OF THE ACCURACY OR COMPLETENESS OF THE INFORMATION PROVIDED HEREIN. THE PROJECT OWNER'S REVIEW AND APPROVAL OF THESE DOCUMENTS DOES NOT CONSTITUTE A GUARANTEE OF THE ACCURACY OR COMPLETENESS OF THE INFORMATION PROVIDED HEREIN.



KEAN DESIGNS LTD.

5 MAIN STREET
COLD SPRING HARBOR
NEW YORK, 11724

T: +1 (631) 367-9696
E: info@keandesigns.com

PROJECT ADDRESS:

MIRAFLORES

260 MIRAFLORES DRIVE
TOWN OF PALM BEACH, FLORIDA


1/4" = 1'-0" ED, JTD
SCALE DESIGNS

JOB KEAN-DESIGNS


© 2016

A-2.0

EXTERIOR ELEVATIONS

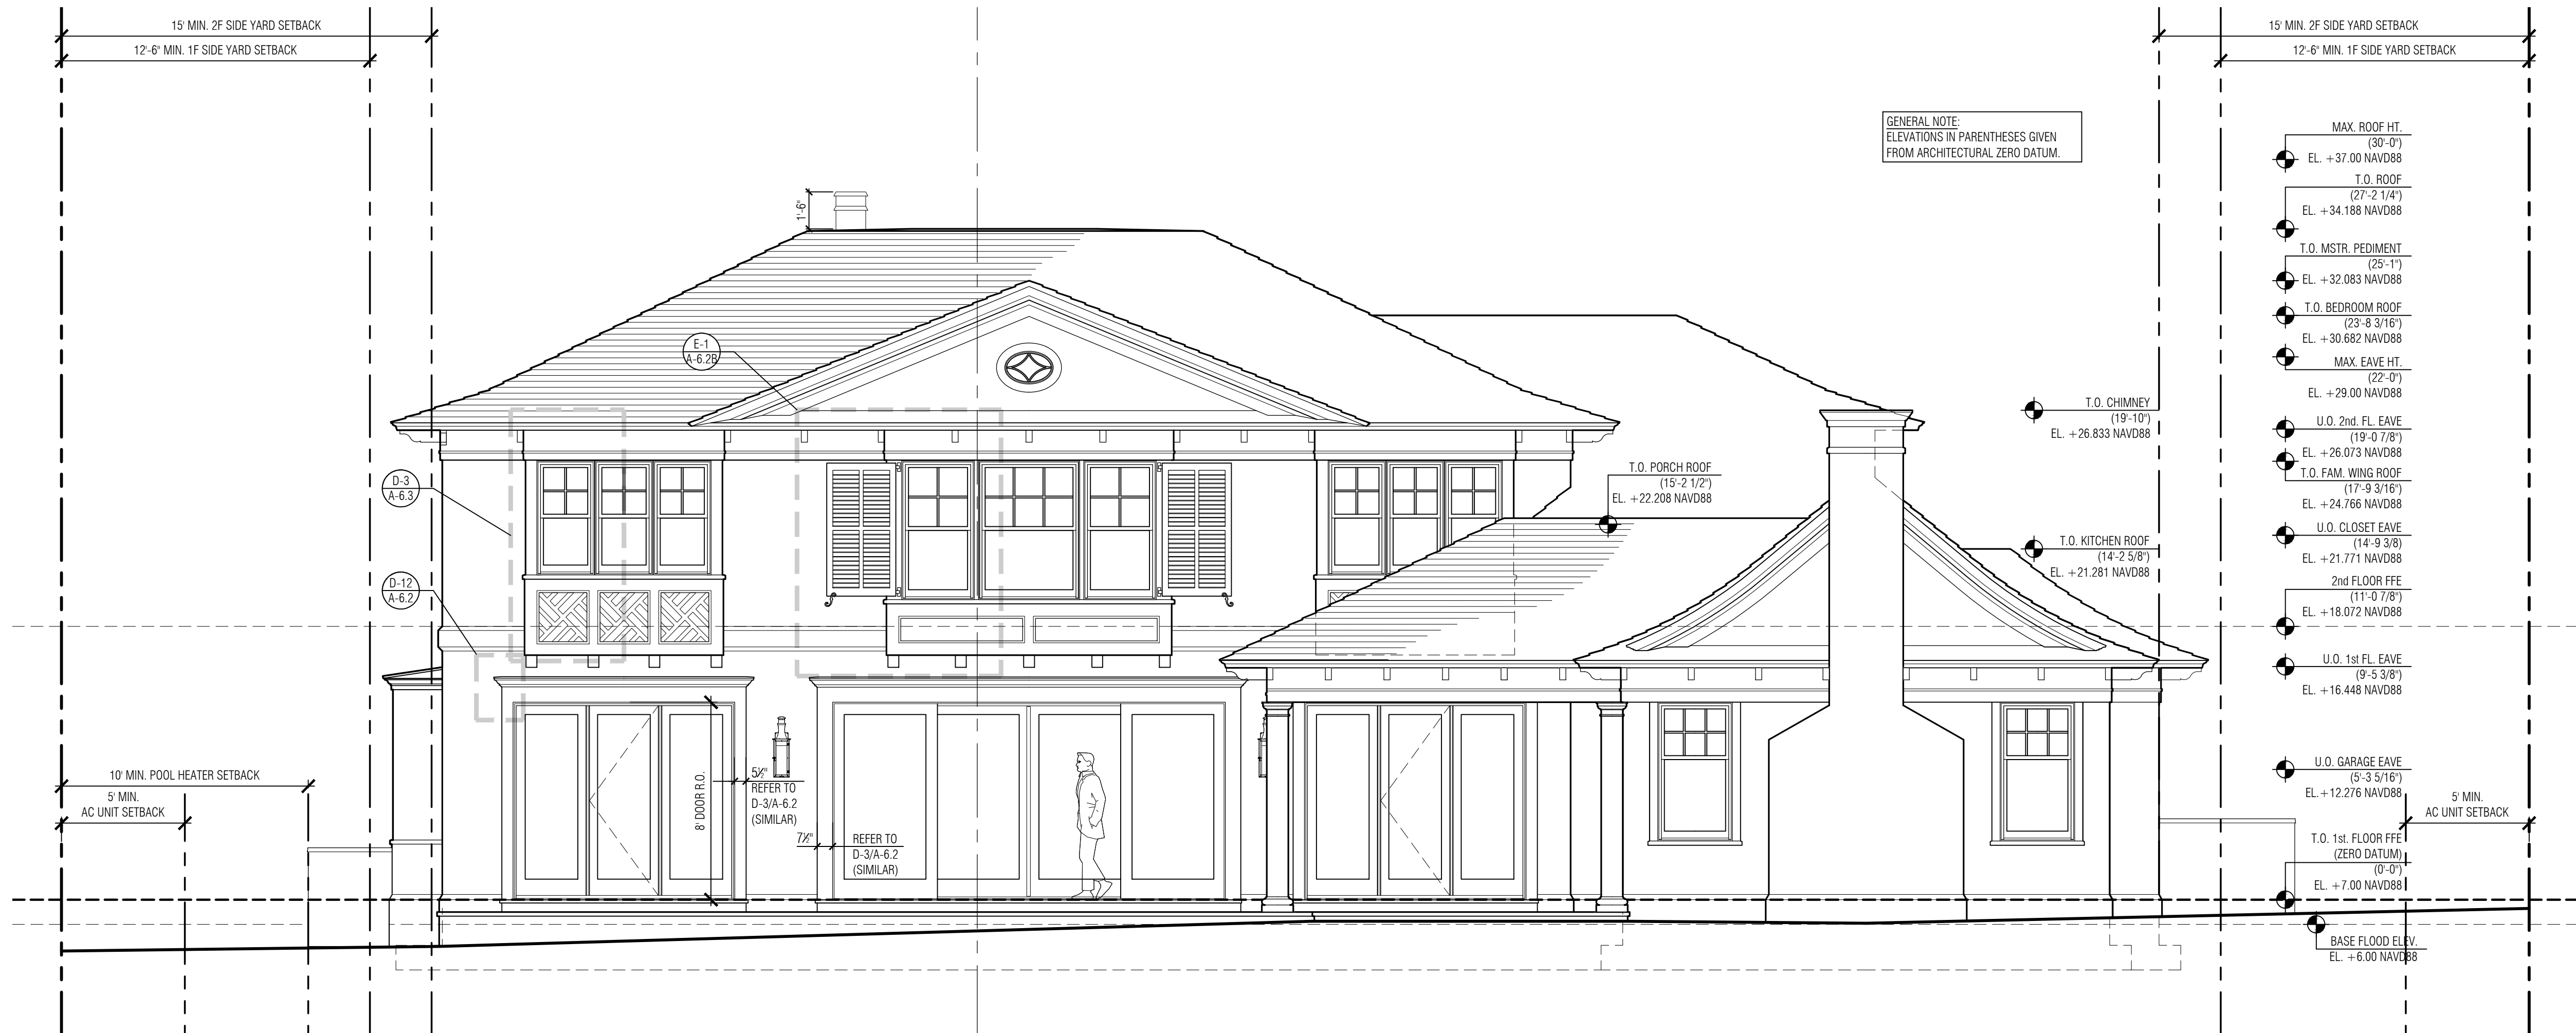


E-3 REAR ELEVATION
A-2.1 SCALE: 1/4" = 1'-0"

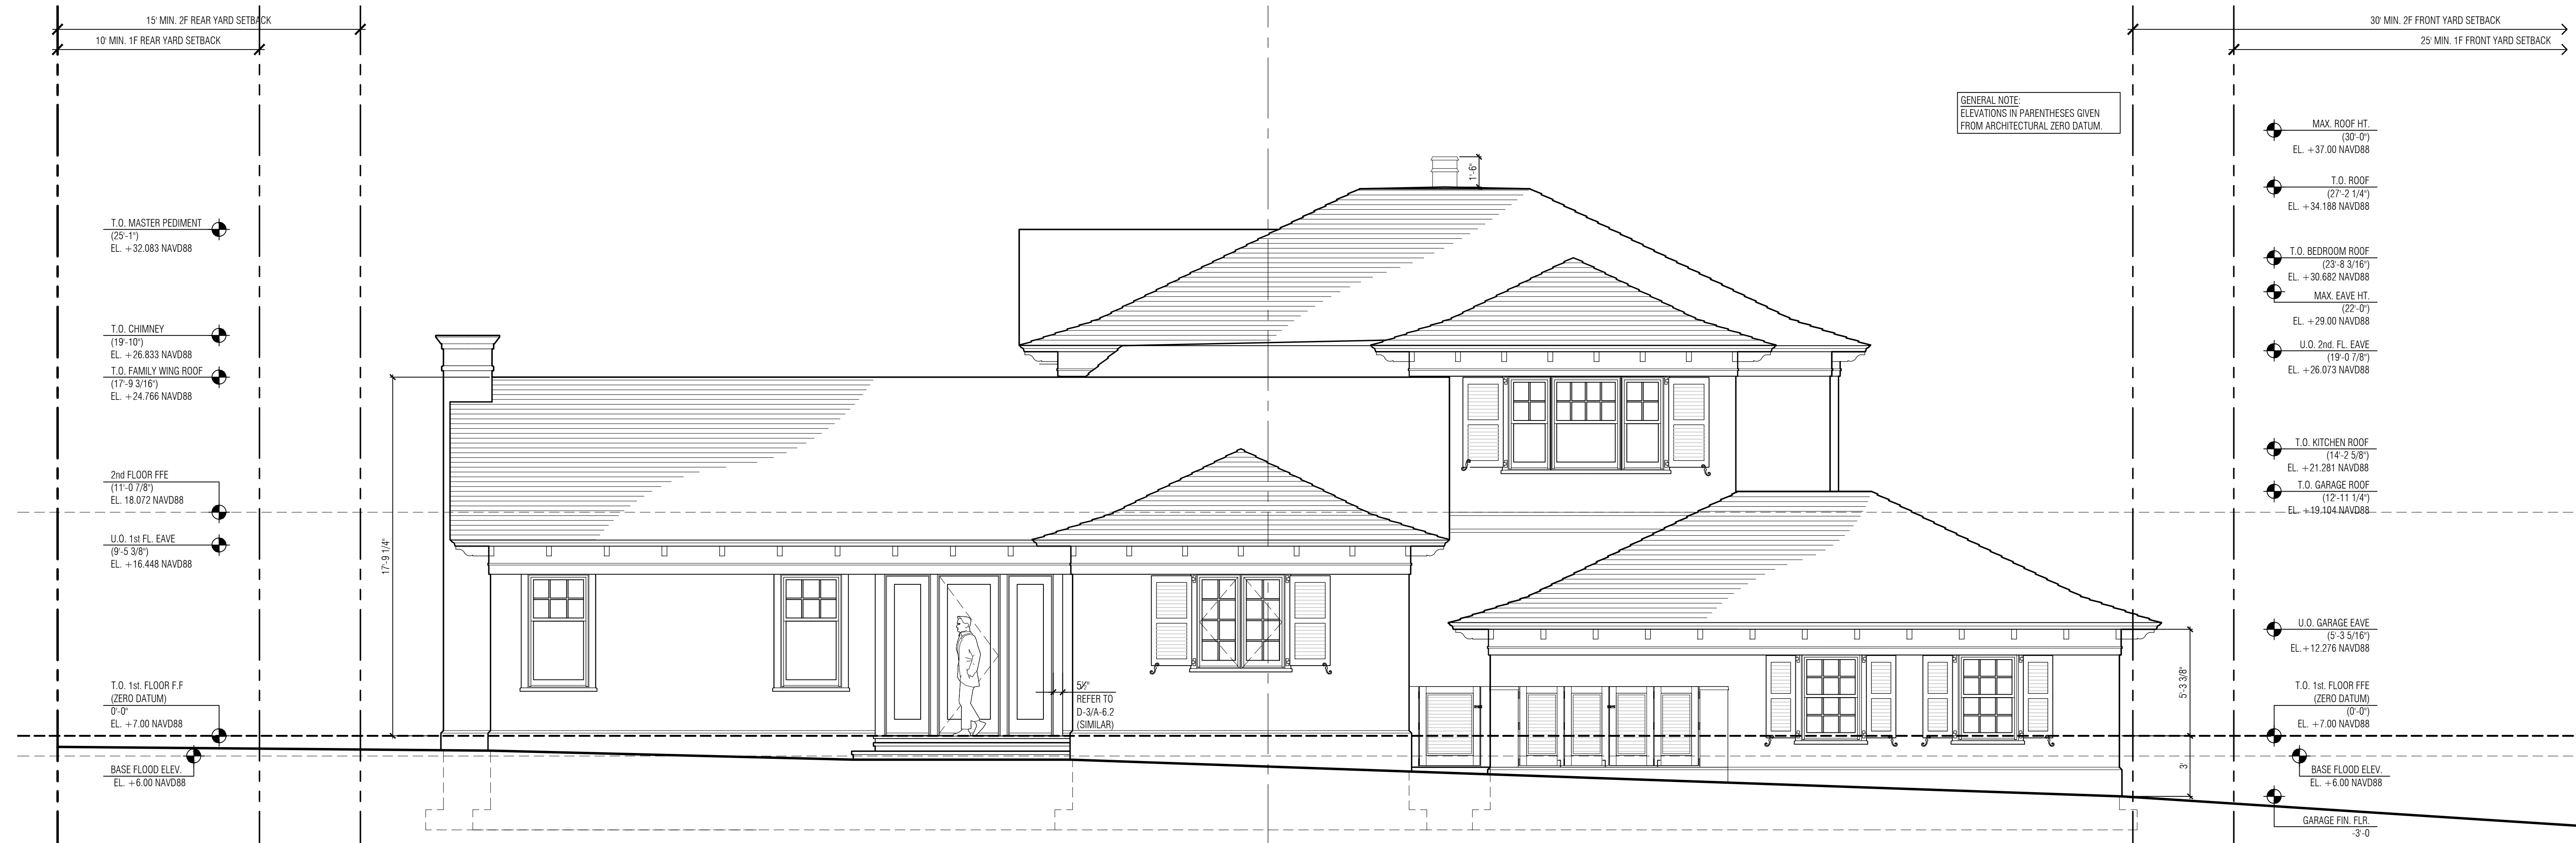

E-4 LEFT SIDE ELEVATION
A-2.1 SCALE: 1/4" = 1'-0"

DATE LOG	
NO.	ISSUE DATE
1	FOR REVIEW 10-25-2019
2	FOR REVIEW 12-13-2019
3	PRELIMINARY FOR REVIEW ONLY (ARCOM) 10-14-2023
4	FIRST SUBMITTAL (ARCOM) 11-02-2023
5	SECOND SUBMITTAL (ARCOM) 11-20-2023
6	FINAL SUBMITTAL (ARCOM) 12-07-2023
7	1st RESUBMISSION (ARCOM) 3-11-2024
8	
9	
10	
11	
12	
13	
14	
15	
16	
17	
CONSULTANTS	
PROFESSIONAL SEAL	

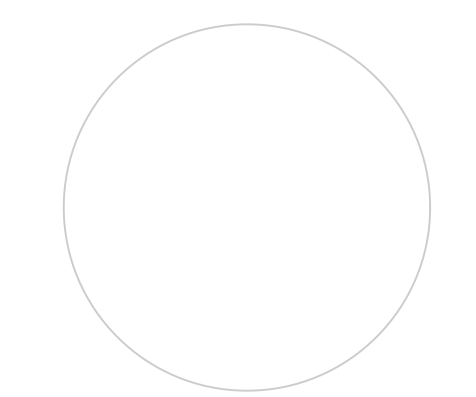

THE DRAWINGS, SPECIFICATIONS, AND OTHER DOCUMENTS PREPARED BY KEAN DESIGNS LTD. FOR THE PROJECT, AND ANYMENTS OF WORK, SHALL BE THE PROPERTY OF KEAN DESIGNS LTD. AND SHALL NOT BE REPRODUCED, COPIED, OR USED IN ANY MANNER WITHOUT THE WRITTEN CONSENT OF KEAN DESIGNS LTD. ANY SUCH REPRODUCTION OR USE WITHOUT THE WRITTEN CONSENT OF KEAN DESIGNS LTD. SHALL BE AT THE USER'S SOLE RISK AND WITHOUT LIABILITY TO KEAN DESIGNS LTD. FOR ANY DAMAGE OR LOSS, INCLUDING REASONABLE ATTORNEY'S FEES AND COSTS, INCURRED BY KEAN DESIGNS LTD. IN CONNECTION WITH THE PROTECTION OF ITS INTELLECTUAL PROPERTY RIGHTS. THIS AGREEMENT SHALL BE GOVERNED BY THE LATEST EDITION OF THE PROFESSIONAL SEAL ACT, AS APPLICABLE TO THE PROJECT, AND THE USER'S SOLE RISK AND WITHOUT LIABILITY TO KEAN DESIGNS LTD. FOR ANY DAMAGE OR LOSS, INCLUDING REASONABLE ATTORNEY'S FEES AND COSTS, INCURRED BY KEAN DESIGNS LTD. IN CONNECTION WITH THE PROTECTION OF ITS INTELLECTUAL PROPERTY RIGHTS.



KEAN DESIGNS LTD.
5 MAIN STREET
COLD SPRING HARBOR
NEW YORK, 11724
T: +1 (631) 367-9696
E: info@keandesigns.com

PROJECT ADDRESS:
MIRAFLORES
260 MIRAFLORES DRIVE
TOWN OF PALM BEACH, FLORIDA

1/4" = 1'-0" ED: JTD
SCALE DESIGNS

e 2016
JOB KEAN DESIGNS

A-2.1

EXTERIOR ELEVATIONS