




O'KEEFFE BUILDING

COVER

B-0.0.0

Final Submittal

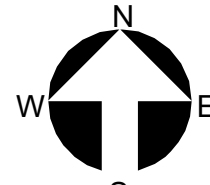

Project no: 2953
Date: 2024.10.07
Drawn by: Author
Project Manager: Checker

Revisions

THESE DRAWINGS ARE FOR THE EXCLUSIVE USE OF SPINA OROURKE + PARTNERS, INC. AND MAY NOT BE REPRODUCED, COPIED, OR USED IN ANY MANNER WITHOUT THE EXPRESS WRITTEN CONSENT OF SPINA OROURKE + PARTNERS, INC. ALL RIGHTS ARE RESERVED.

The Society of the Four Arts -
Esther B. O'Keeffe Building

100 Four Arts Plaza, Palm Beach, FL 33480




SPINA OROURKE
+ PARTNERS
Architecture • Interior Design
Keith M. Spina #


285 Banyan Blvd
West Palm Beach
FL 33407
spinaorourke.com
AA26002399

**BEYER
BLINDER
BELLE**

120 Broadway
20th Floor
New York, NY 10271
212.777.7800
beyerblinderbelle.com

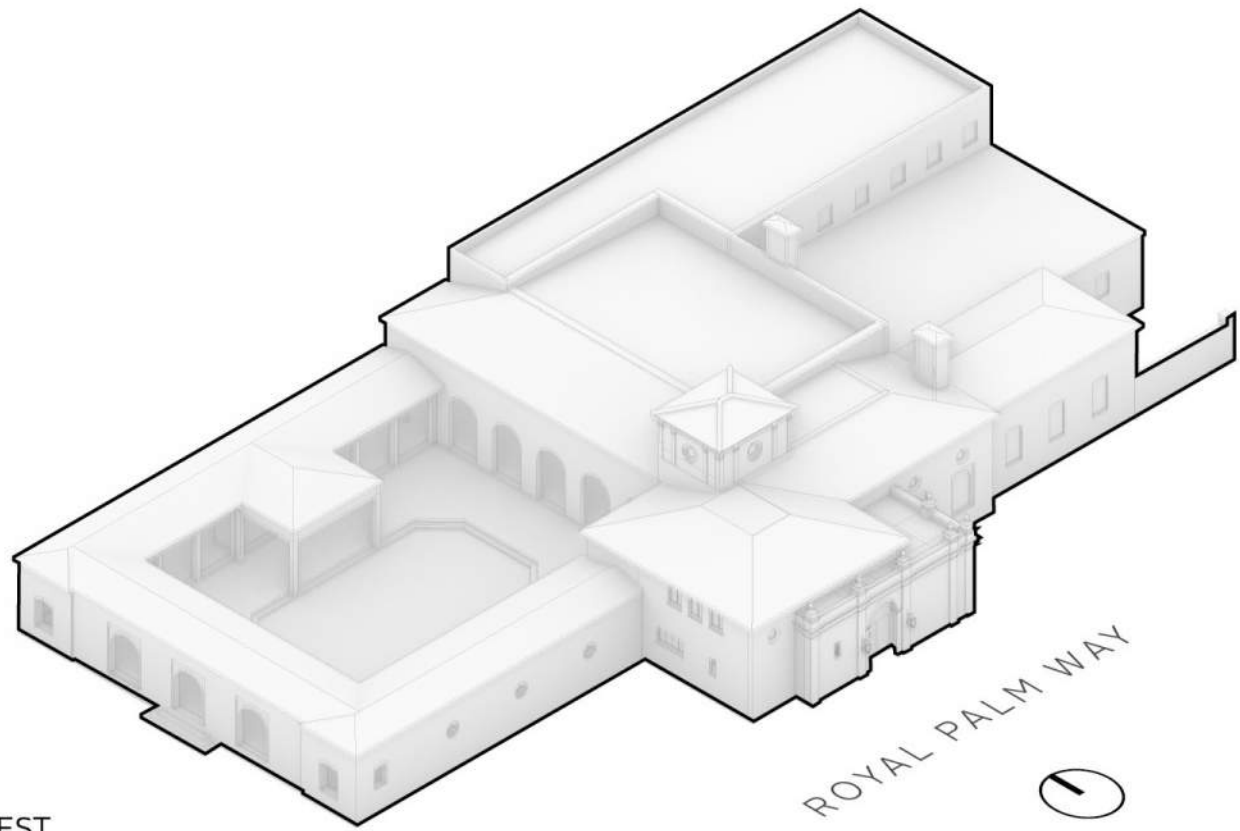

VIEW FROM SOUTHWEST

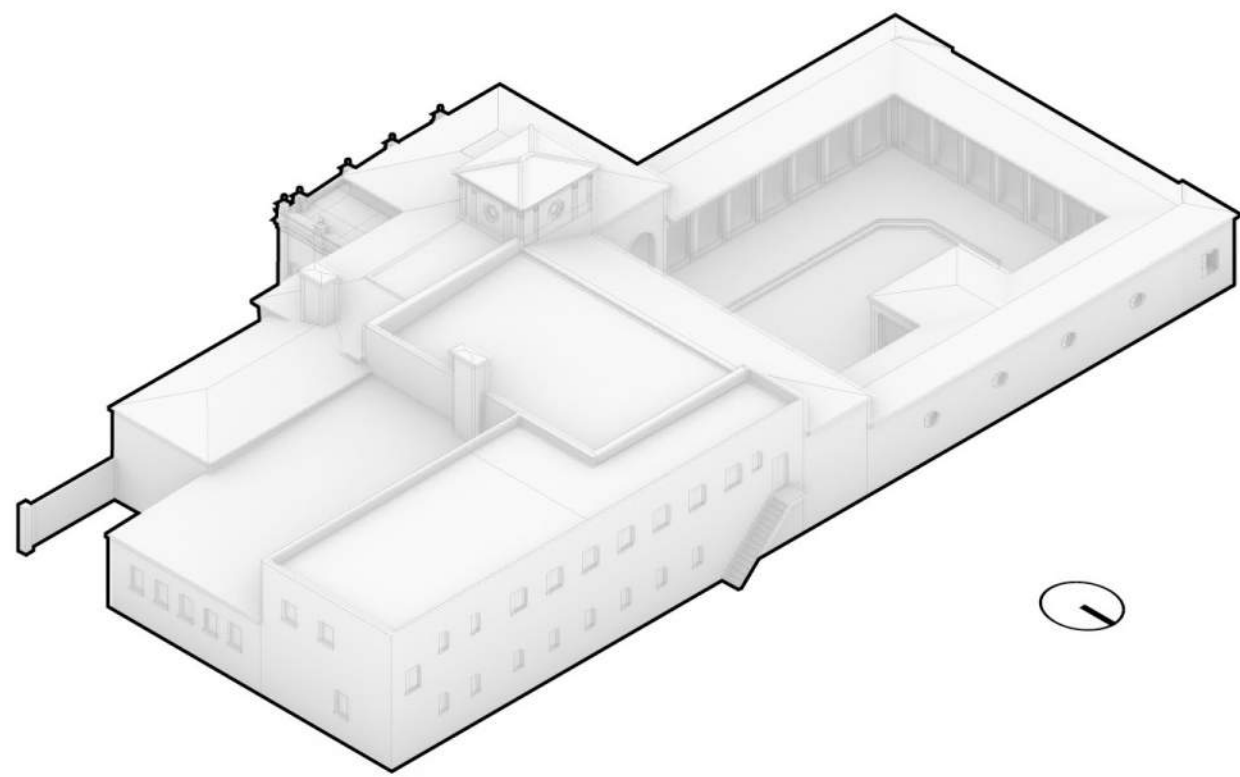

VIEW FROM NORTHEAST

6 AXONOMETRIC DIAGRAMS OF BUILDING IN 1930
B-1.0.0 NTS - DRAWN BY BBB, 2023



3 PHOTO - CENTRAL LOGGIA, LOOKING NORTH, CIRCA 1930
B-1.0.0 NTS - COURTESY HISTORICAL SOCIETY OF PALM BEACH COUNTY




8 PHOTO - AERIAL OF THE SITE FROM SOUTHWEST, CIRCA 1930
B-1.0.0 NTS - COURTESY HISTORICAL SOCIETY OF PALM BEACH COUNTY



5 PHOTO - LOGGIA AND SOUTH CLOISTER FROM PATIO, CIRCA 1930
B-1.0.0 NTS - COURTESY HISTORICAL SOCIETY OF PALM BEACH COUNTY





2 PHOTO - LOUNGE LOOKING NORTH INTO DINING ROOM, CIRCA 1930
B-1.0.0 NTS - COURTESY HISTORICAL SOCIETY OF PALM BEACH COUNTY

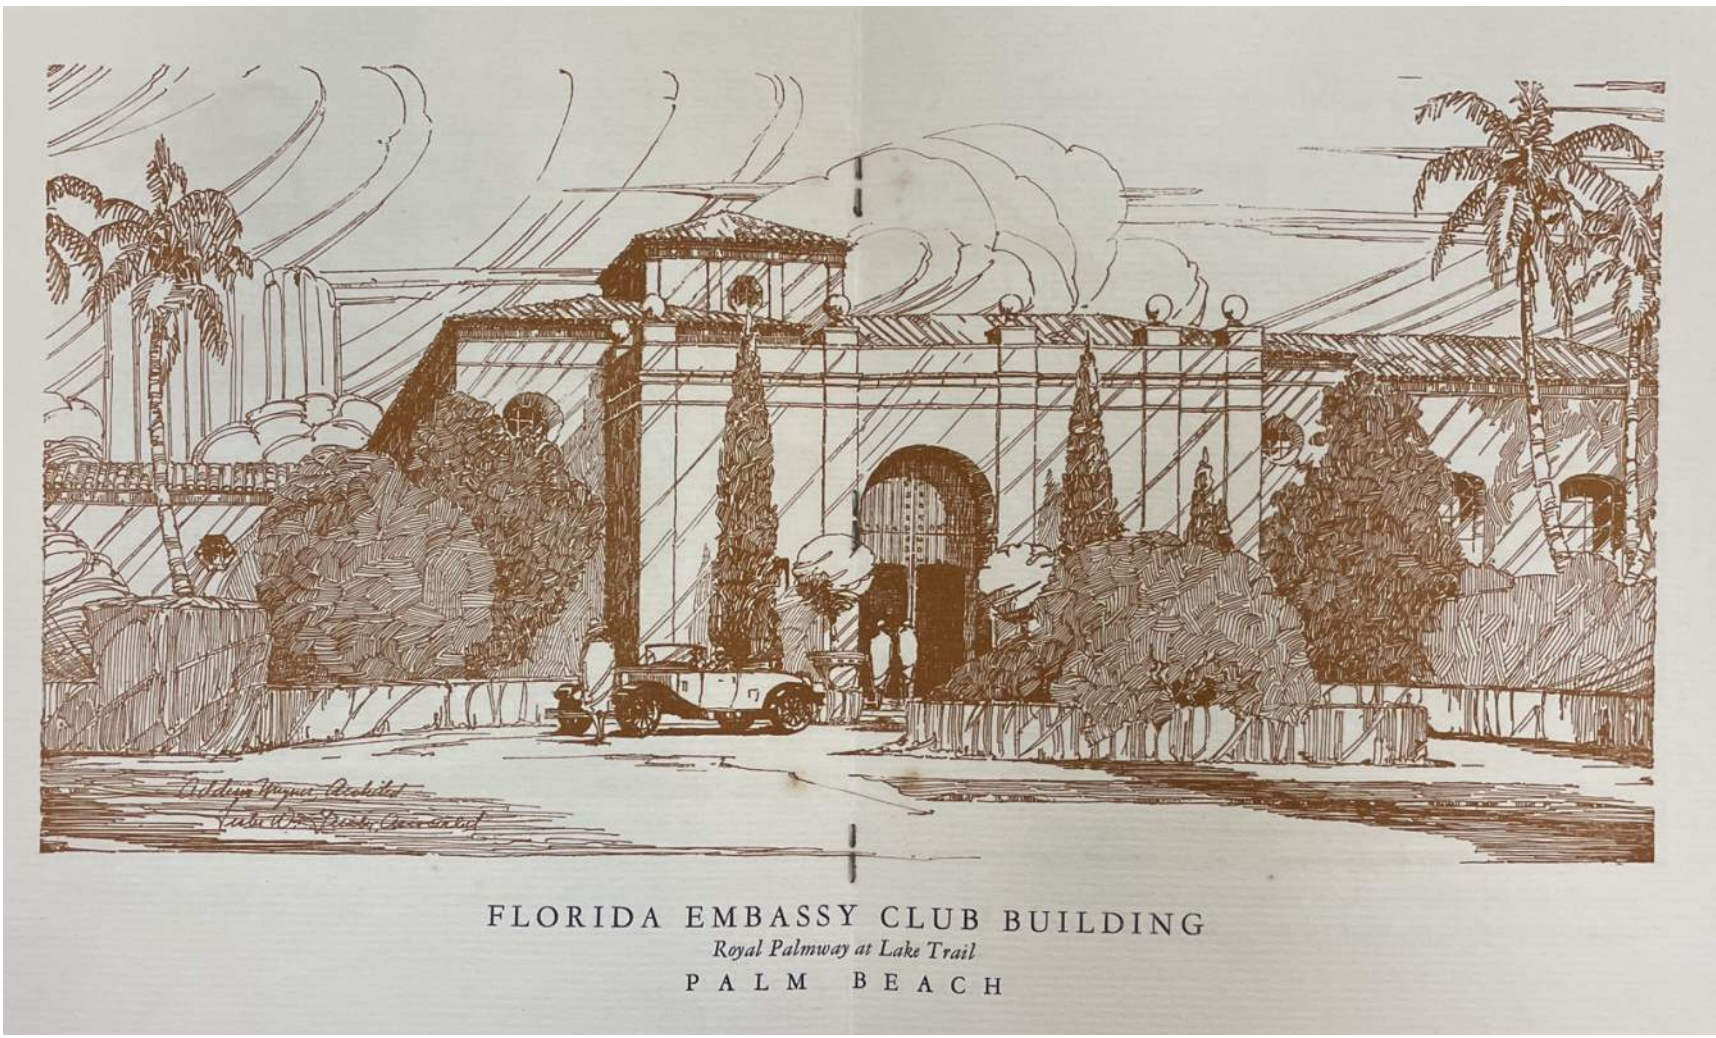


7 FACADE SKETCH, FROM EMBASSY CLUB MEMBERSHIP BROCHURE, 1929
B-1.0.0 NTS - COURTESY HISTORICAL SOCIETY OF PALM BEACH COUNTY




4 PHOTO - SOUTH ELEVATION FROM ROYAL PALM WAY, CIRCA 1930
B-1.0.0 NTS - COURTESY HISTORICAL SOCIETY OF PALM BEACH COUNTY

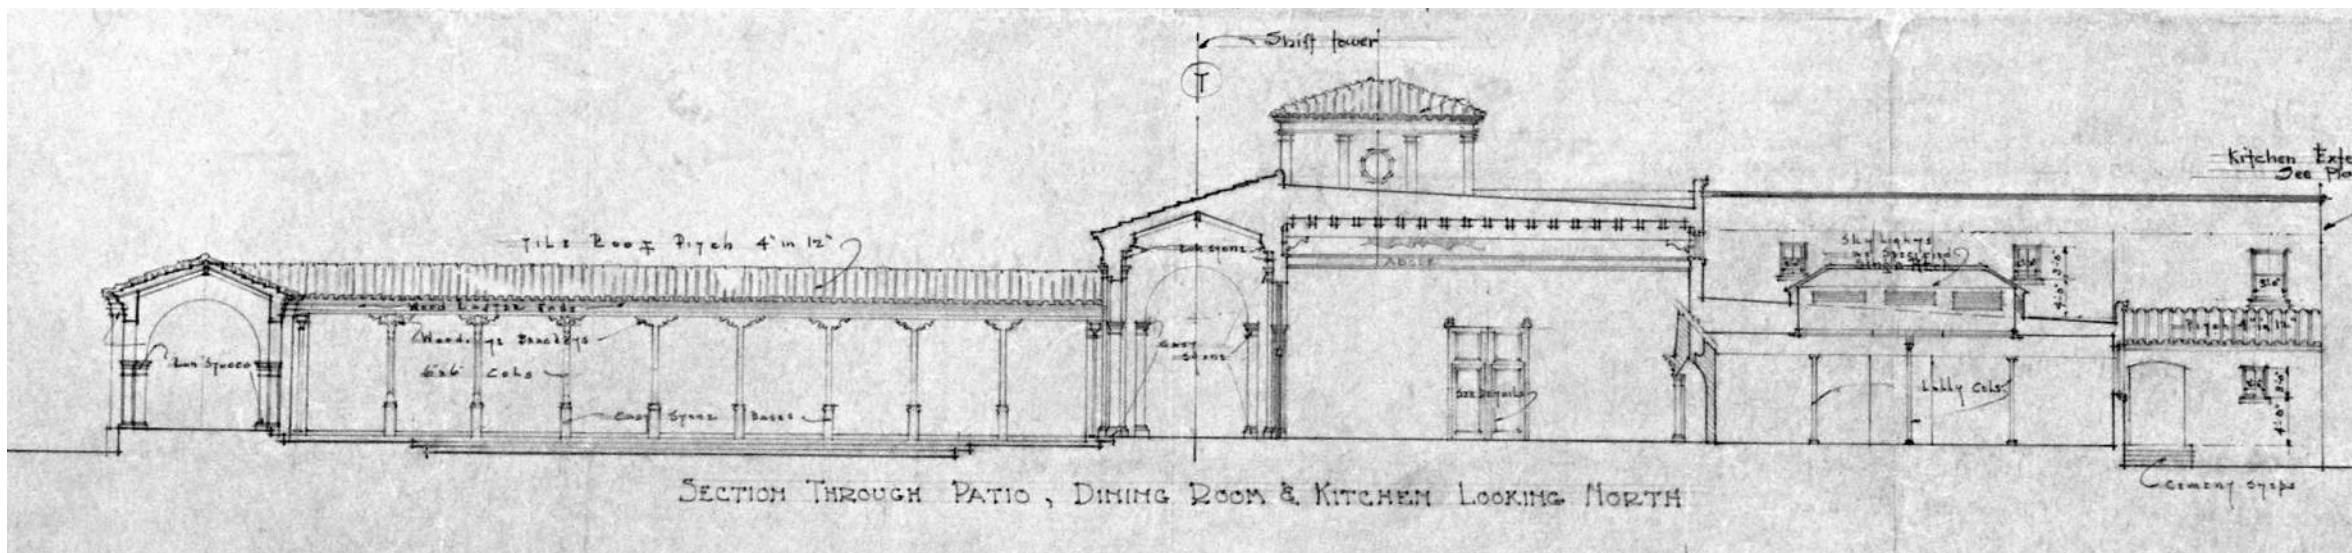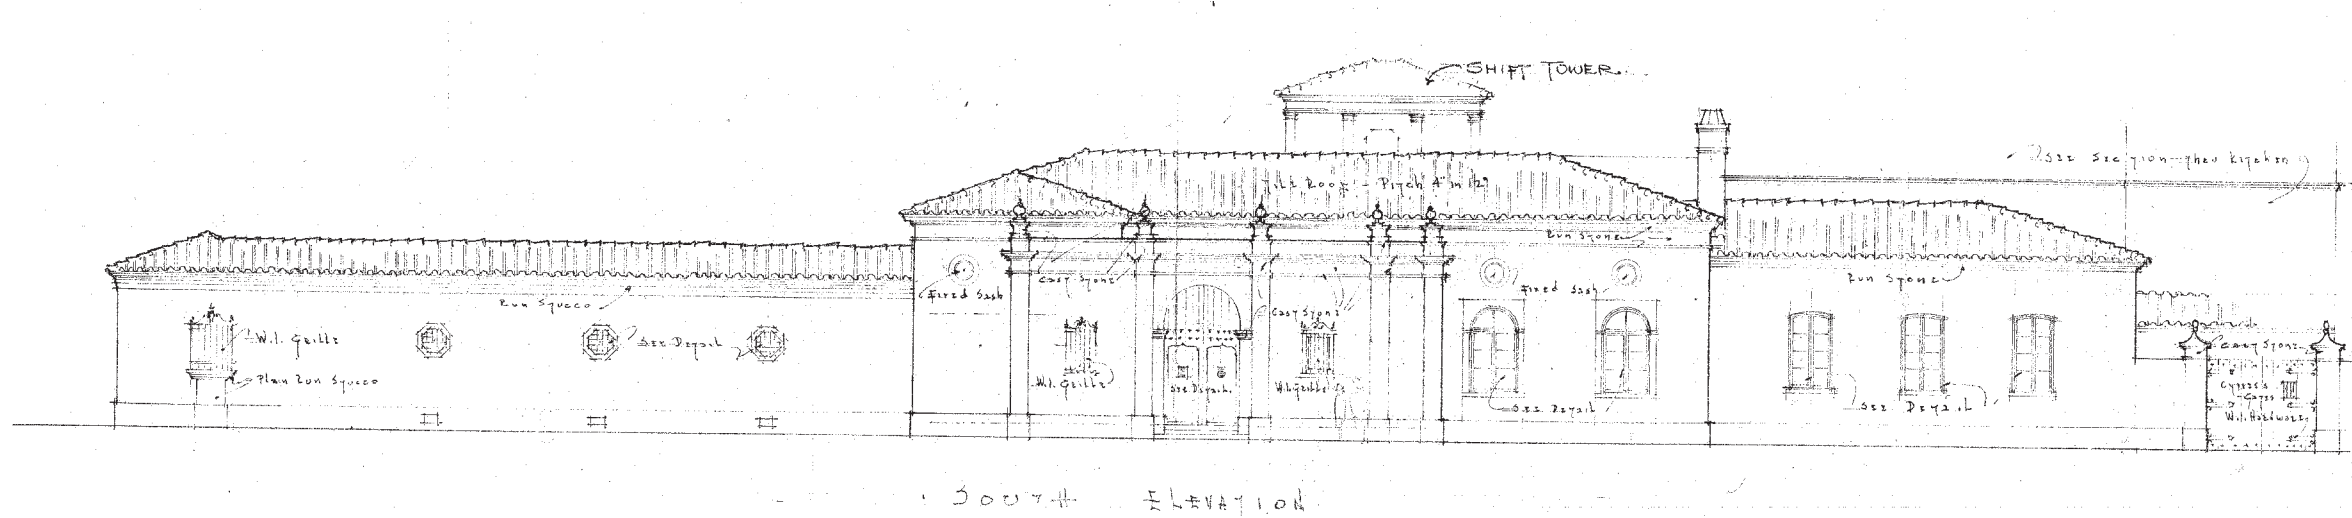

1 SOUTH ELEVATION & E-W SECTION LOOKING NORTH - ADDISON MIZNER, 1925
B-1.0.0 NTS - COURTESY HISTORICAL SOCIETY OF PALM BEACH COUNTY

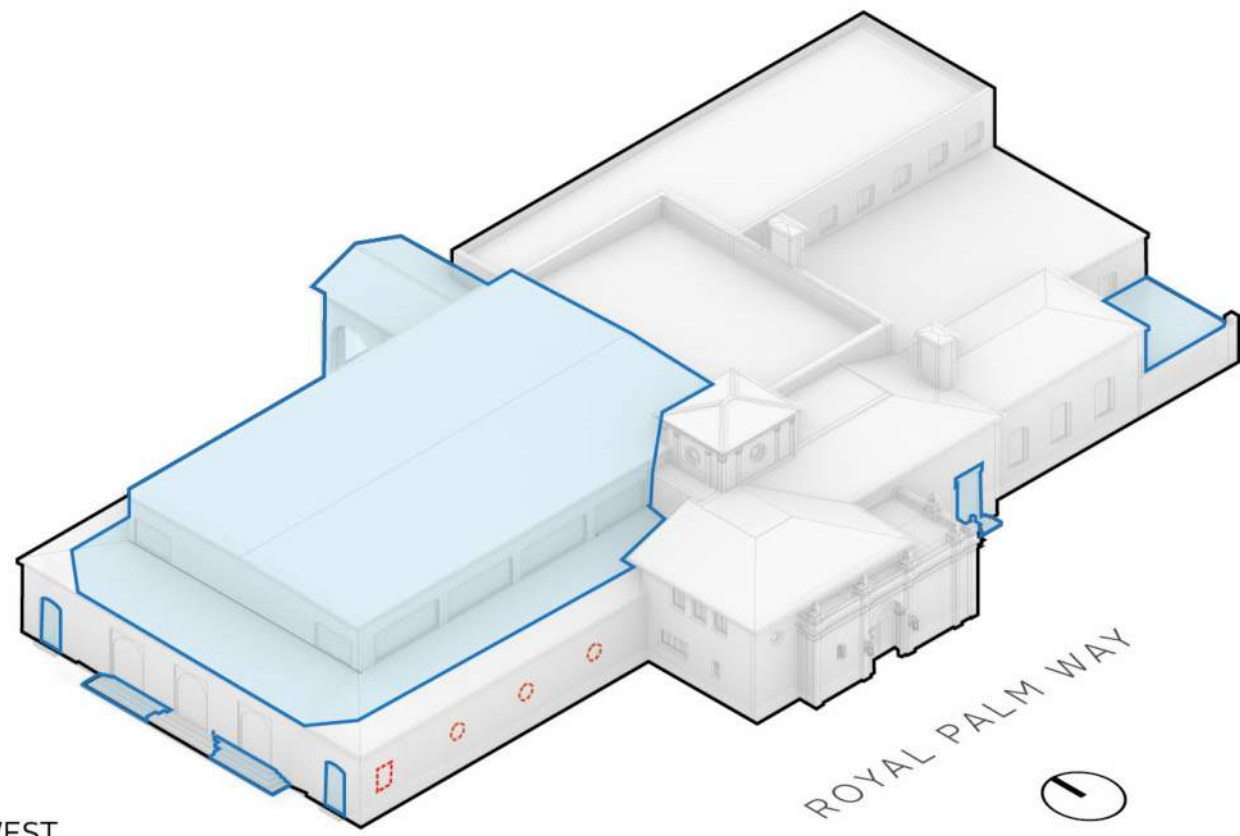

VIEW FROM SOUTHWEST

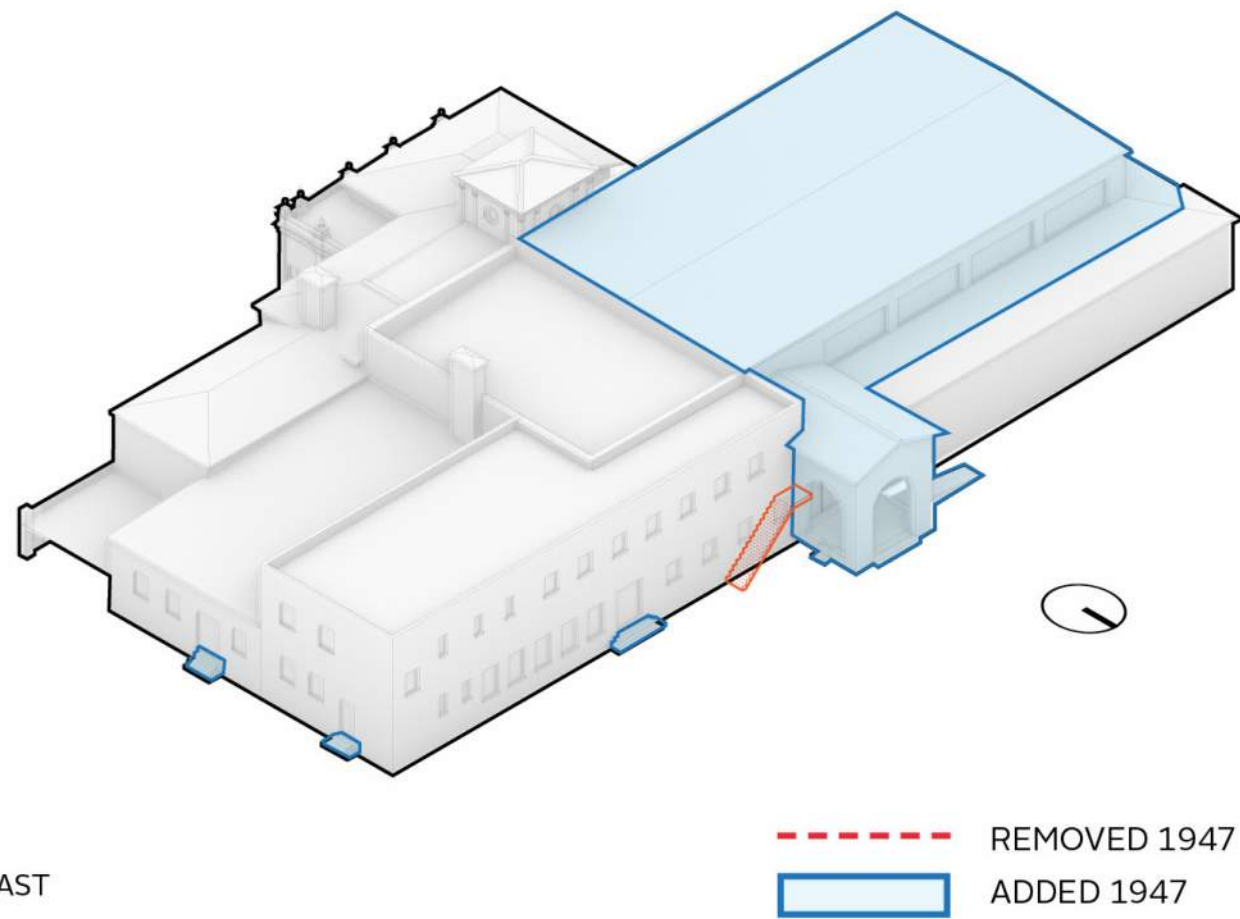

VIEW FROM NORTHEAST

6 AXONOMETRIC DIAGRAMS OF BUILDING IN 1947
B-1.0.1 NTS - DRAWN BY BBB, 2023



3 PHOTO - LOBBY (FORMER LOGGIA), LOOKING SOUTH, CIRCA 1947
B-1.0.1 NTS - COURTESY HISTORICAL SOCIETY OF PALM BEACH COUNTY



8 PHOTO - AUDITORIUM LOOKING WEST TO STAGE, CIRCA 1947
B-1.0.1 NTS - COURTESY HISTORICAL SOCIETY OF PALM BEACH COUNTY



5 PHOTO - AUDITORIUM LOOKING EAST TO FORMER LOGGIA, CIRCA 1947
B-1.0.1 NTS - COURTESY HISTORICAL SOCIETY OF PALM BEACH COUNTY




2 PHOTO - MAIN GALLERY (FORMERLY DINING) LOOKING NORTH, CIRCA 1947
B-1.0.1 NTS - COURTESY HISTORICAL SOCIETY OF PALM BEACH COUNTY



7 FACADE SKETCH, FROM EMBASSY CLUB MEMBERSHIP BROCHURE, 1929
B-1.0.1 NTS - COURTESY HISTORICAL SOCIETY OF PALM BEACH COUNTY




4 PHOTO - SOUTH ELEVATION FROM ROYAL PALM WAY, CIRCA 1947
B-1.0.1 NTS - COURTESY HISTORICAL SOCIETY OF PALM BEACH COUNTY

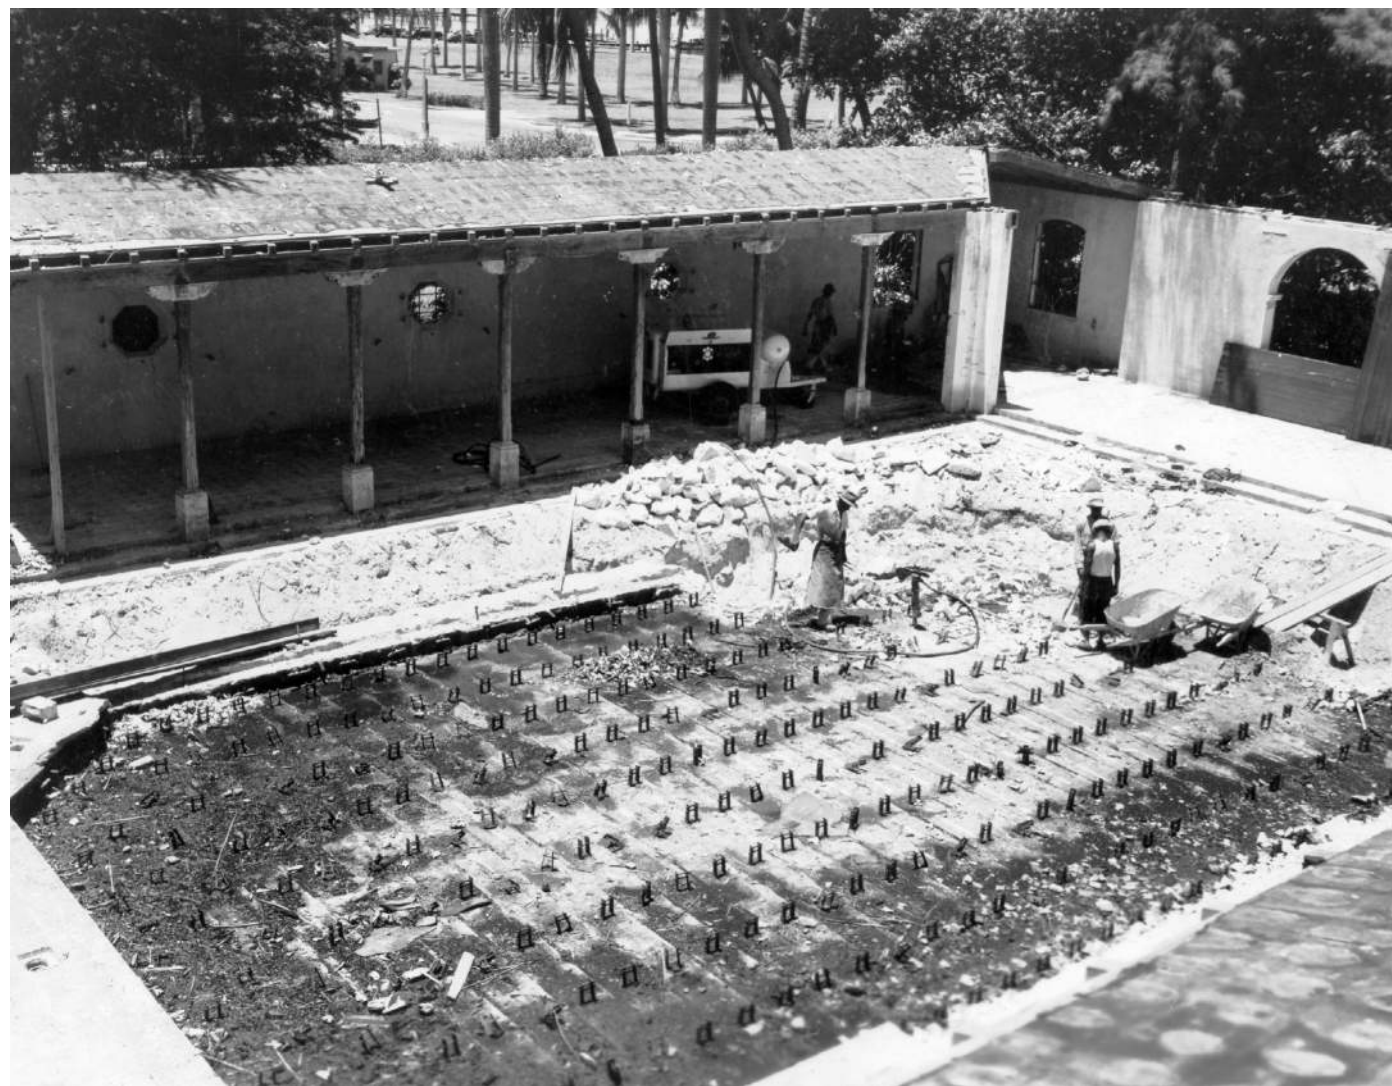


1 PHOTO - 1930 SOUTH CLOISTER AND DANCE FLOOR DURING DEMOLITION, CIRCA 1947
B-1.0.1 NTS - COURTESY HISTORICAL SOCIETY OF PALM BEACH COUNTY

VIEW FROM SOUTHWEST

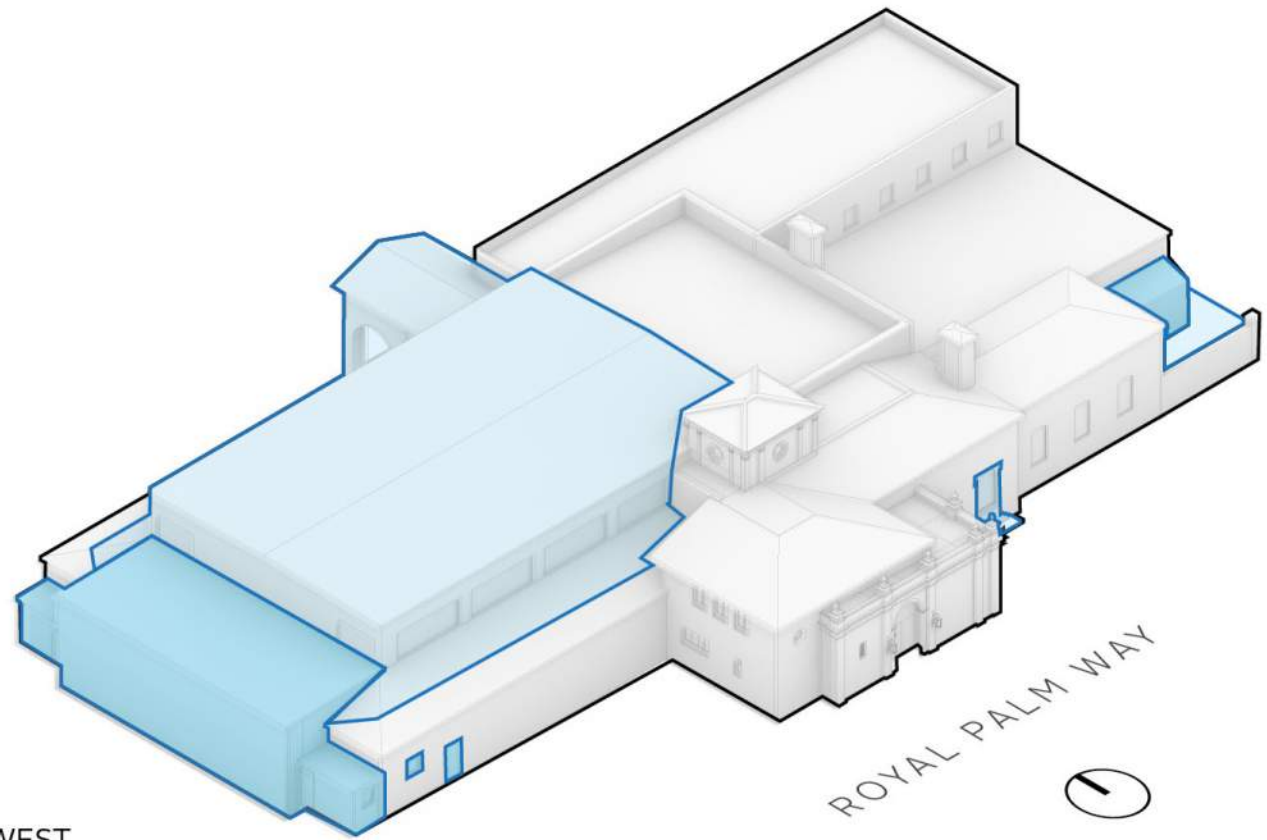

VIEW FROM NORTHEAST

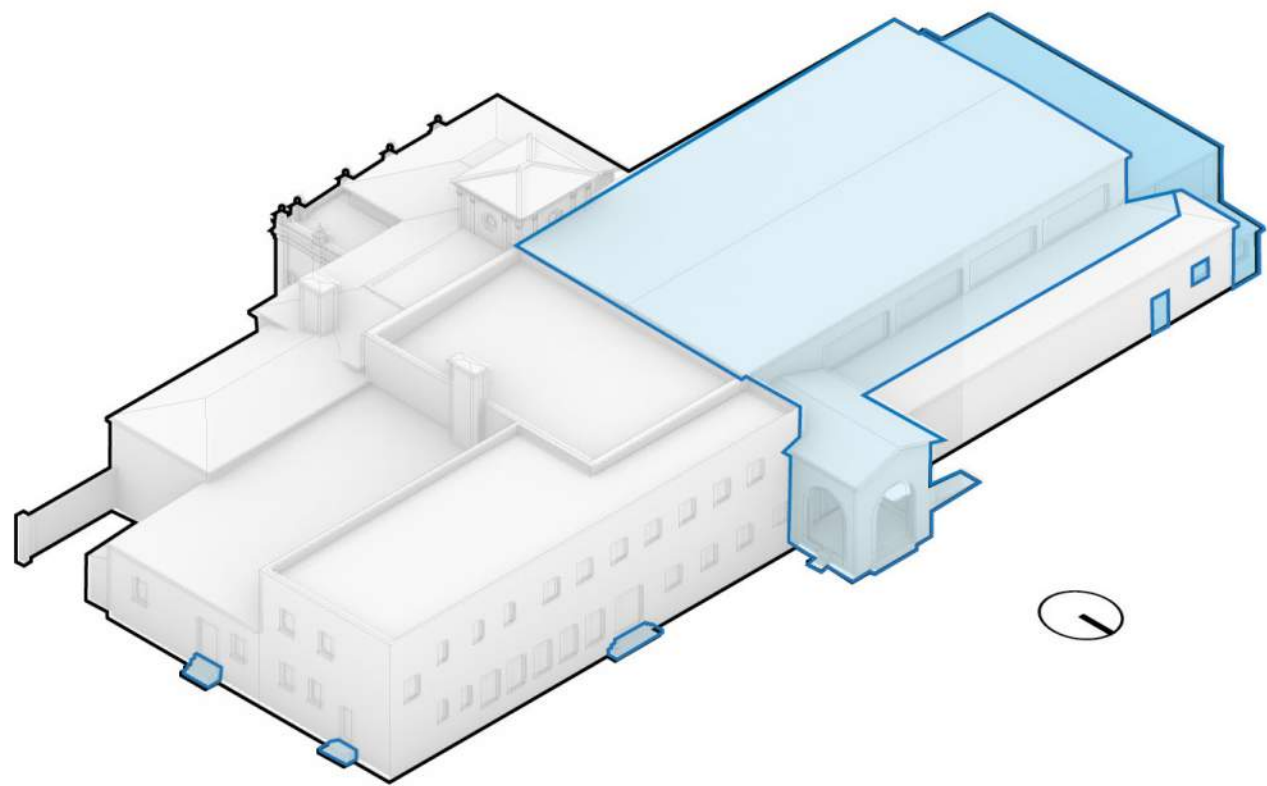

ADDED 1947
ADDED 1957


4 AXONOMETRIC DIAGRAMS OF BUILDING IN 1957

B-1.0.2 NTS - DRAWN BY BBB, 2023




1 PHOTO - EXISTING CONDITIONS, WEST ELEVATION (OCTOBER 2022)

B-1.0.2 NTS

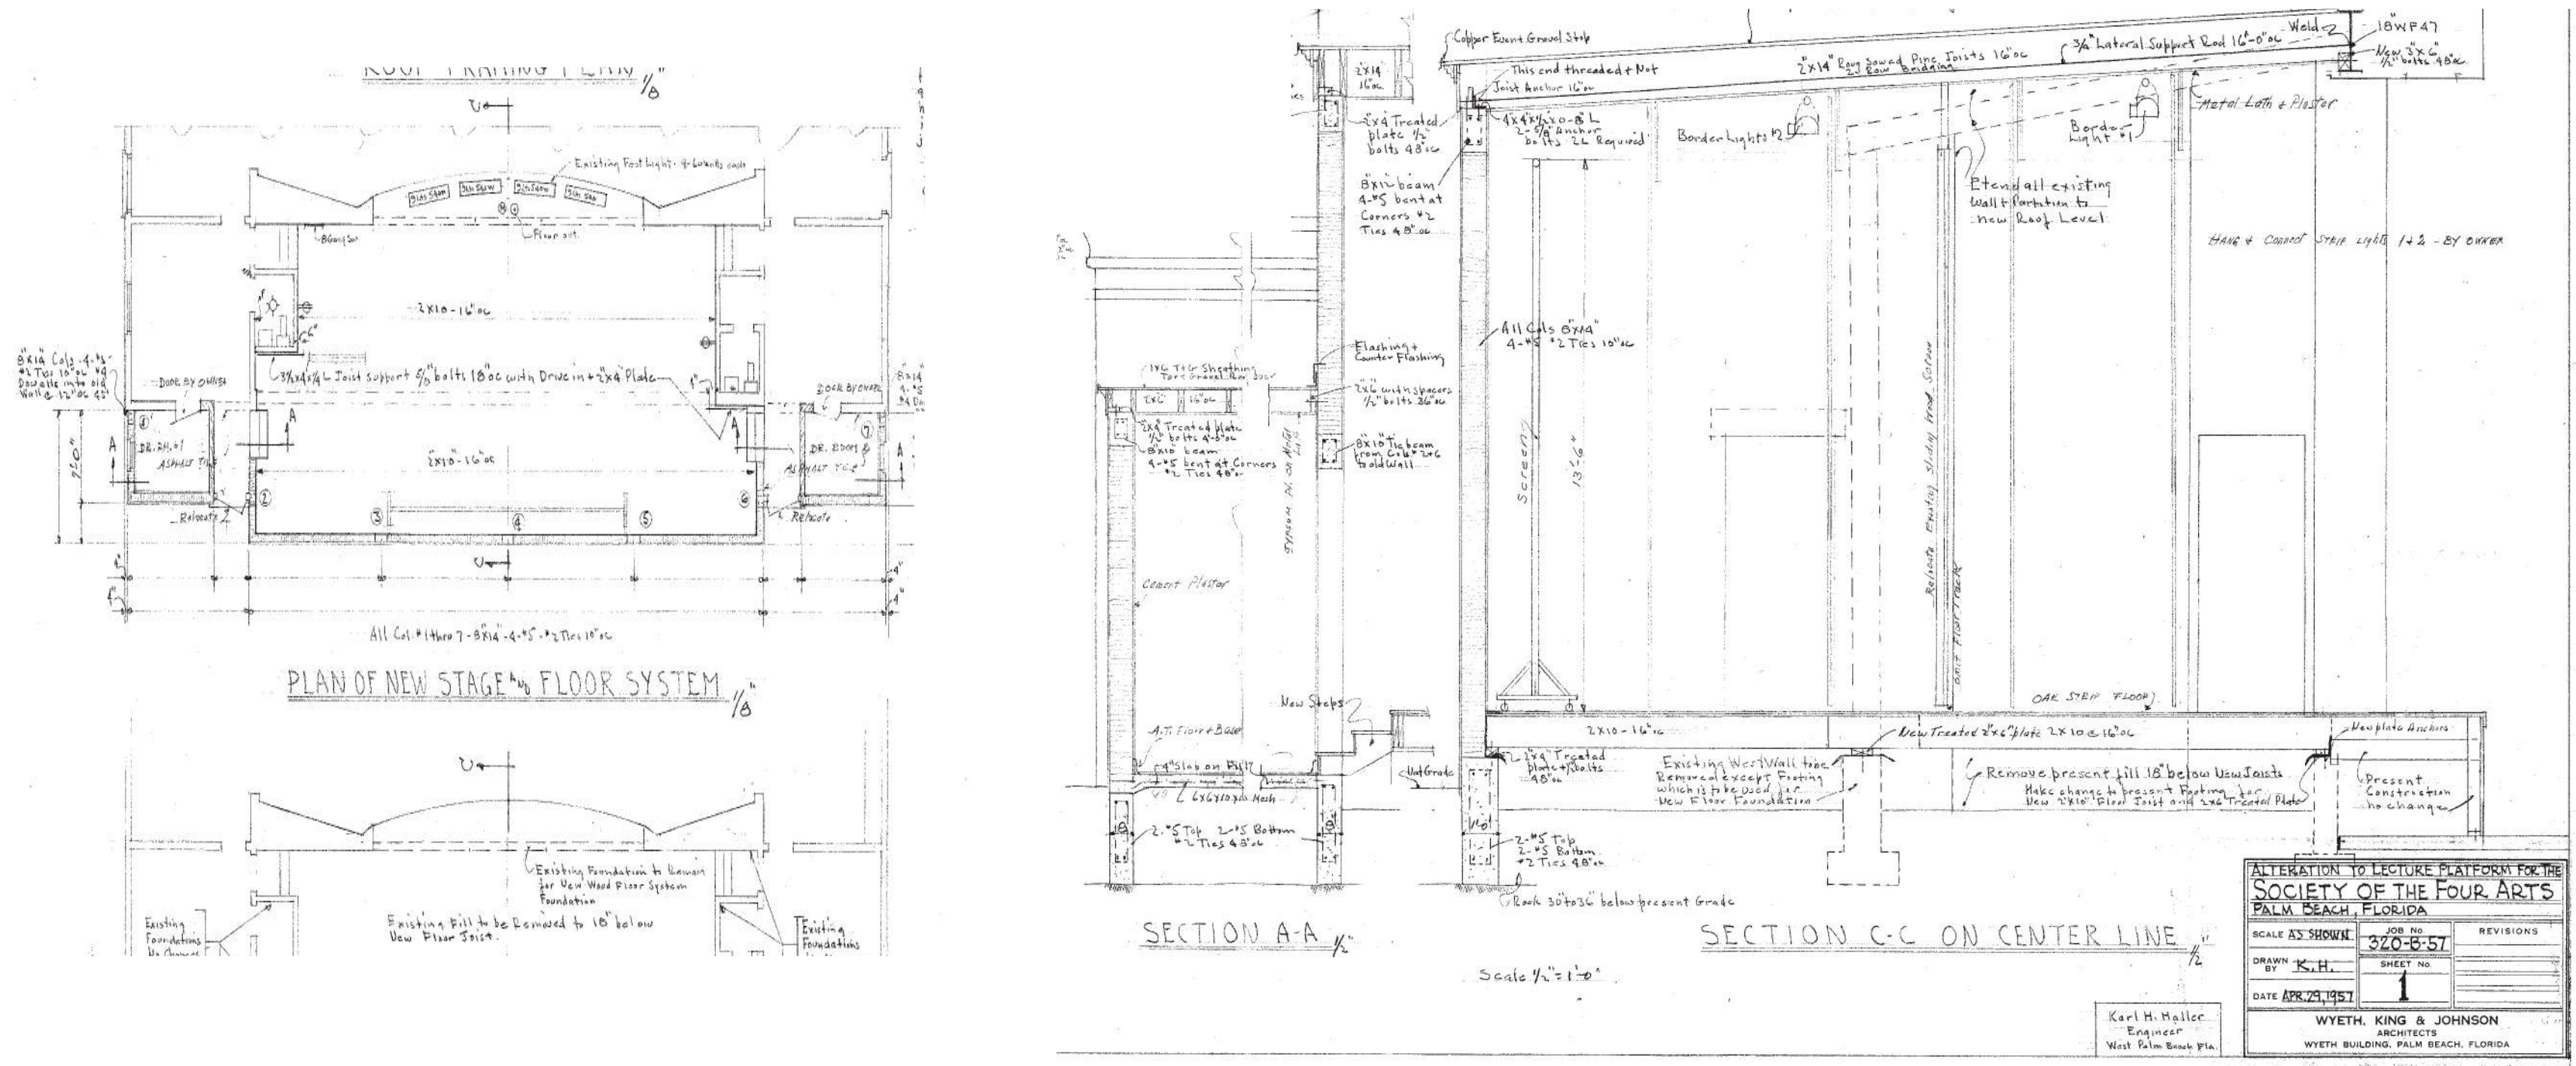


3 DETAILS FOR BACKSTAGE EXPANSION AS CONSTRUCTED - WYETH, KING & JOHNSON, 1957

B-1.0.2 SCALE IS 50% OF NOTED HISTORIC SCALE ON DRAWING - COURTESY THE PRESERVATION FOUNDATION OF PALM BEACH

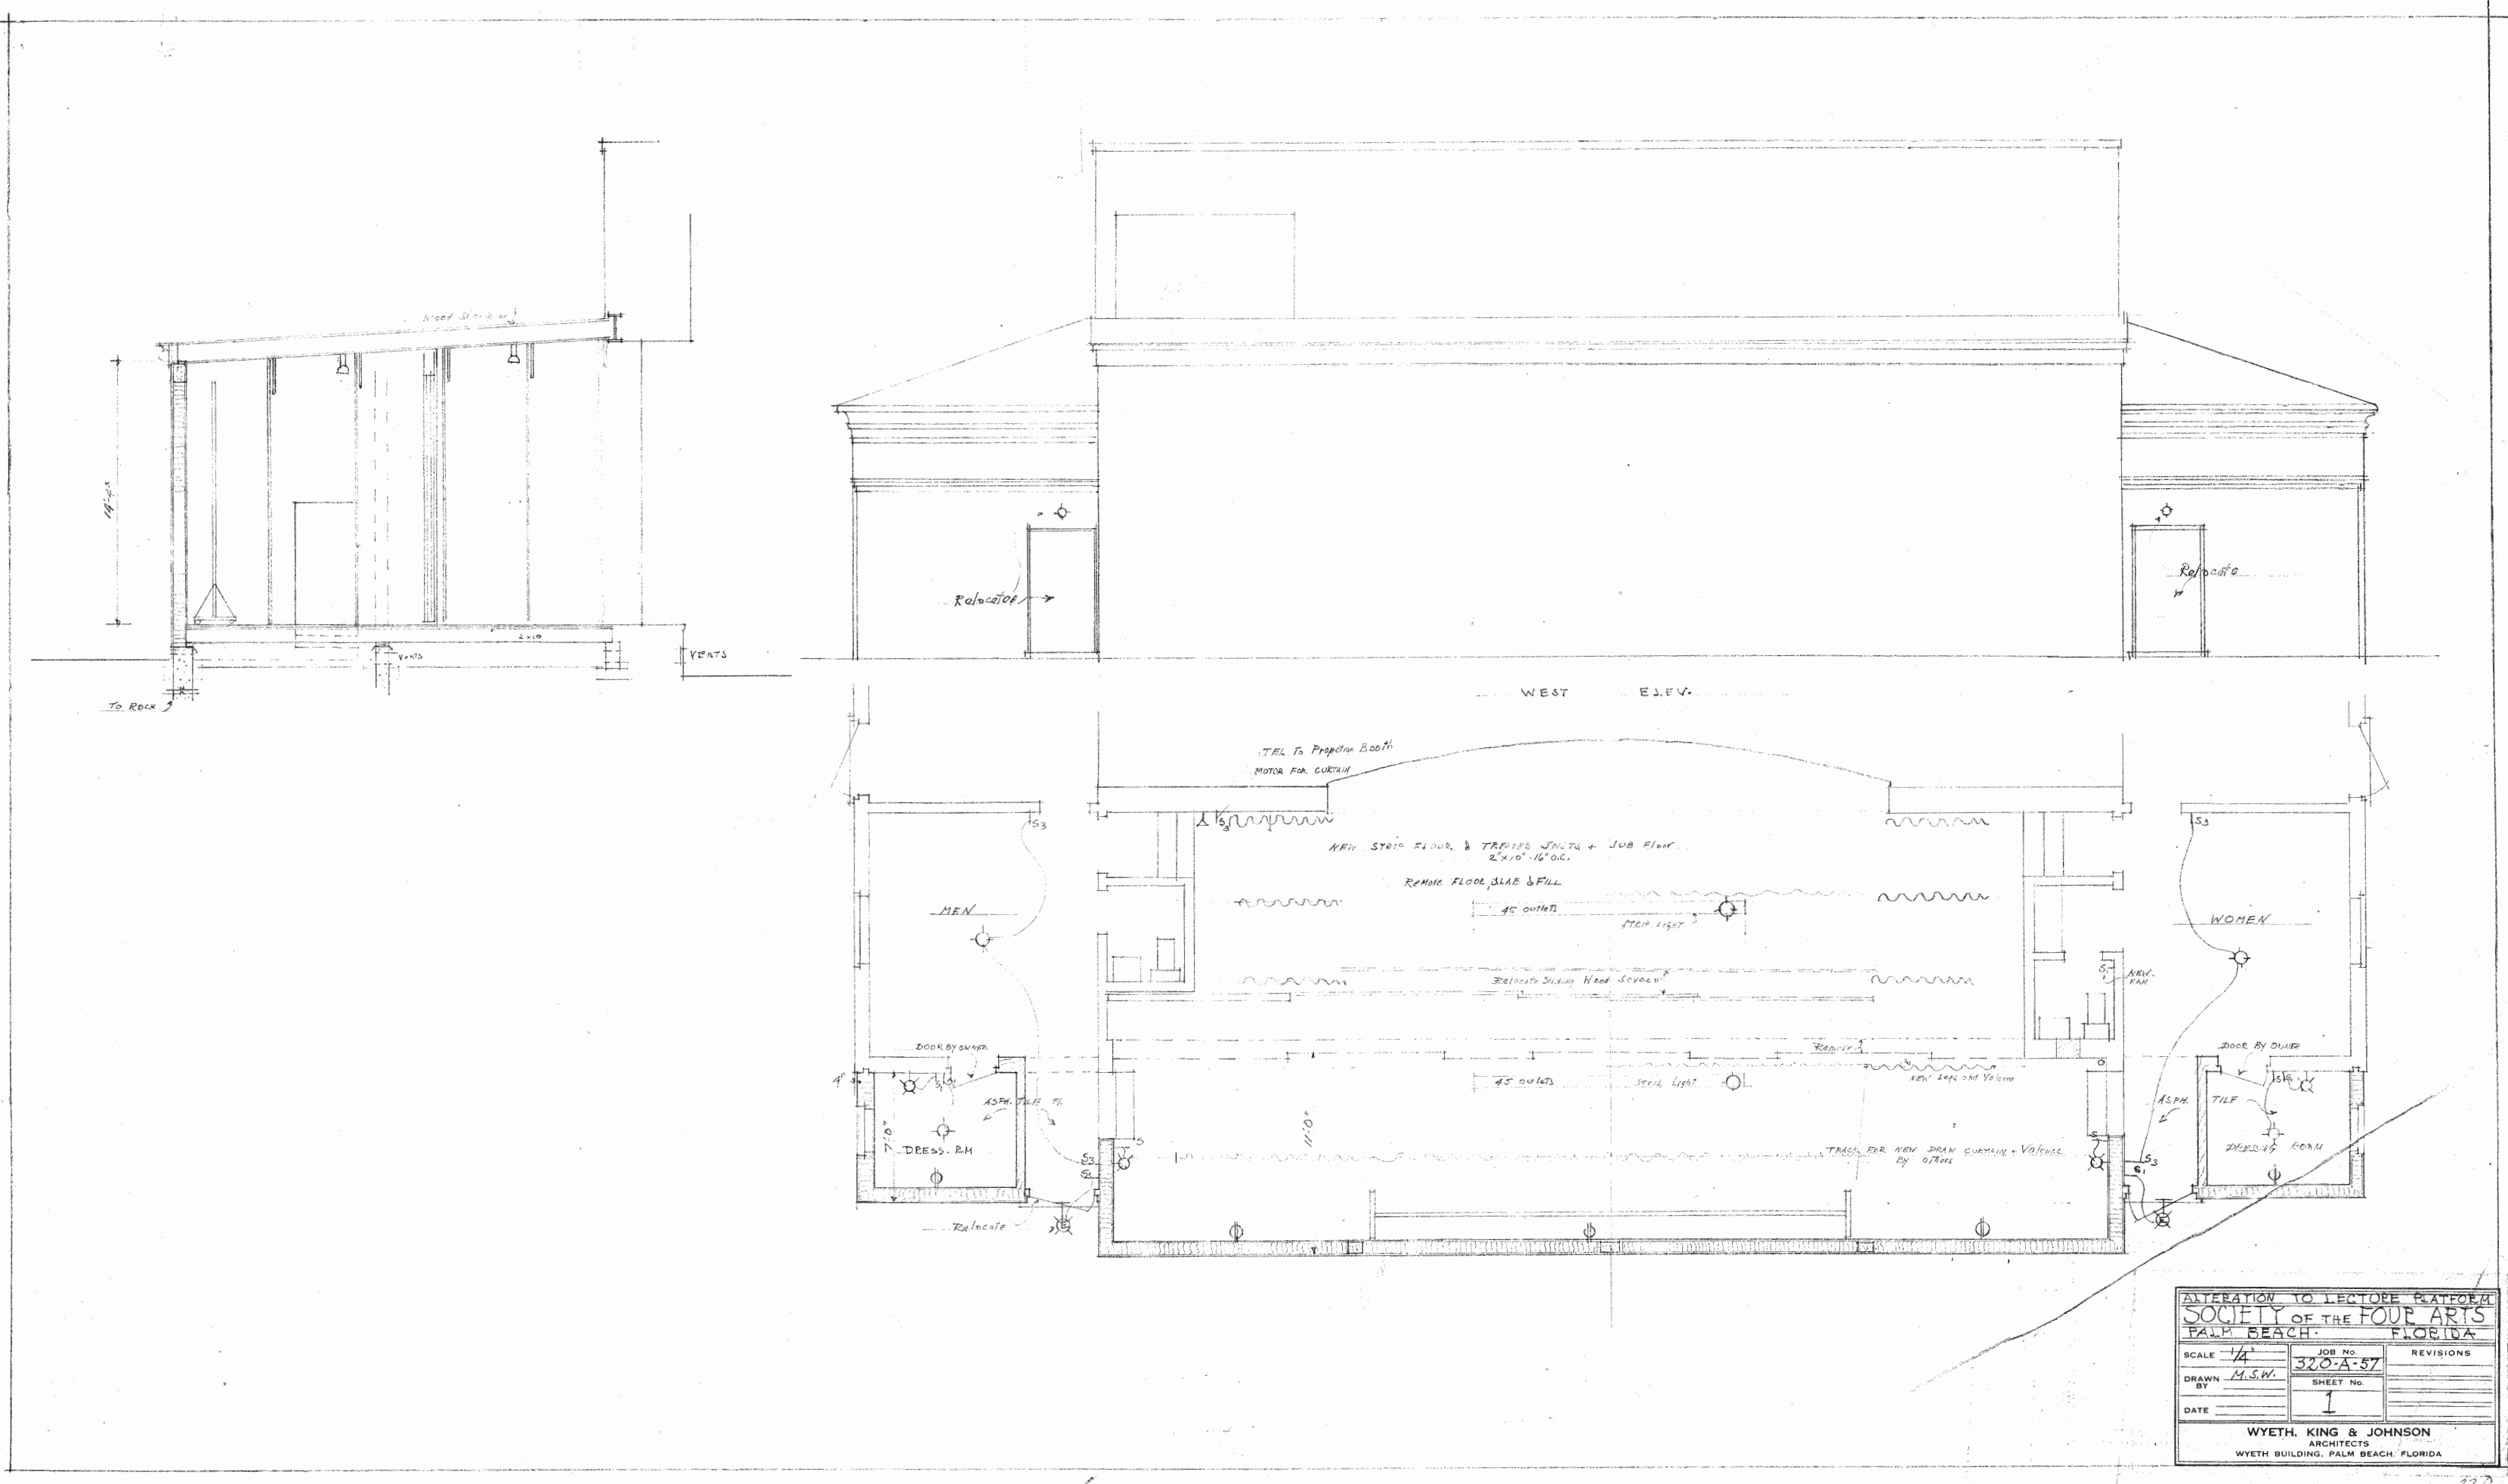


1 INITIAL BACKSTAGE EXPANSION STUDY - WYETH, KING & JOHNSON, 1957

B-1.0.2 SCALE IS 50% OF NOTED HISTORIC SCALE ON DRAWING - COURTESY THE PRESERVATION FOUNDATION OF PALM BEACH

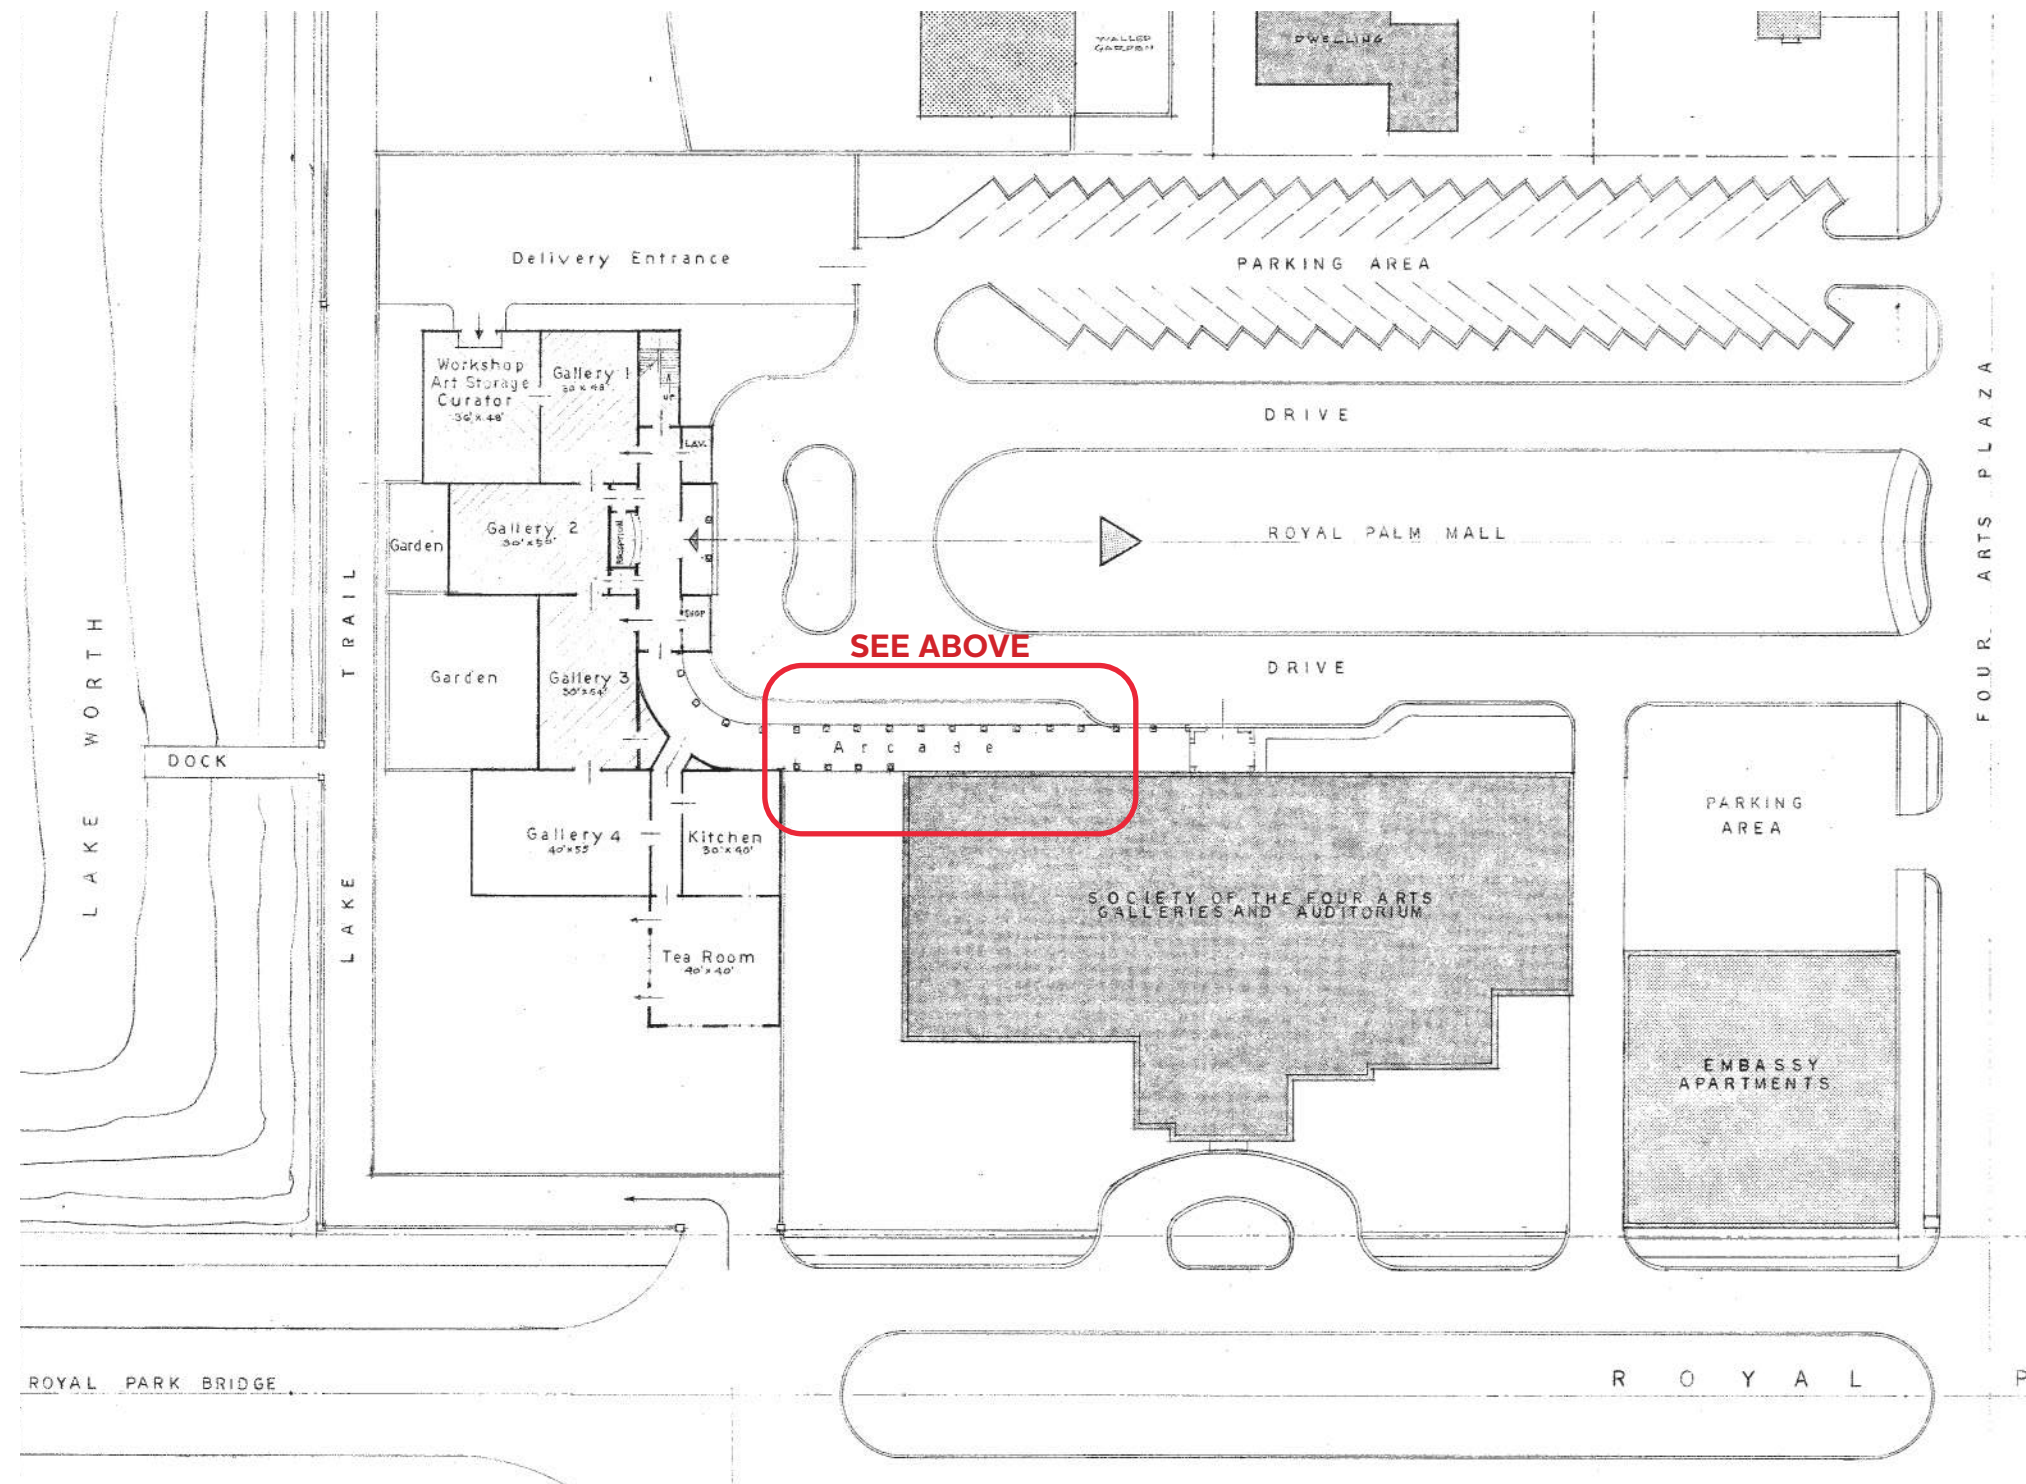


2 UNBUILT SITE PLAN, STUDY FOR NEW LAKESIDE GALLERY BUILDING - JOHN VOLK, 1977
B-1.1.0 SCALE 1" = 60'-0", COURTESY THE PRESERVATION FOUNDATION OF PALM BEACH

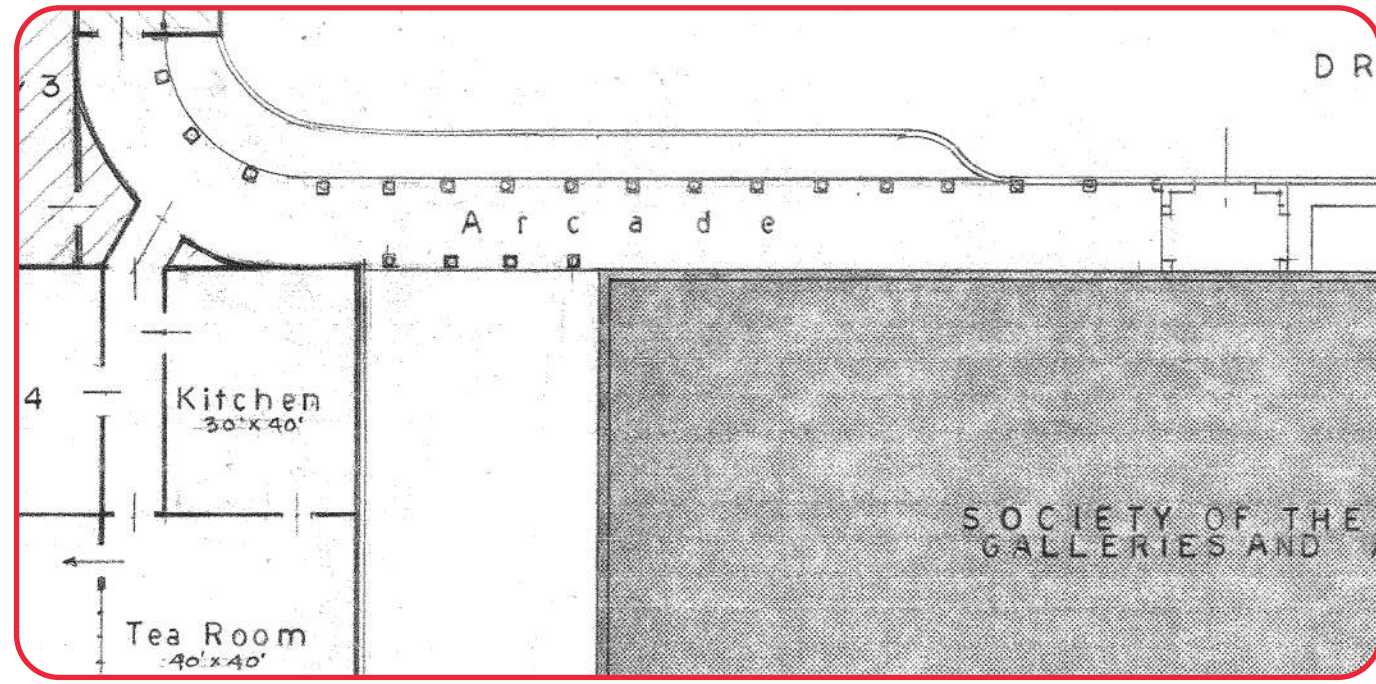


4 ENLARGED PART PLAN, ARCADE CONNECTING TO 1947 PORTICO
B-1.1.0 NTS - DRAWN BY BBB, 2023


1 AXONOMETRIC DIAGRAM - VOLK & WYETH PROPOSAL
B-1.1.0 NTS - DRAWN BY BBB, 2023

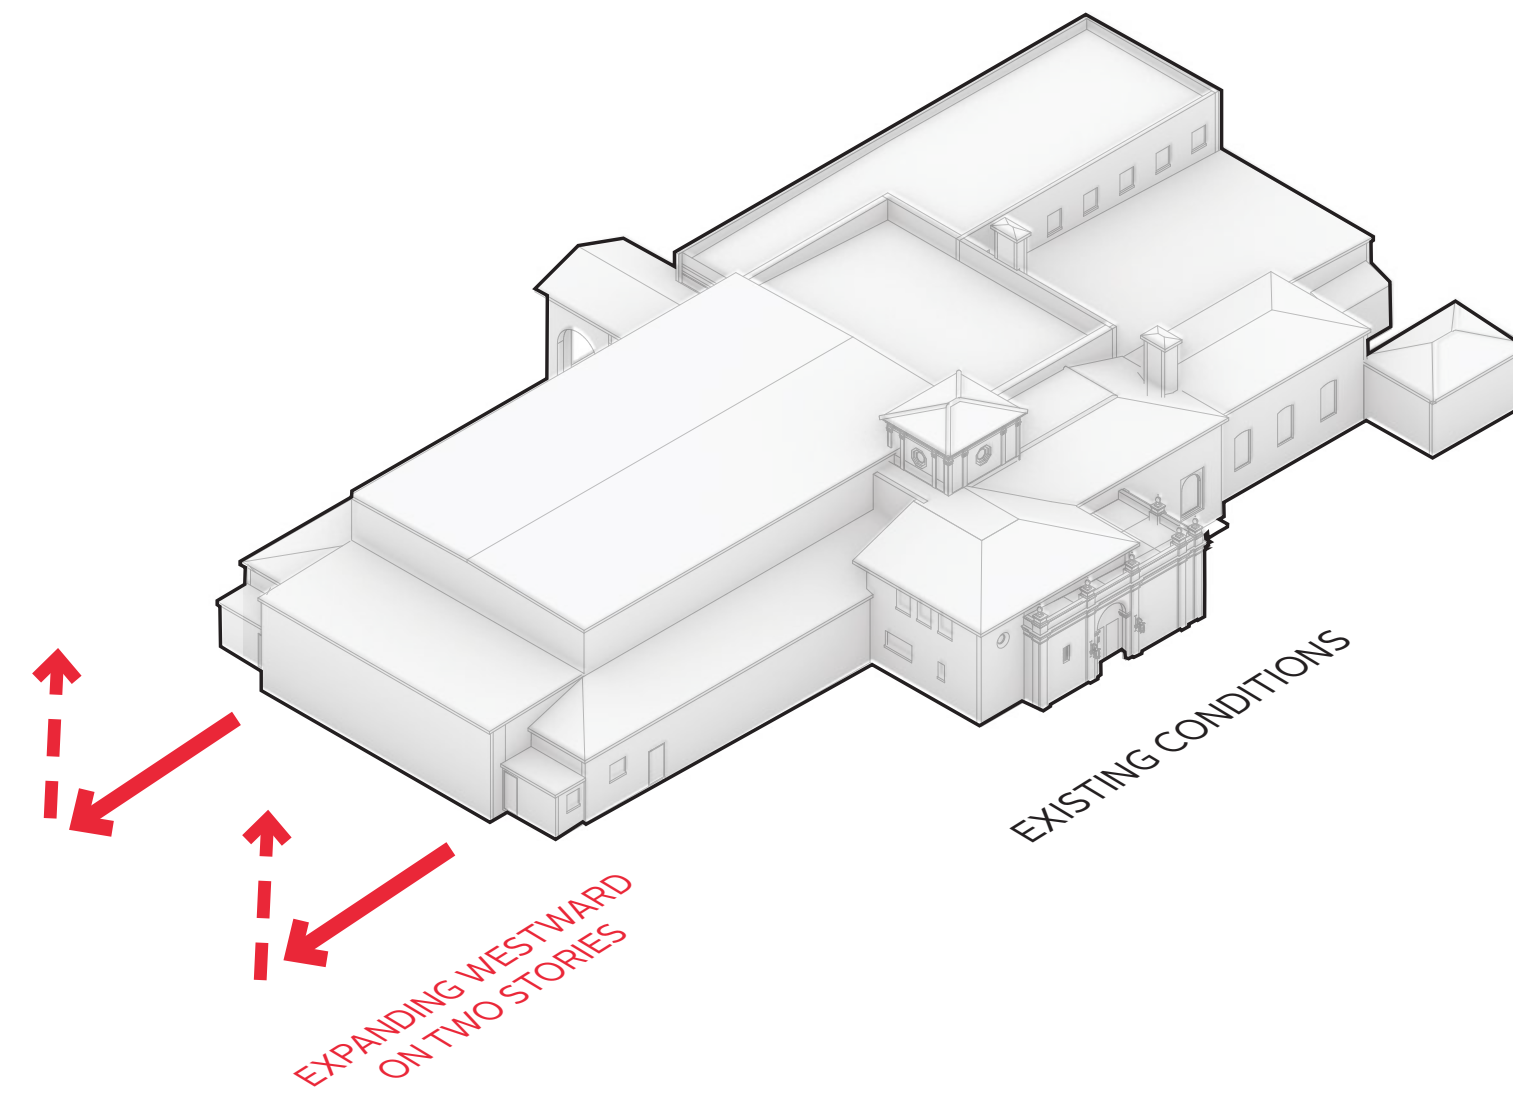

3 UNBUILT PROPOSAL FOR BACKSTAGE EXPANSION - WYETH, KING & JOHNSON, WITH JOHN VOLK, UNDATED
B-1.1.0 3/32" = 1'-0" (75% OF HISTORIC LISTED SCALE) - COURTESY THE PRESERVATION FOUNDATION OF PALM BEACH

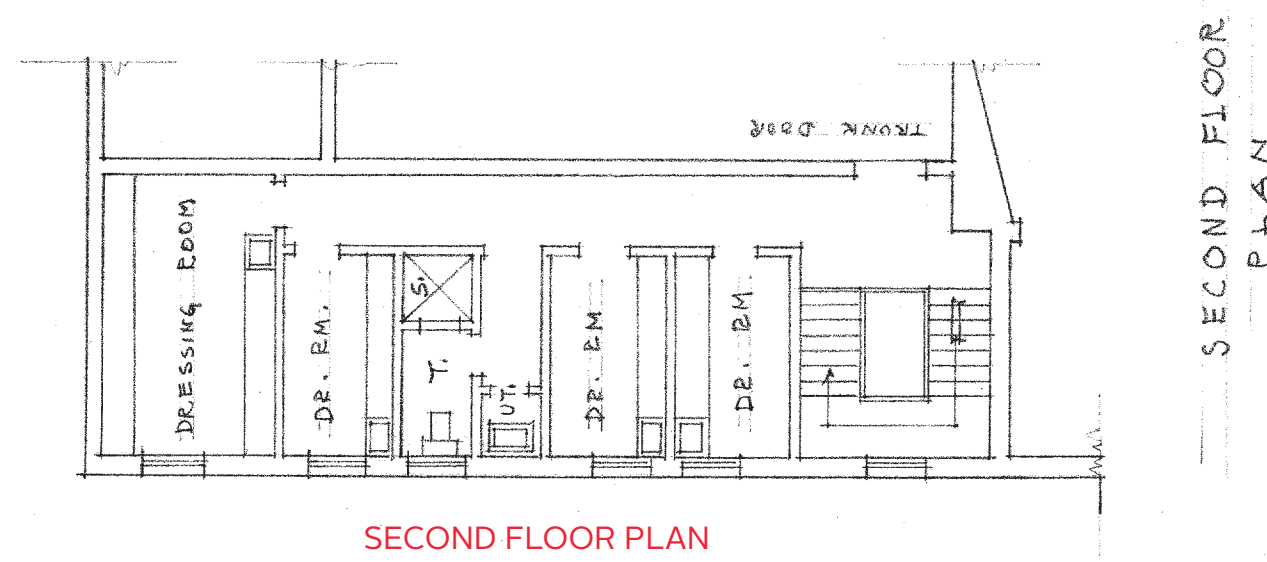


SECOND FLOOR PLAN

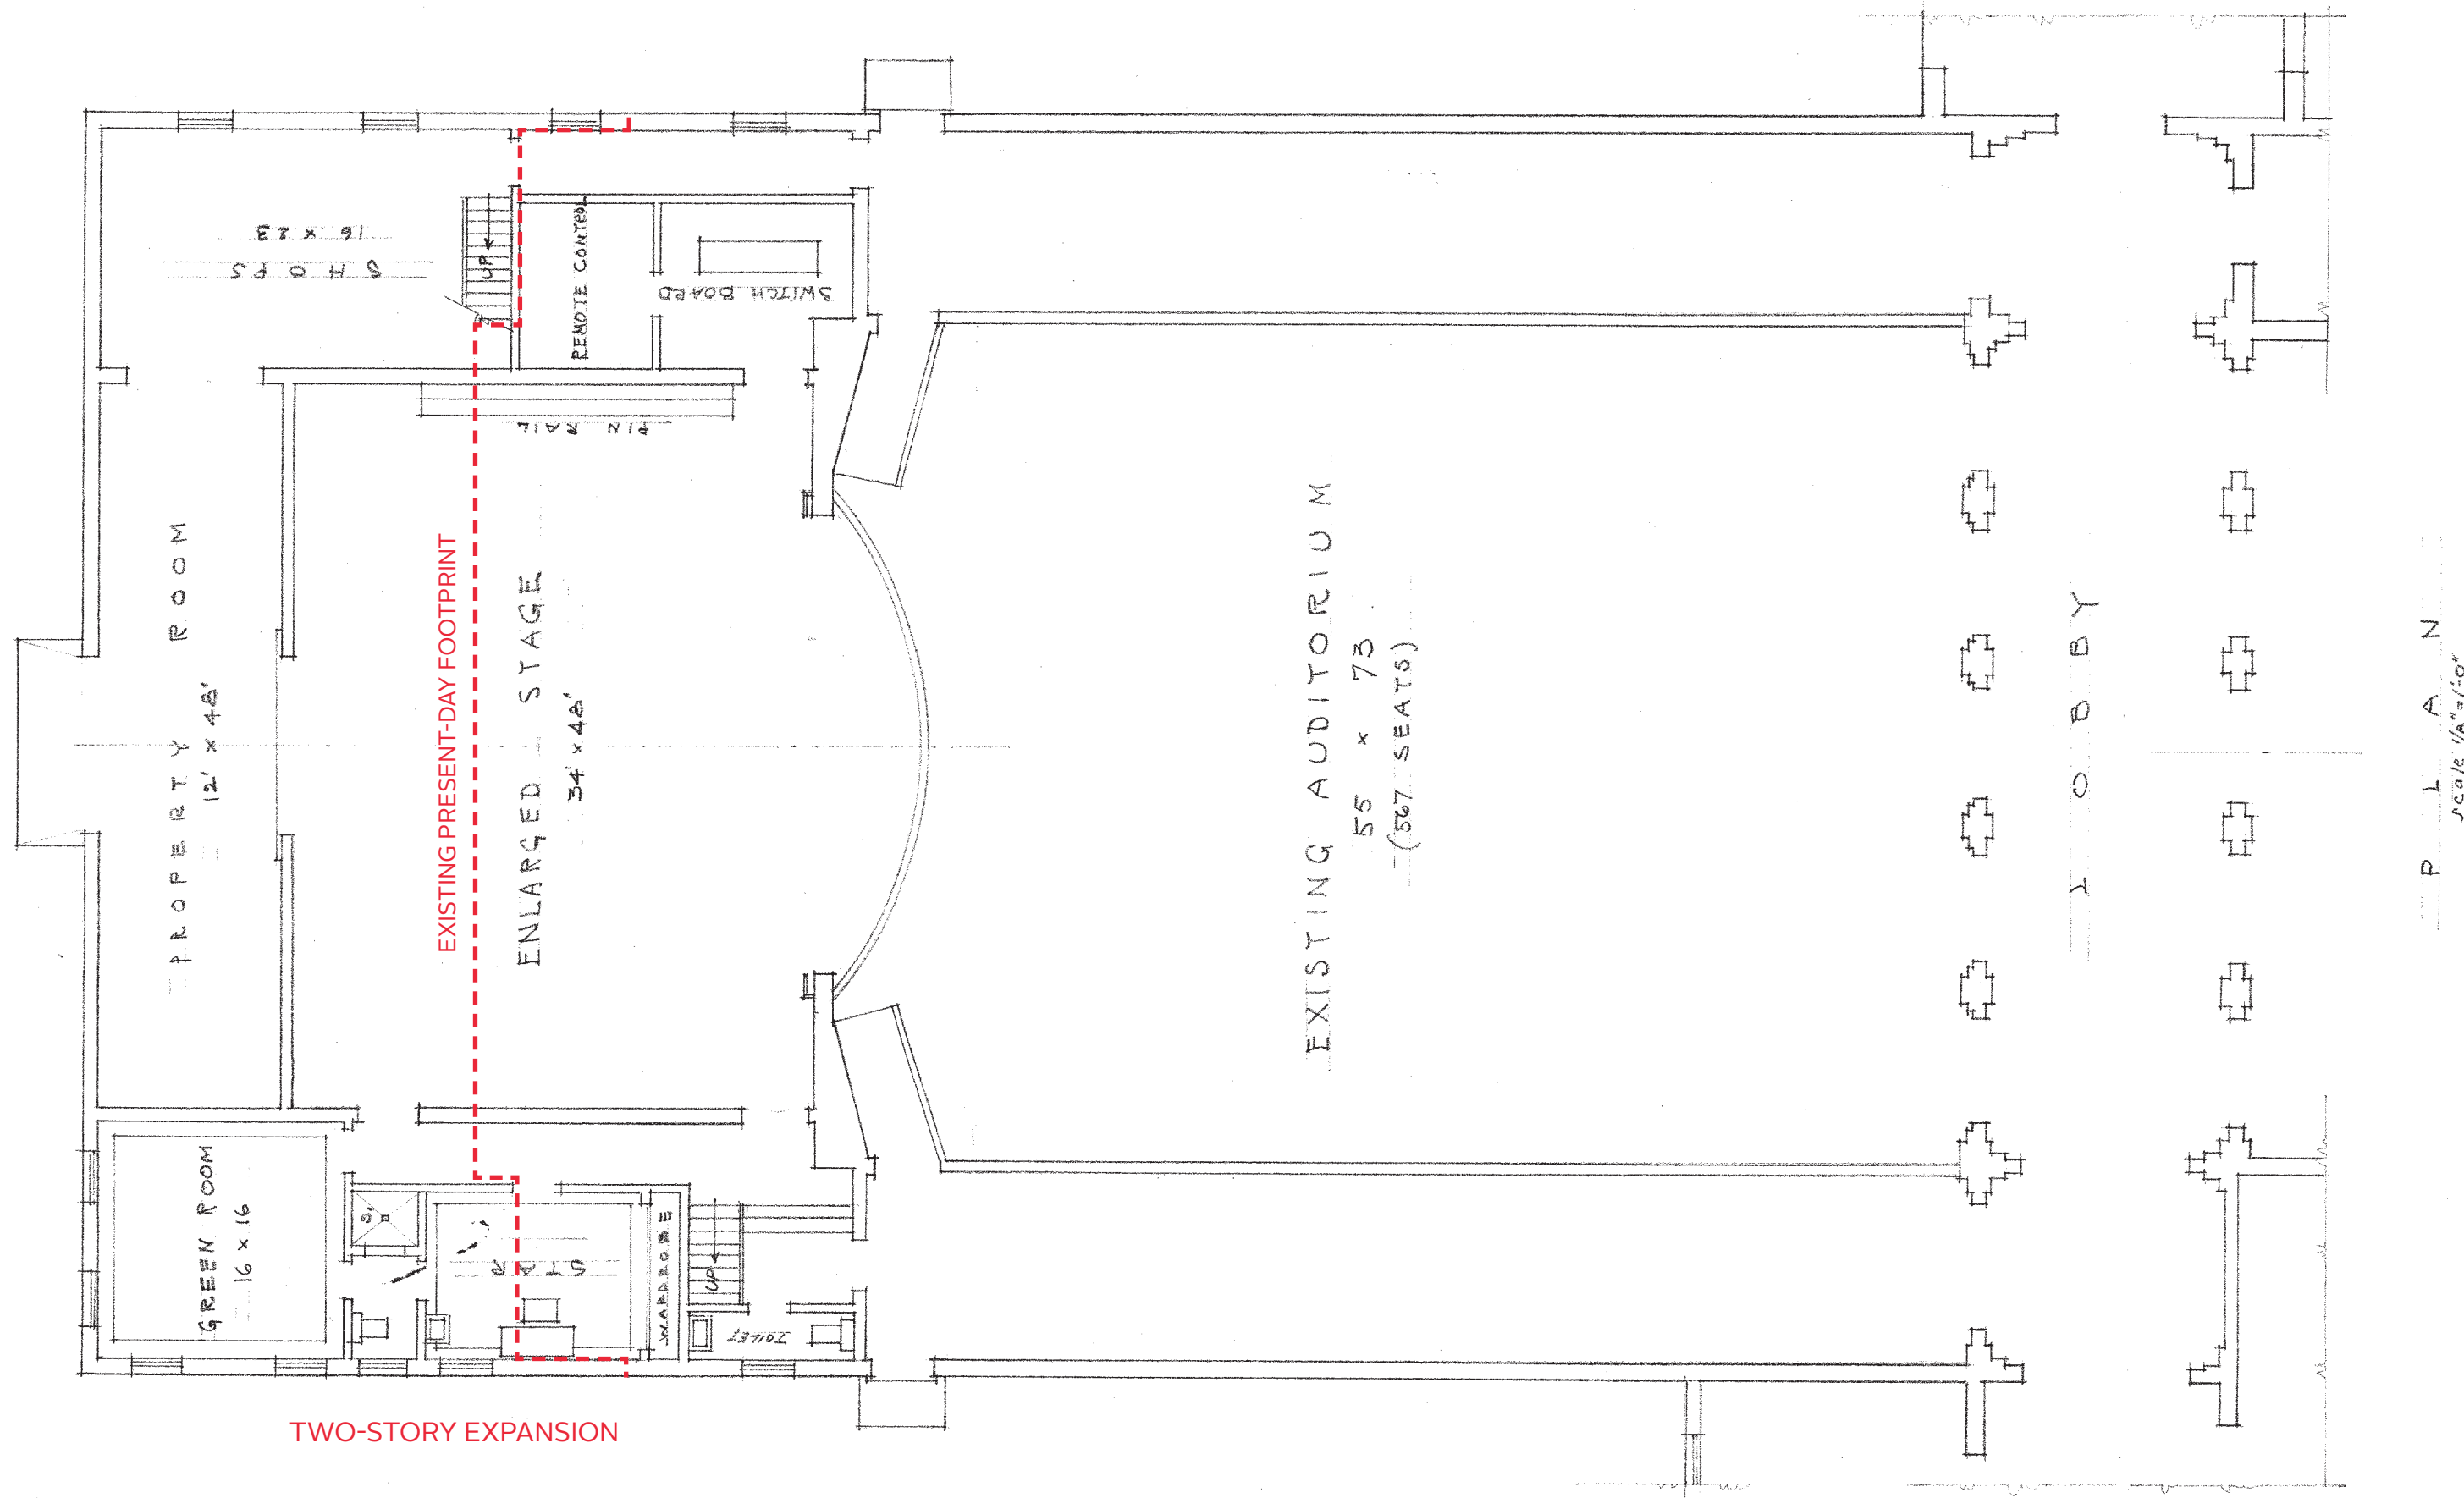

TWO-STORY EXPANSION

PROPOSED ENLARGEMENT TO THE STAGE FOR
THE SOCIETY OF THE FOUR ARTS: PALM BEACH, FLA.
WYETH, KING & JOHNSON JOHN L VOLK
ASSOCIATED ARCHITECTS

UNBUILT PROPOSALS

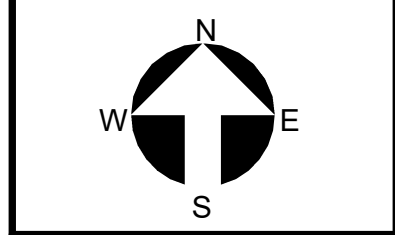

Project no: 2953
Date: 2024.10.07
Drawn by: Author
Project Manager: Checker

Revisions

THESE DRAWINGS ARE FOR THE EXCLUSIVE USE OF SPINA O'ROURKE + PARTNERS, INC. AND MAY NOT BE REPRODUCED, COPIED, OR USED IN ANY MANNER WITHOUT THE EXPRESS WRITTEN CONSENT OF SPINA O'ROURKE + PARTNERS, INC. ALL RIGHTS RESERVED.



The Society of the Four Arts -
Esther B. O'Keeffe Building


100 Four Arts Plaza, Palm Beach, FL 33480



SPINA O'ROURKE
+ PARTNERS
Architecture • Interior Design
Keith M. Spina #


285 Banyan Blvd
West Palm Beach
FL 33407
spinaorourke.com
407.884.3340
A20002399

BEYER
BLINDER
BELLE
120 Broadway
20th Floor
New York, NY, 10271
212.777.7800
beyerblinderbelle.com

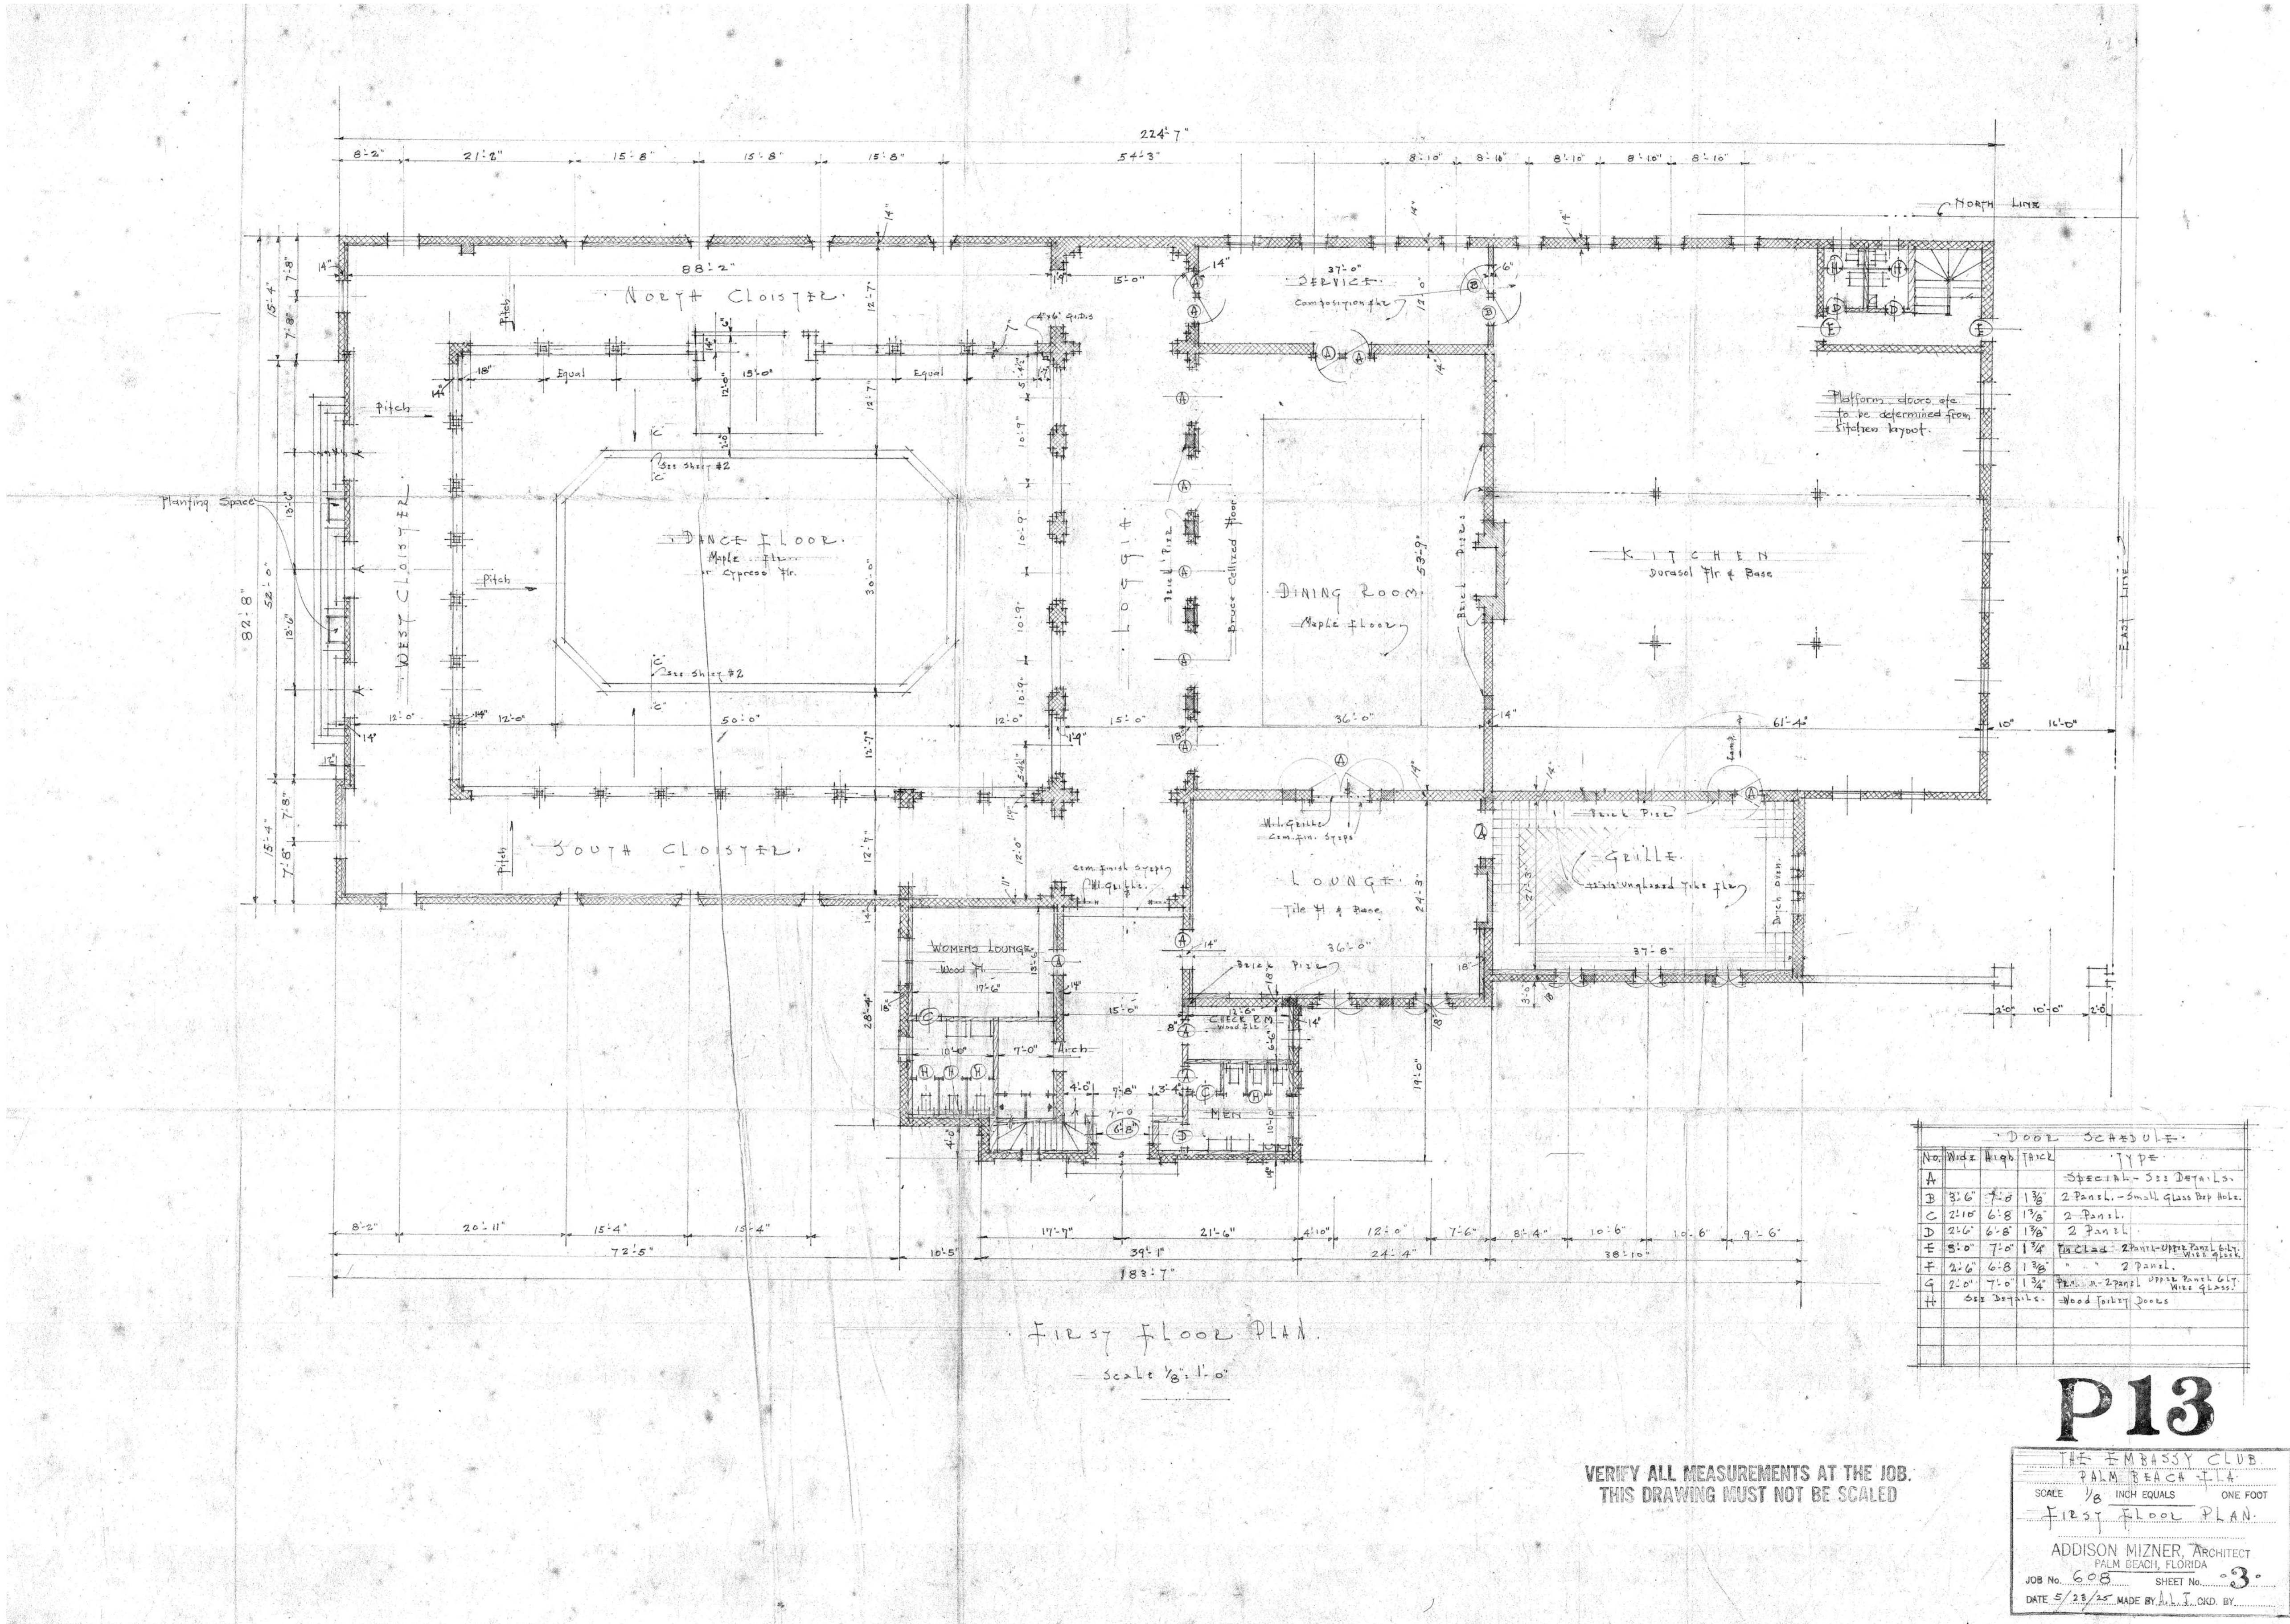


1 FIRST FLOOR PLAN - ADDISON MIZNER, 1925
B-2.1.0 3/32" = 1'-0"



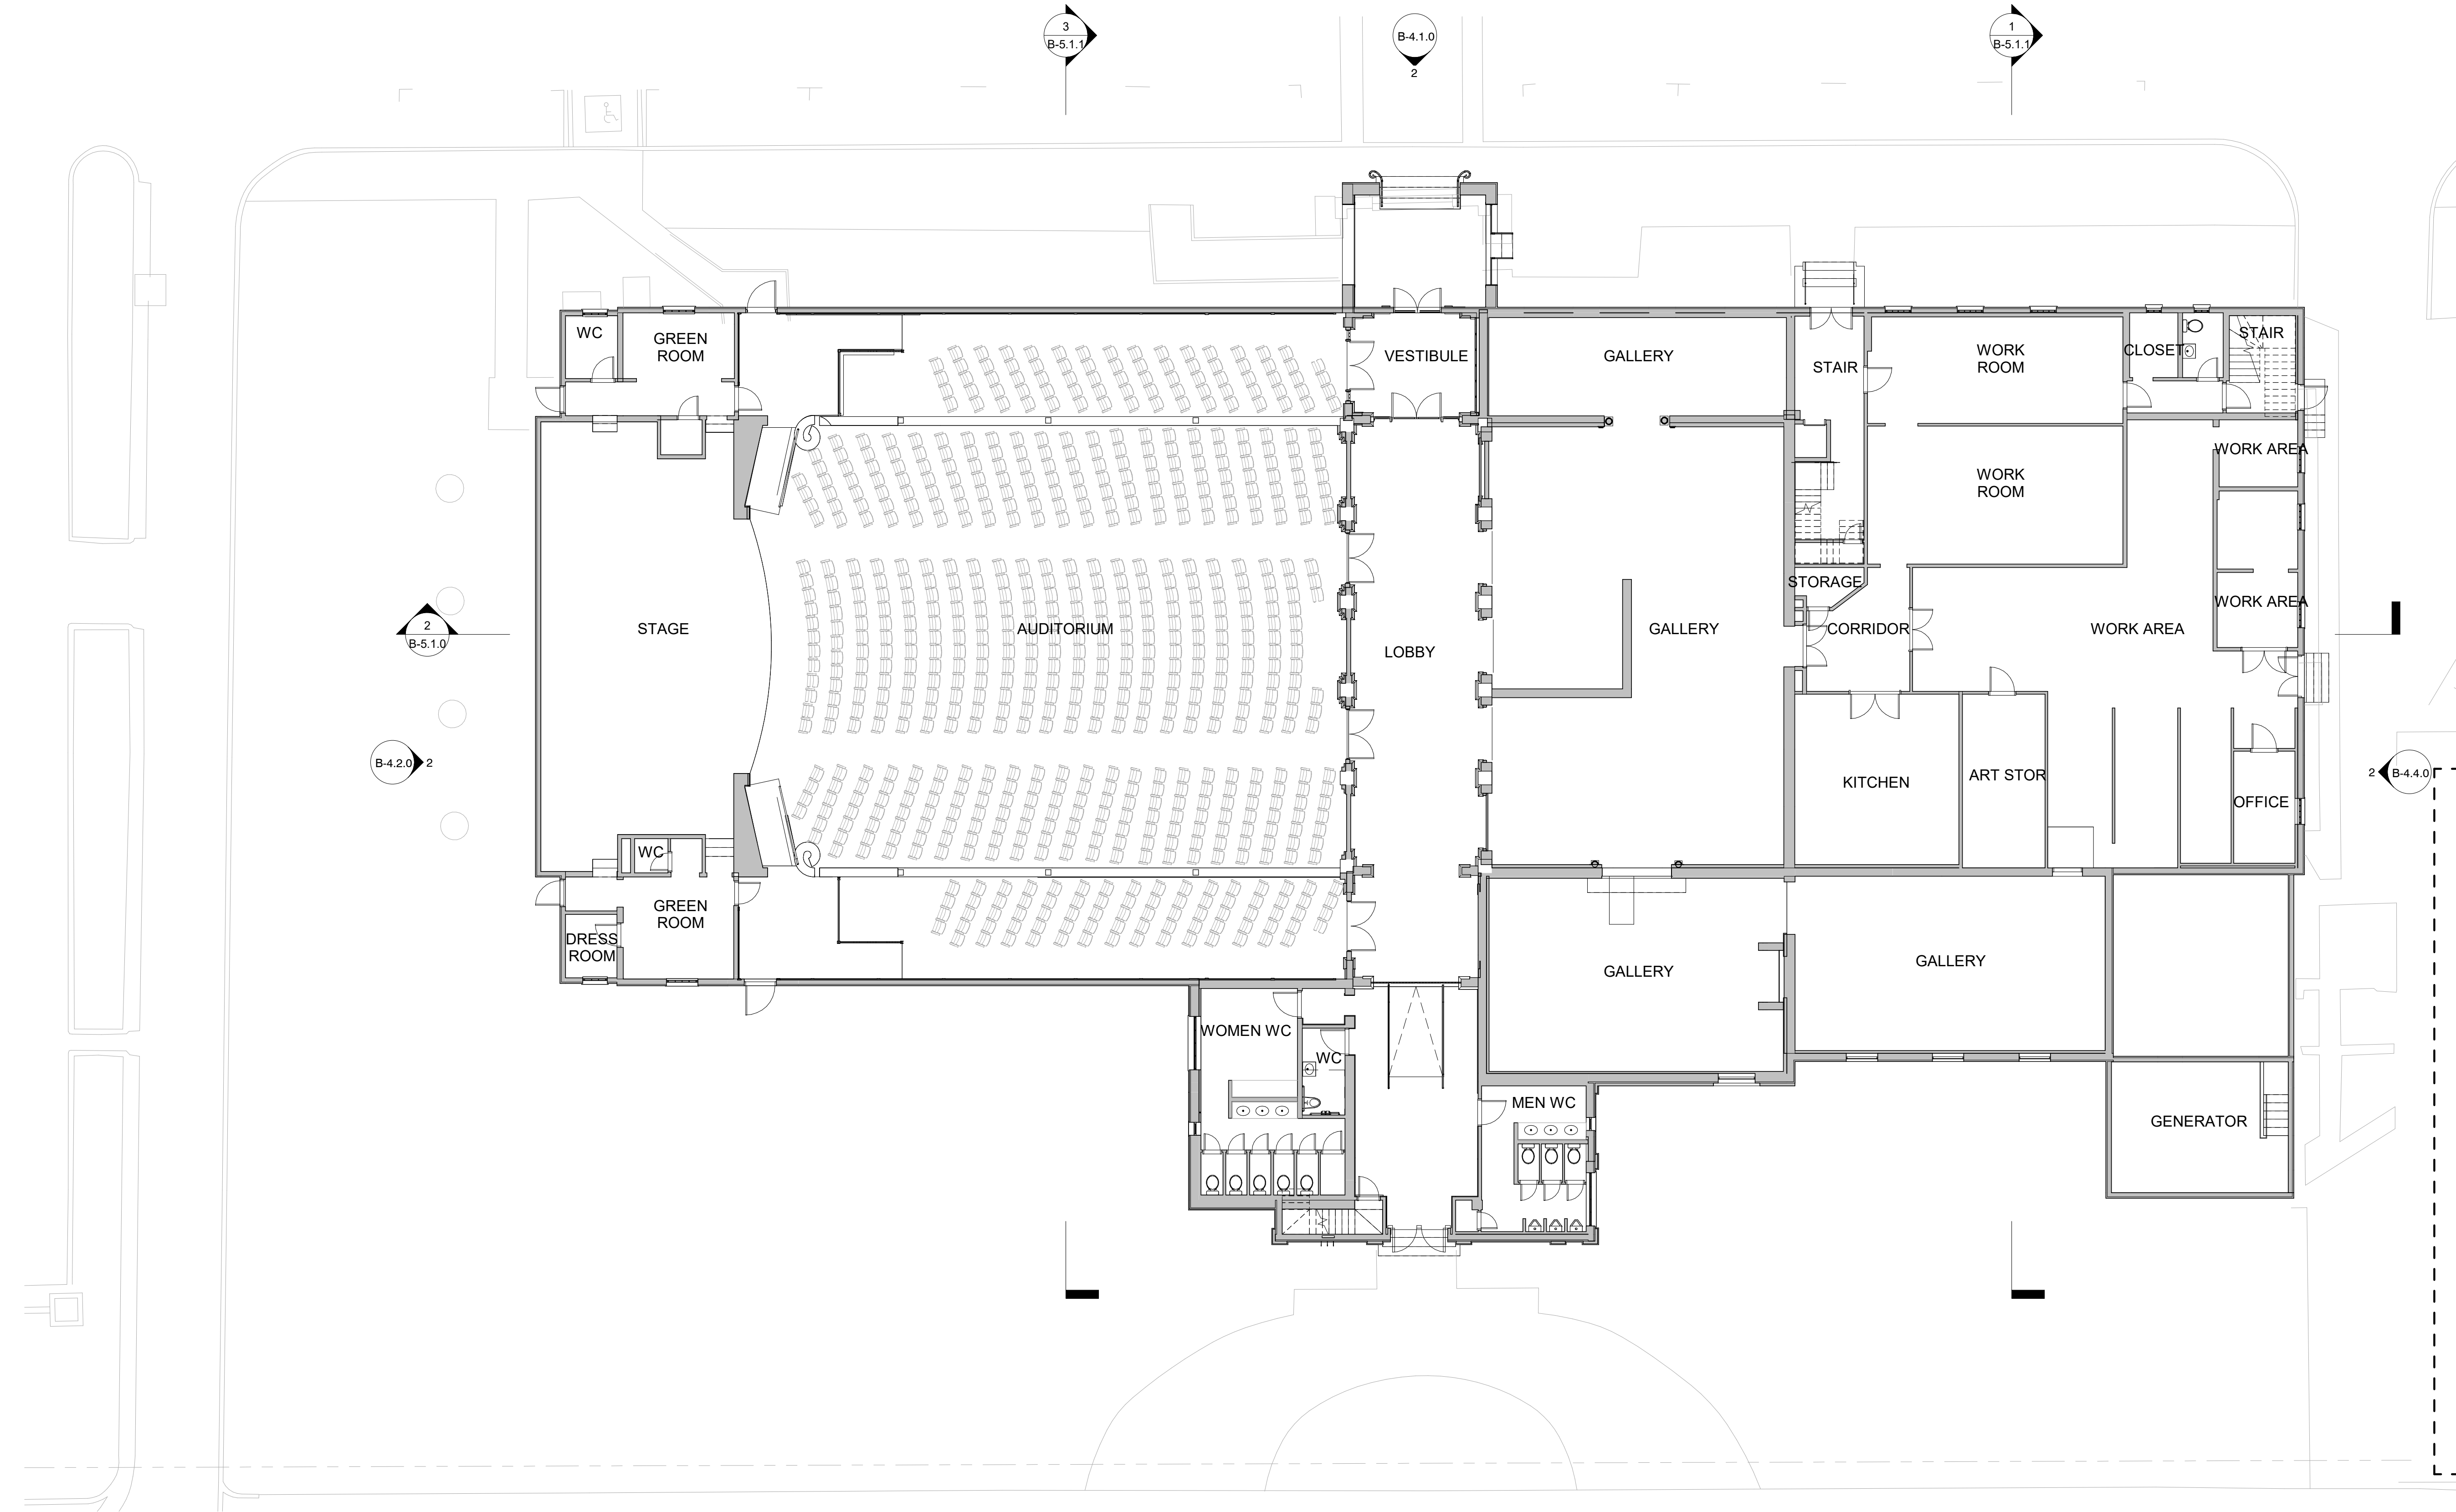

1 EXISTING PLAN - GROUND FLOOR
B-2.1.2 3/32" = 1'-0"

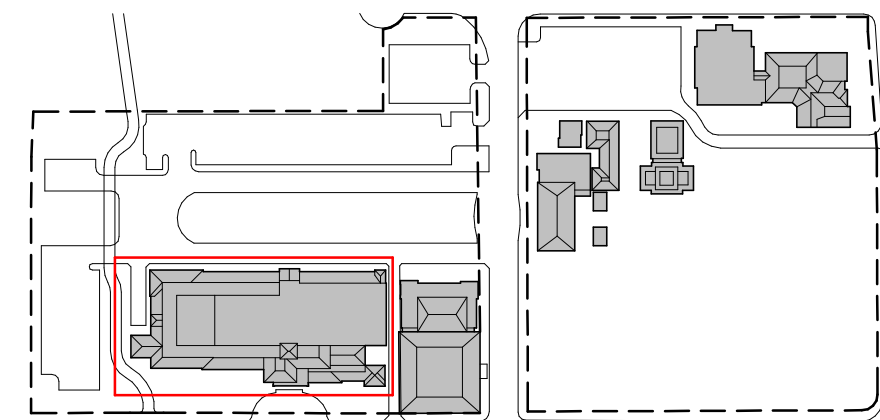

**BEYER
BLINDER
BELLE**

120 Broadway
20th Floor
New York, NY 10271
212.777.7800
beyerblinderbelle.com

**SPINAOROURKE
+ PARTNERS**



285 Banyan Blvd
West Palm
Beach
FL 33407
305.884.8844
spinaorourke.com
AA26002399

Architecture • Interior Design

Kath M. Spina #


**The Society of the Four Arts -
Esther B. O'Keeffe Building**

100 Four Arts Plaza, Palm Beach, FL 33480

THESE DRAWINGS ARE FOR THE
EXCLUSIVE USE OF SPINA OROURKE +
PARTNERS, INC. AND MAY NOT BE
DUPLICATED, REPRODUCED OR USED
IN ANY MANNER WITHOUT THE
EXPRESS WRITTEN CONSENT OF SPINA
OROURKE + PARTNERS, INC. ALL
RIGHTS ARE RESERVED.

Revisions


Project no: 2953
Date: 2024.10.07
Drawn by: Author
Project Manager: Checker

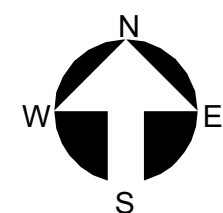

EXISTING PLAN - FIRST FLOOR

B-2.1.2

Final Submittal

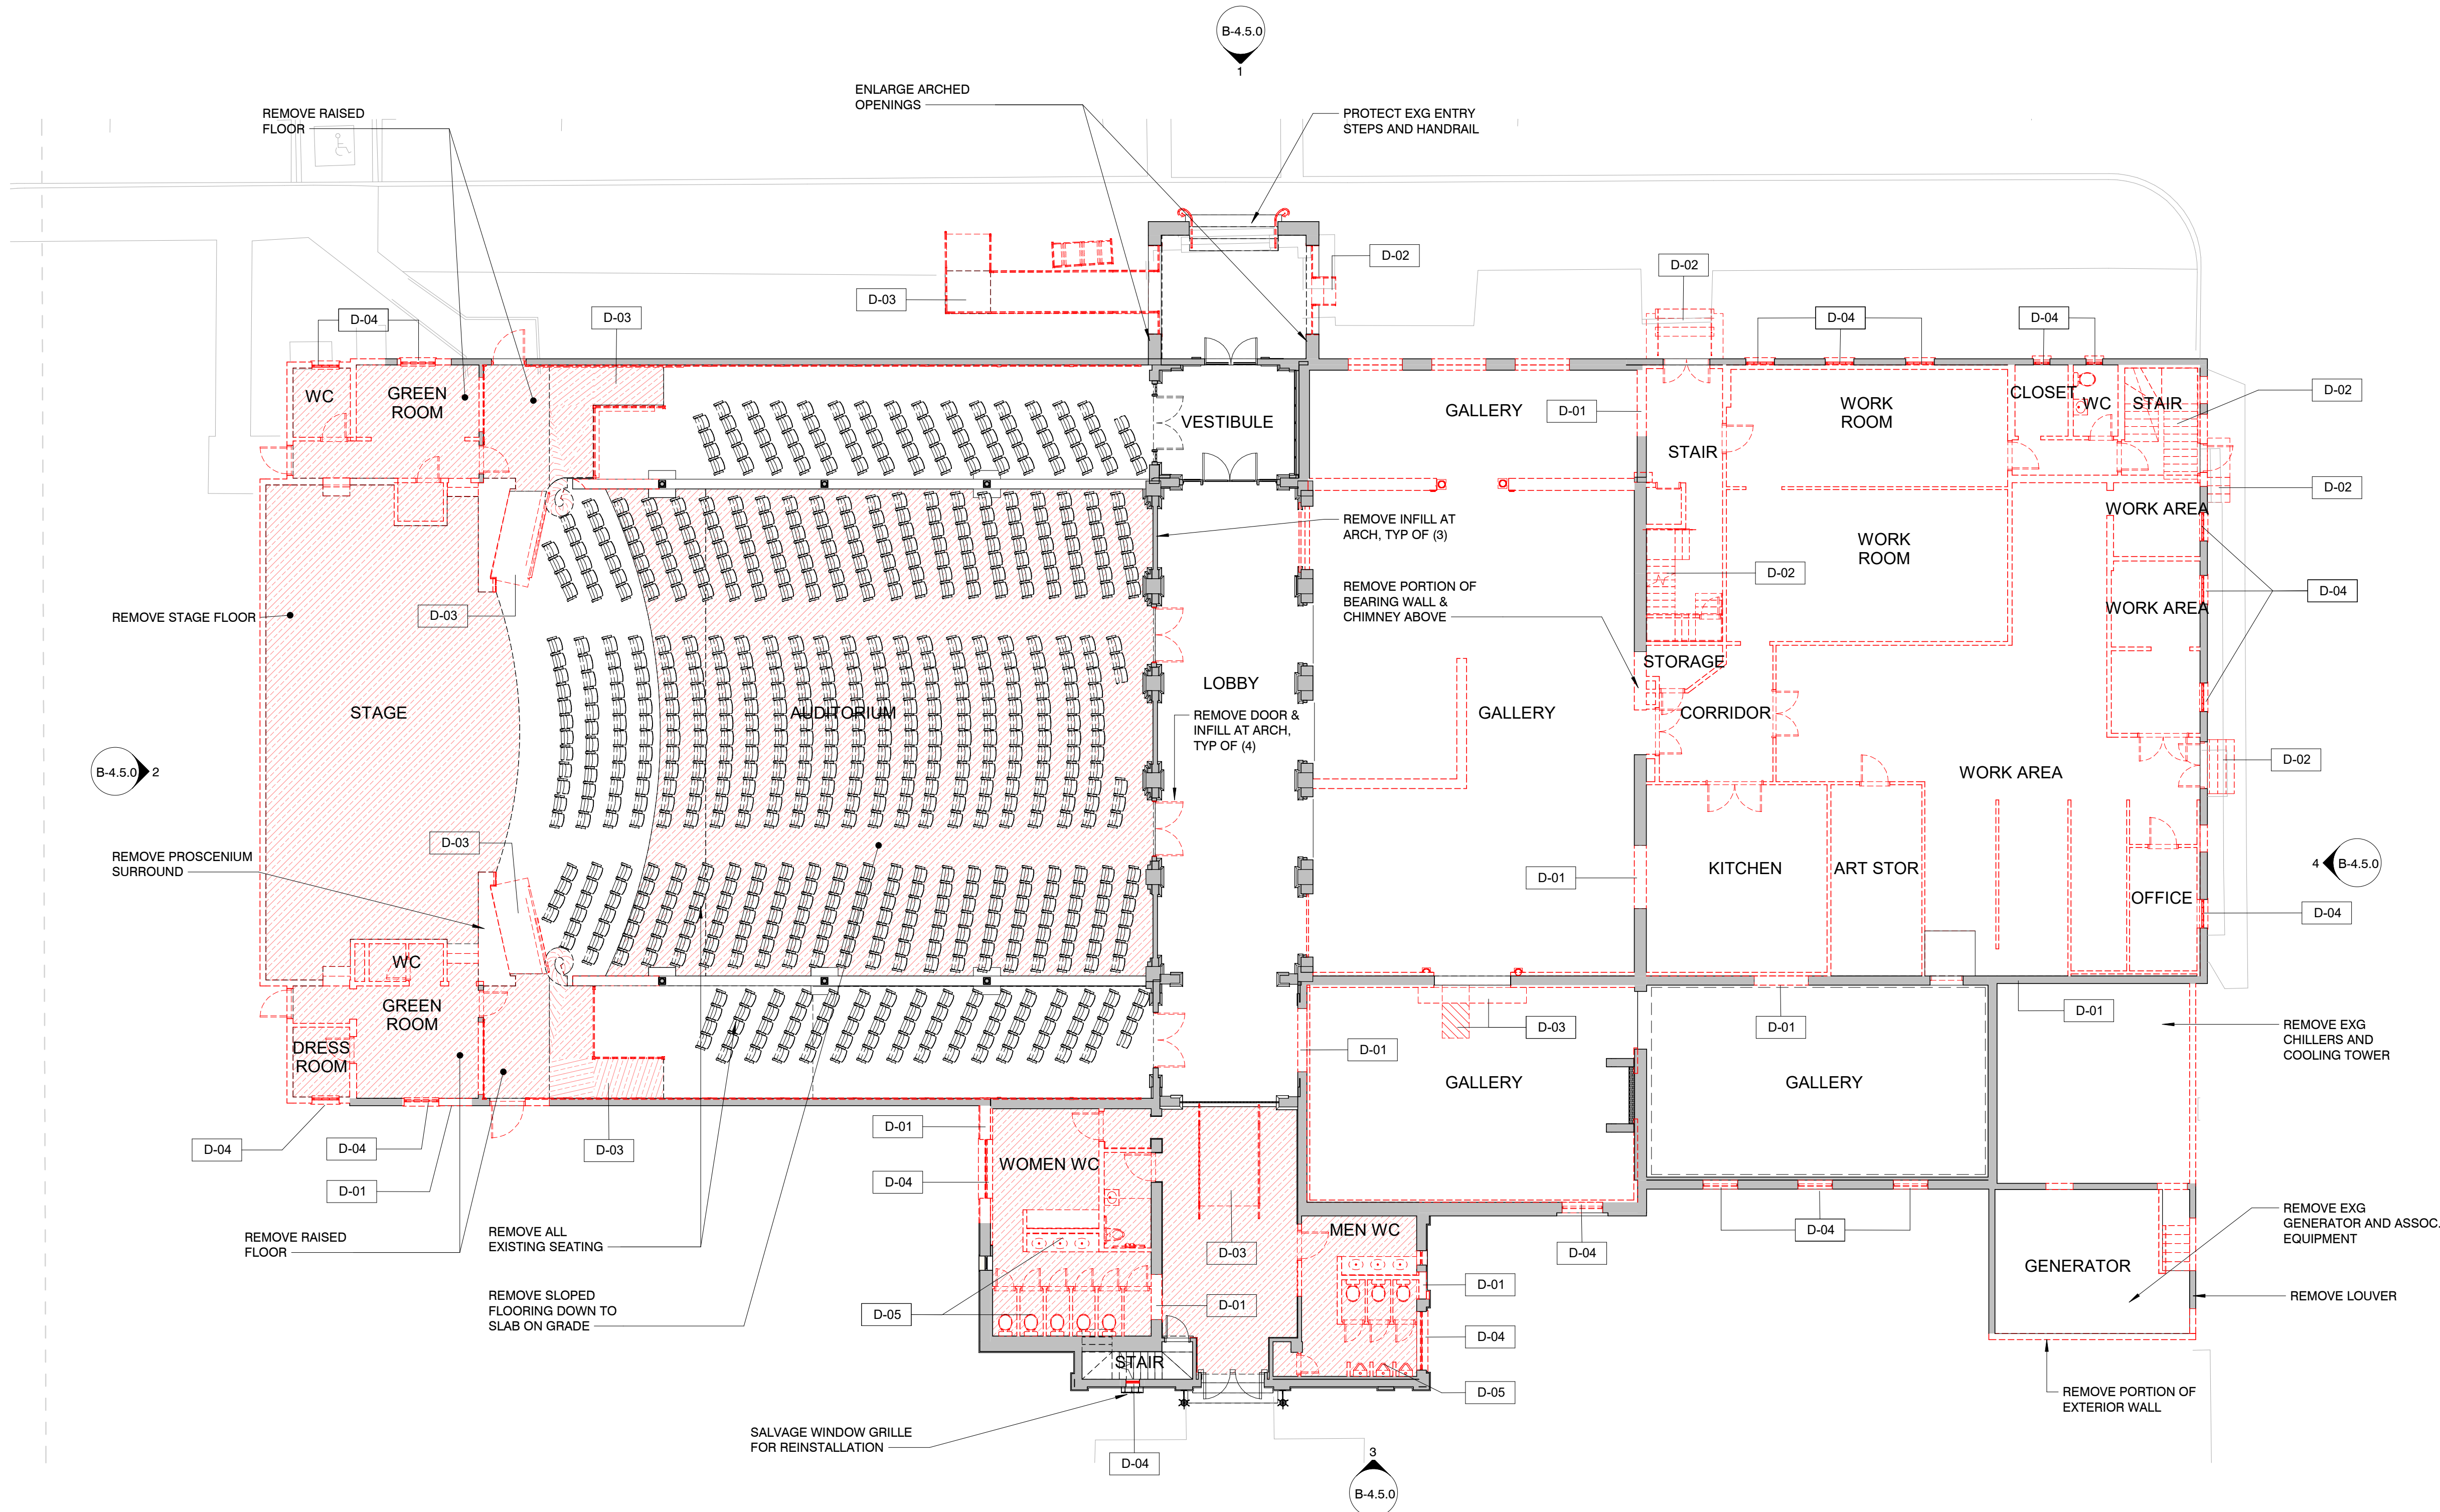



1 FIRST FLOOR MATERIAL REMOVAL PLAN
B-2.1.3 3/32" = 1'-0"


LEGEND

- EXISTING CONSTRUCTION TO REMAIN
- EXISTING WALL CONSTRUCTION TO BE REMOVED
- EXISTING SLAB TO BE REMOVED
- EXISTING DOORS TO BE REMOVED


DEMOLITION & SALVAGE KEYNOTES

KEYNOTE	DESCRIPTION
D-01	REMOVE PORTION OF BEARING WALL FOR NEW OPENING.
D-02	REMOVE STAIR.
D-03	REMOVE RAMP & RAILINGS.
D-04	REMOVE WINDOW.
D-05	REMOVE ALL PLUMBING FIXTURES.

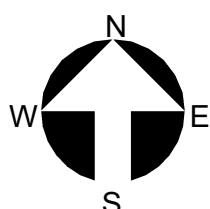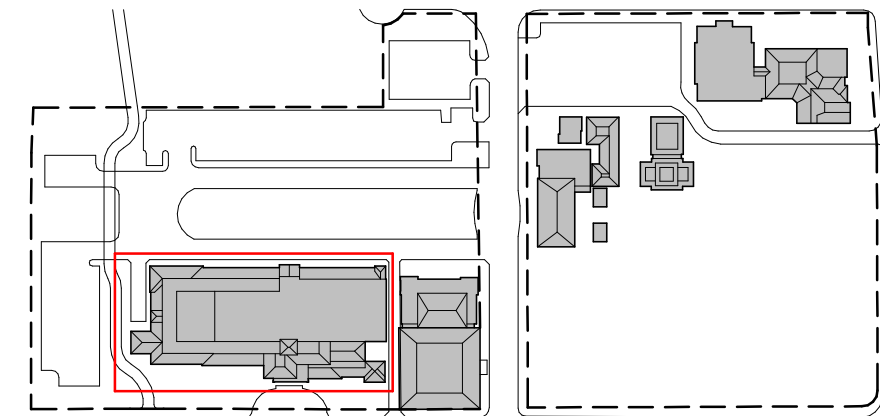

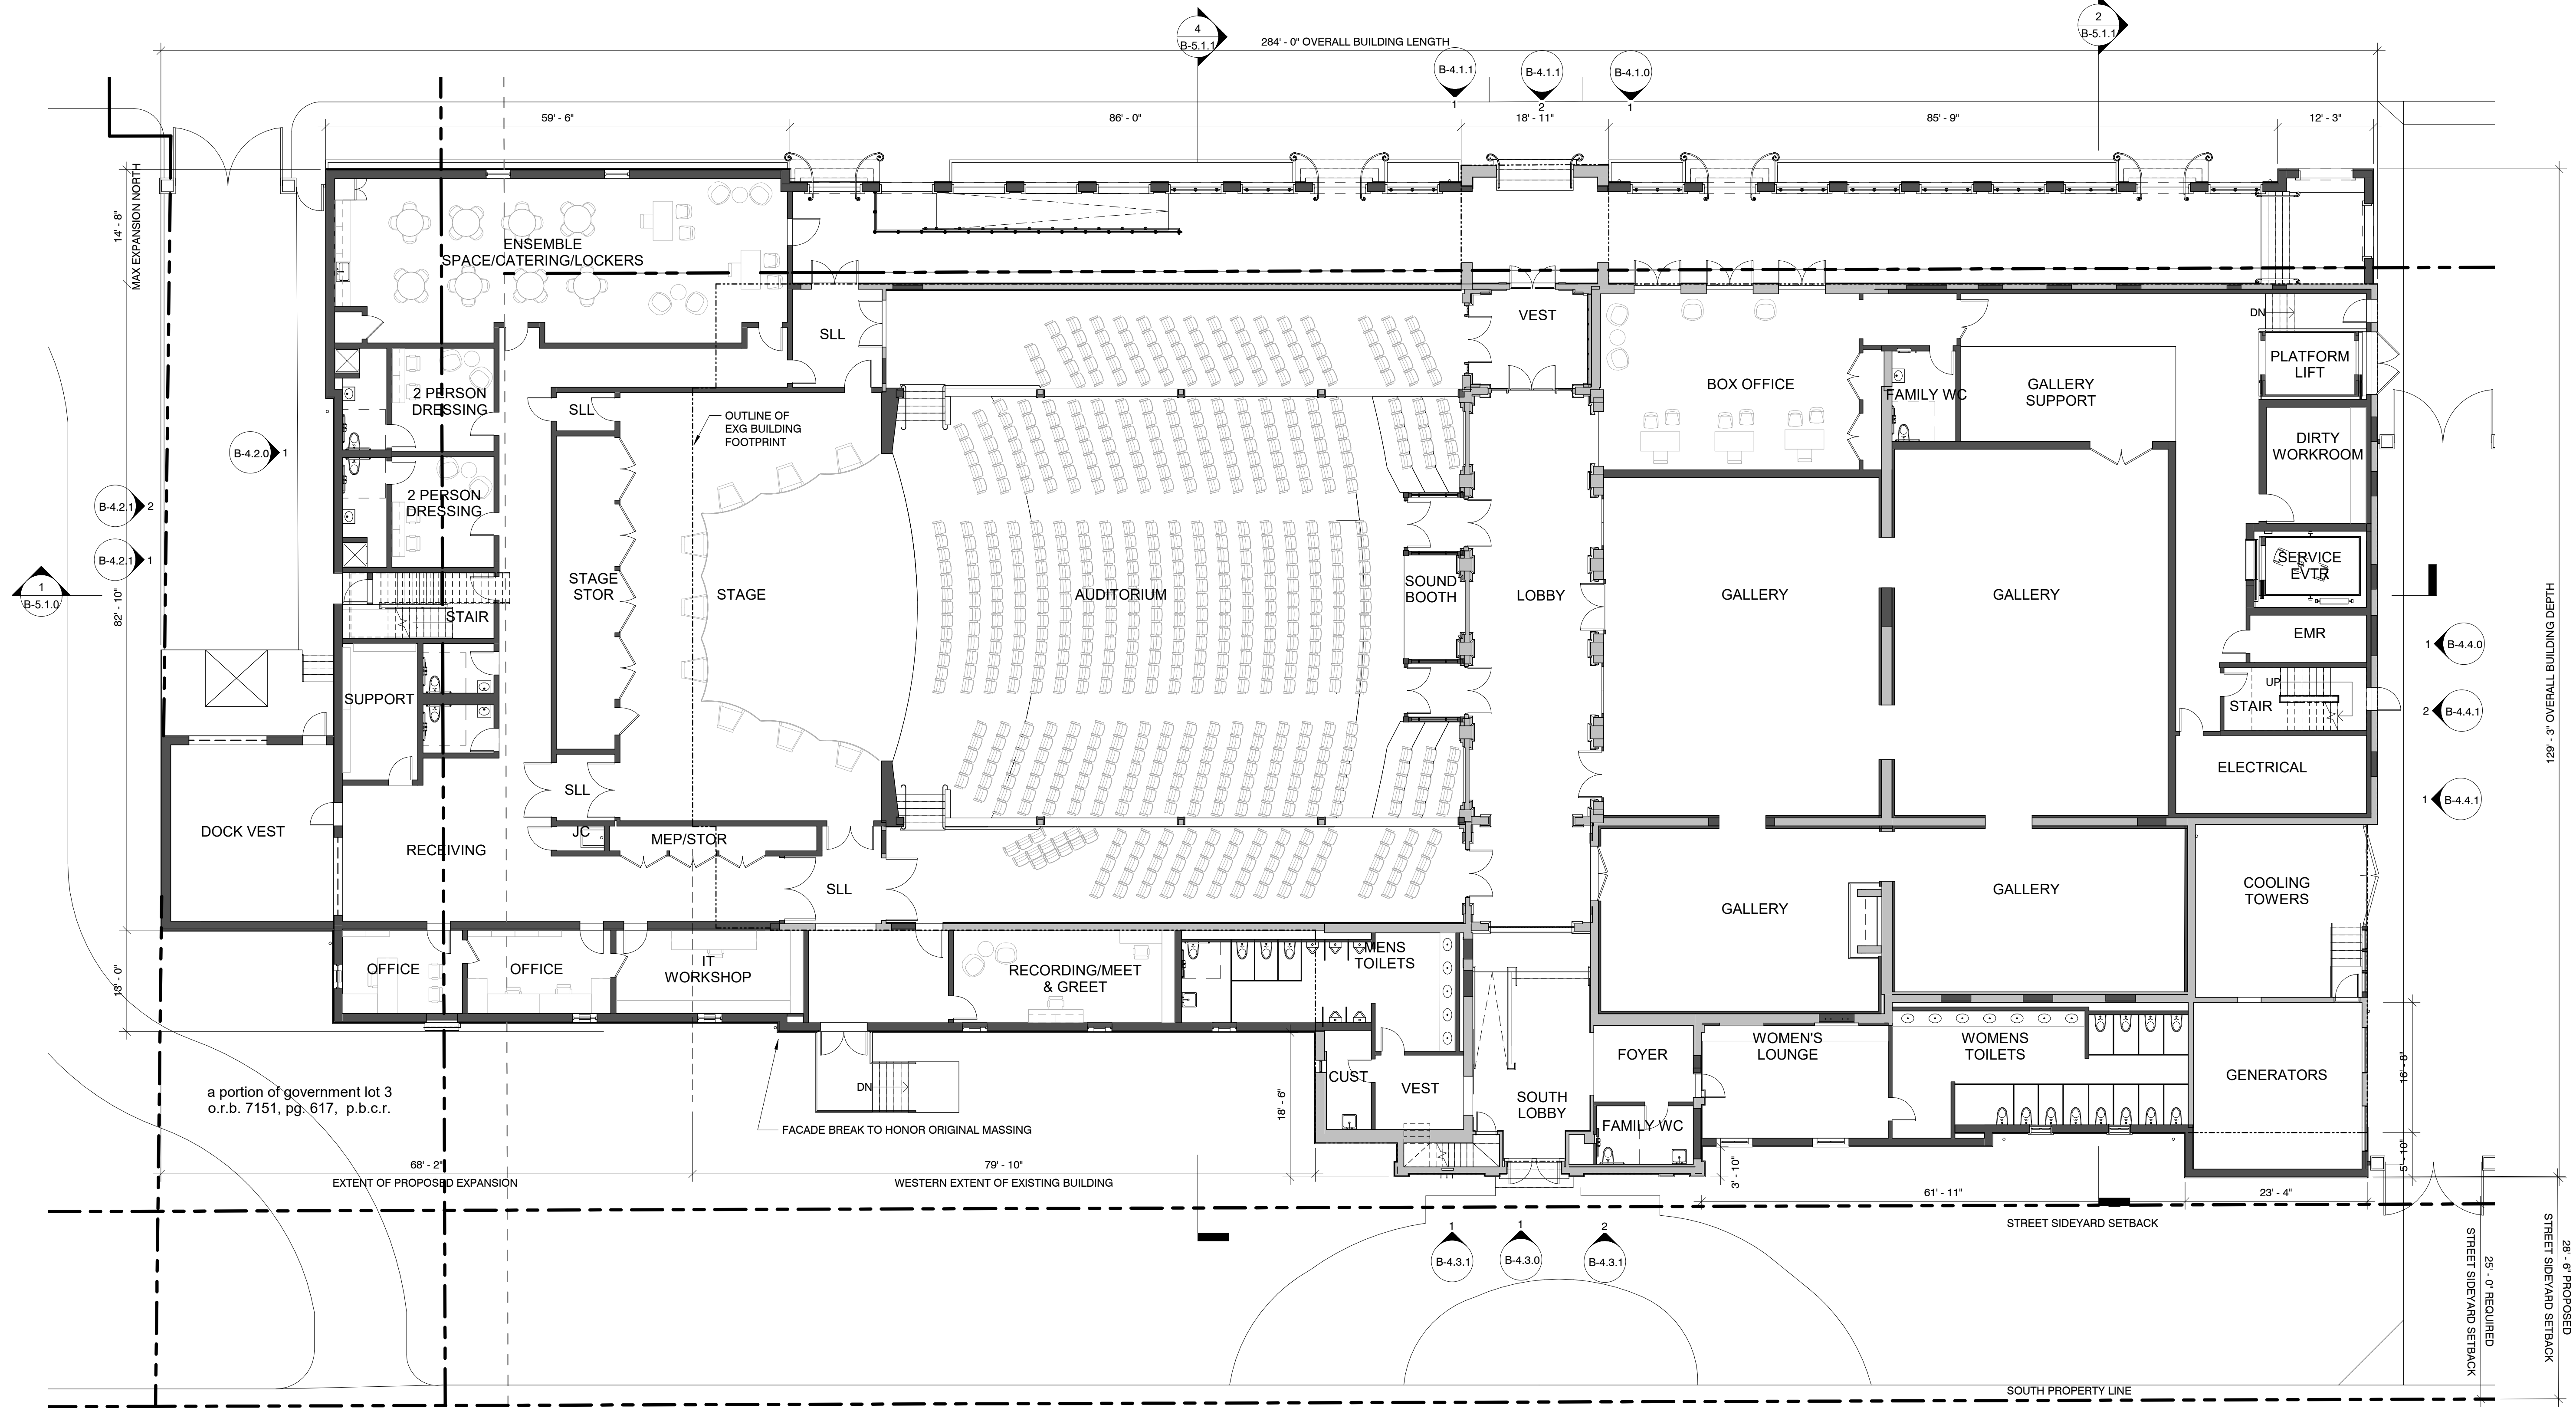

1 PROPOSED PLAN - GROUND FLOOR
B-2.1.4 3/32" = 1'-0"

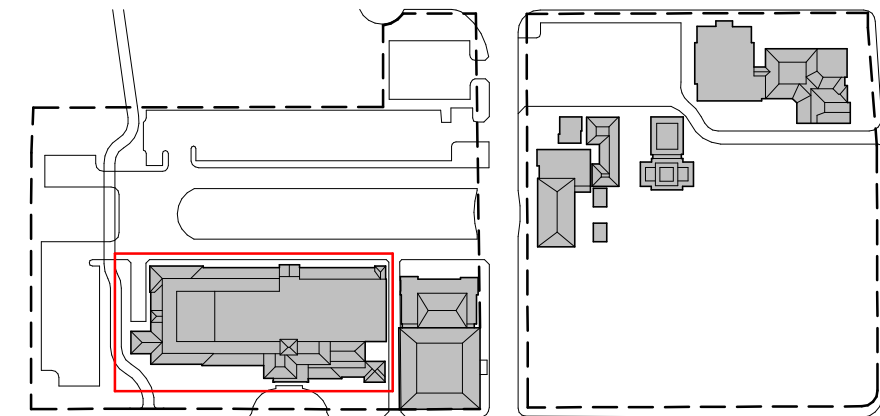

BEYER BLINDER BELLE
120 Broadway
20th Floor
New York, NY 10271
212.777.7800
beyerblinderbelle.com

285 Banyan Blvd
West Palm Beach
FL 33407
305.884.8844
spinaorourke.com
A42602399

SPINAOROURKE + PARTNERS
Architecture • Interior Design
Keith M. Spina #




**The Society of the Four Arts -
Esther B. O'Keeffe Building**
100 Four Arts Plaza, Palm Beach, FL 33480

THESE DRAWINGS ARE FOR THE EXCLUSIVE USE OF SPINAOROURKE + PARTNERS, INC. AND MAY NOT BE DUPLICATED, REPRODUCED OR USED IN ANY MANNER WITHOUT THE EXPRESS WRITTEN CONSENT OF SPINAOROURKE + PARTNERS, INC. ALL RIGHTS RESERVED.

Revisions

Project no: 2953
Date: 2024.10.07
Drawn by: Author
Project Manager: Checker

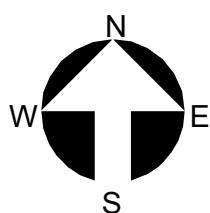

PROPOSED PLAN - FIRST FLOOR

B-2.1.4

Final Submittal