

PBDA PARKING LOT

241 SEAVIEW AVENUE, PALM BEACH, FLORIDA 33480

COA-22-026 | ZON-22-070

SUBMITTAL SCHEDULE:


2/22/2022 PRE-APP SUBMITTAL

3/07/2022 FIRST SUBMITTAL

03/28/2022 FINAL SUBMITTAL

04/08/2022 FINAL DROP-OFF

06/10/2022 LPC RE-SUBMITTAL

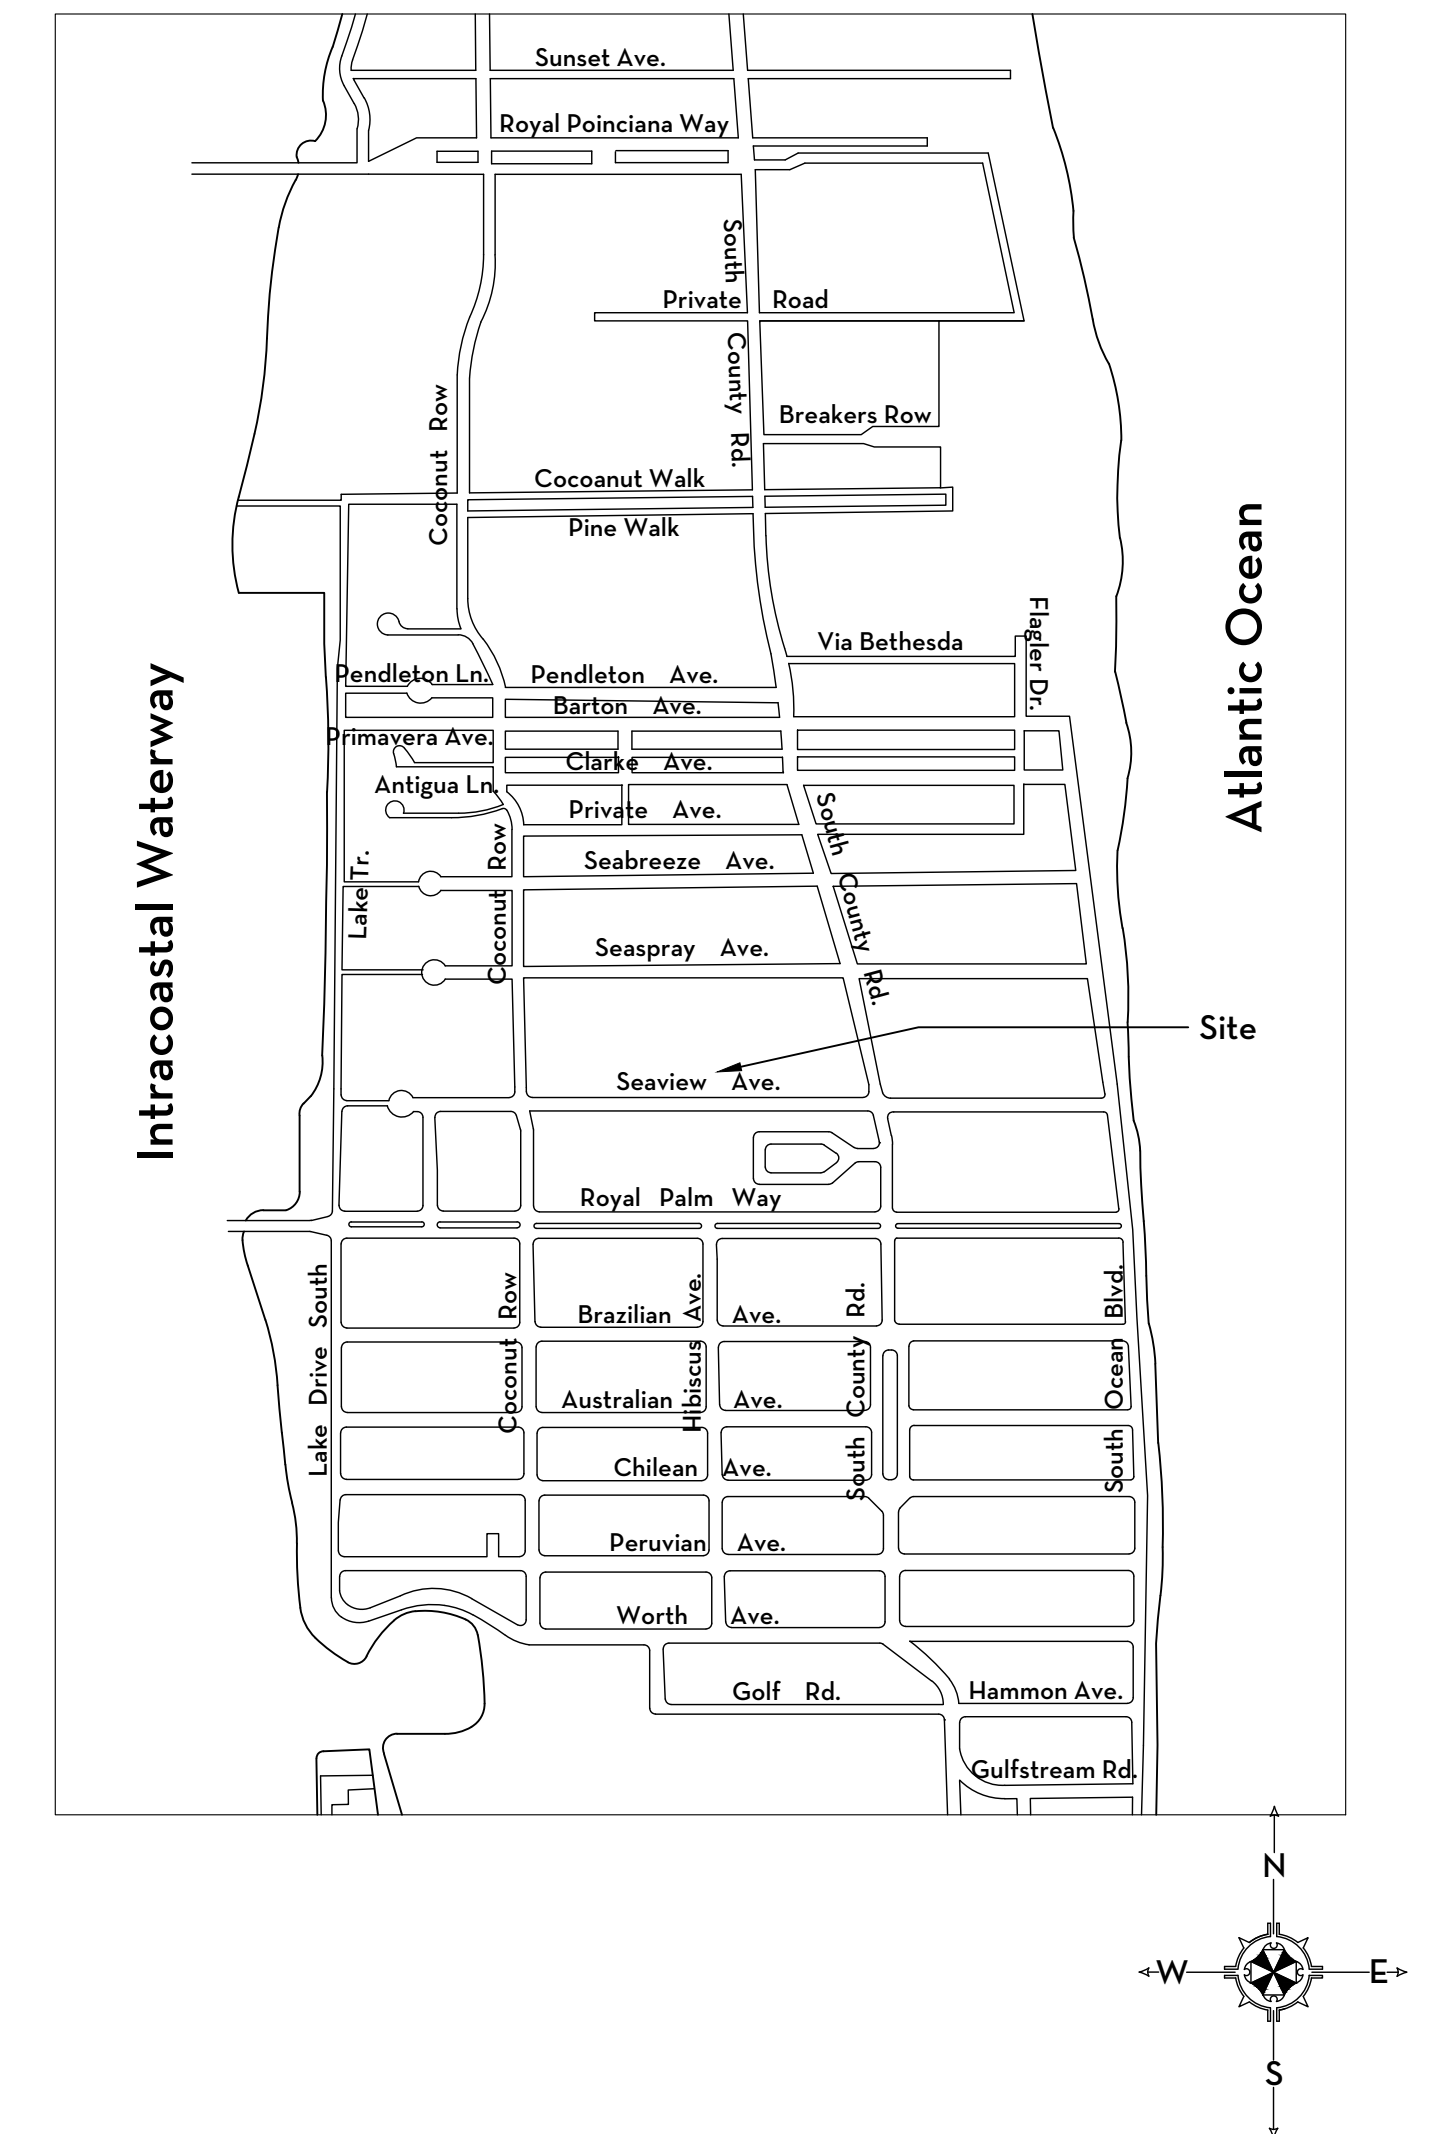


SHEET INDEX:

REVISED PLAN PACKAGE (LPo, L1, EL1, S1, IM1)

OPTION 2 PACKAGE (LPo, L1, EL1, S1)

S	SURVEY
SPo	LOCATION PLAN
EX1-EX3	EXISTING PHOTOS
Lo	OVERALL EXISTING SITE PLAN
Lo.1	OVERALL PROPOSED SITE PLAN
L1	SITE PLAN
LPo	ILLUSTRATIVE SITE PLAN
LP1	LANDSCAPE PLAN
LP2	LANDSCAPE MATERIAL SCHEDULE & DETAILS
ZD1	OPEN SPACE ZONING DIAGRAM
ZD2	EXISTING & PROPOSED PARKING DIAGRAM
LL1	LIGHTING PLAN & SPECIFICATIONS
D1-D2	SITE DETAILS
CSP	CONSTRUCTION SCREENING PLAN
EC-1	CONSTRUCTION STAGING PLAN
C-1	DRAINAGE PLAN

***CURRENTLY PROPOSED**

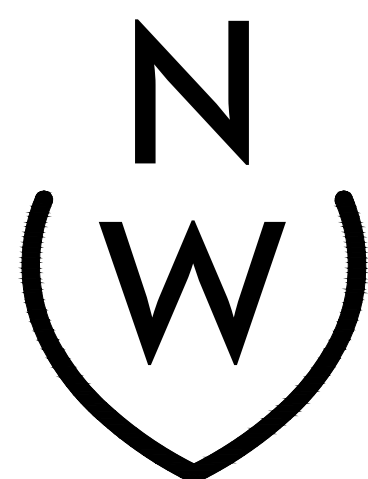

NIEVERA WILLIAMS
DESIGN

625 N. FLAGLER DRIVE
SUITE 502
WEST PALM BEACH, FLORIDA
P: 561-659-2820
F: 561-659-2113
nieverawilliams.com

*CURRENTLY PROPOSED

MARIO F. NIEVERA

State of Florida
Landscape Architect
Registration No.
6666856

OVERALL R-B SITE CALCULATIONS:

SITE AREA = 113,168 SQ FT 100%

MINIMUM LANDSCAPE:


REQUIRED = 56,584 SQ FT 50%
EXISTING = 68,151 SQ FT 60.2%
PROPOSED = 56,505 SQ FT 49.9%

FRONT SETBACK SITE CALCULATIONS:

25' SETBACK AREA = 28,119 SQ FT 100%

MINIMUM LANDSCAPE:


REQUIRED = 11,247 SQ FT 40%
EXISTING = 17,203 SQ FT 61.2%
PROPOSED = 16,851 SQ FT 59.9%

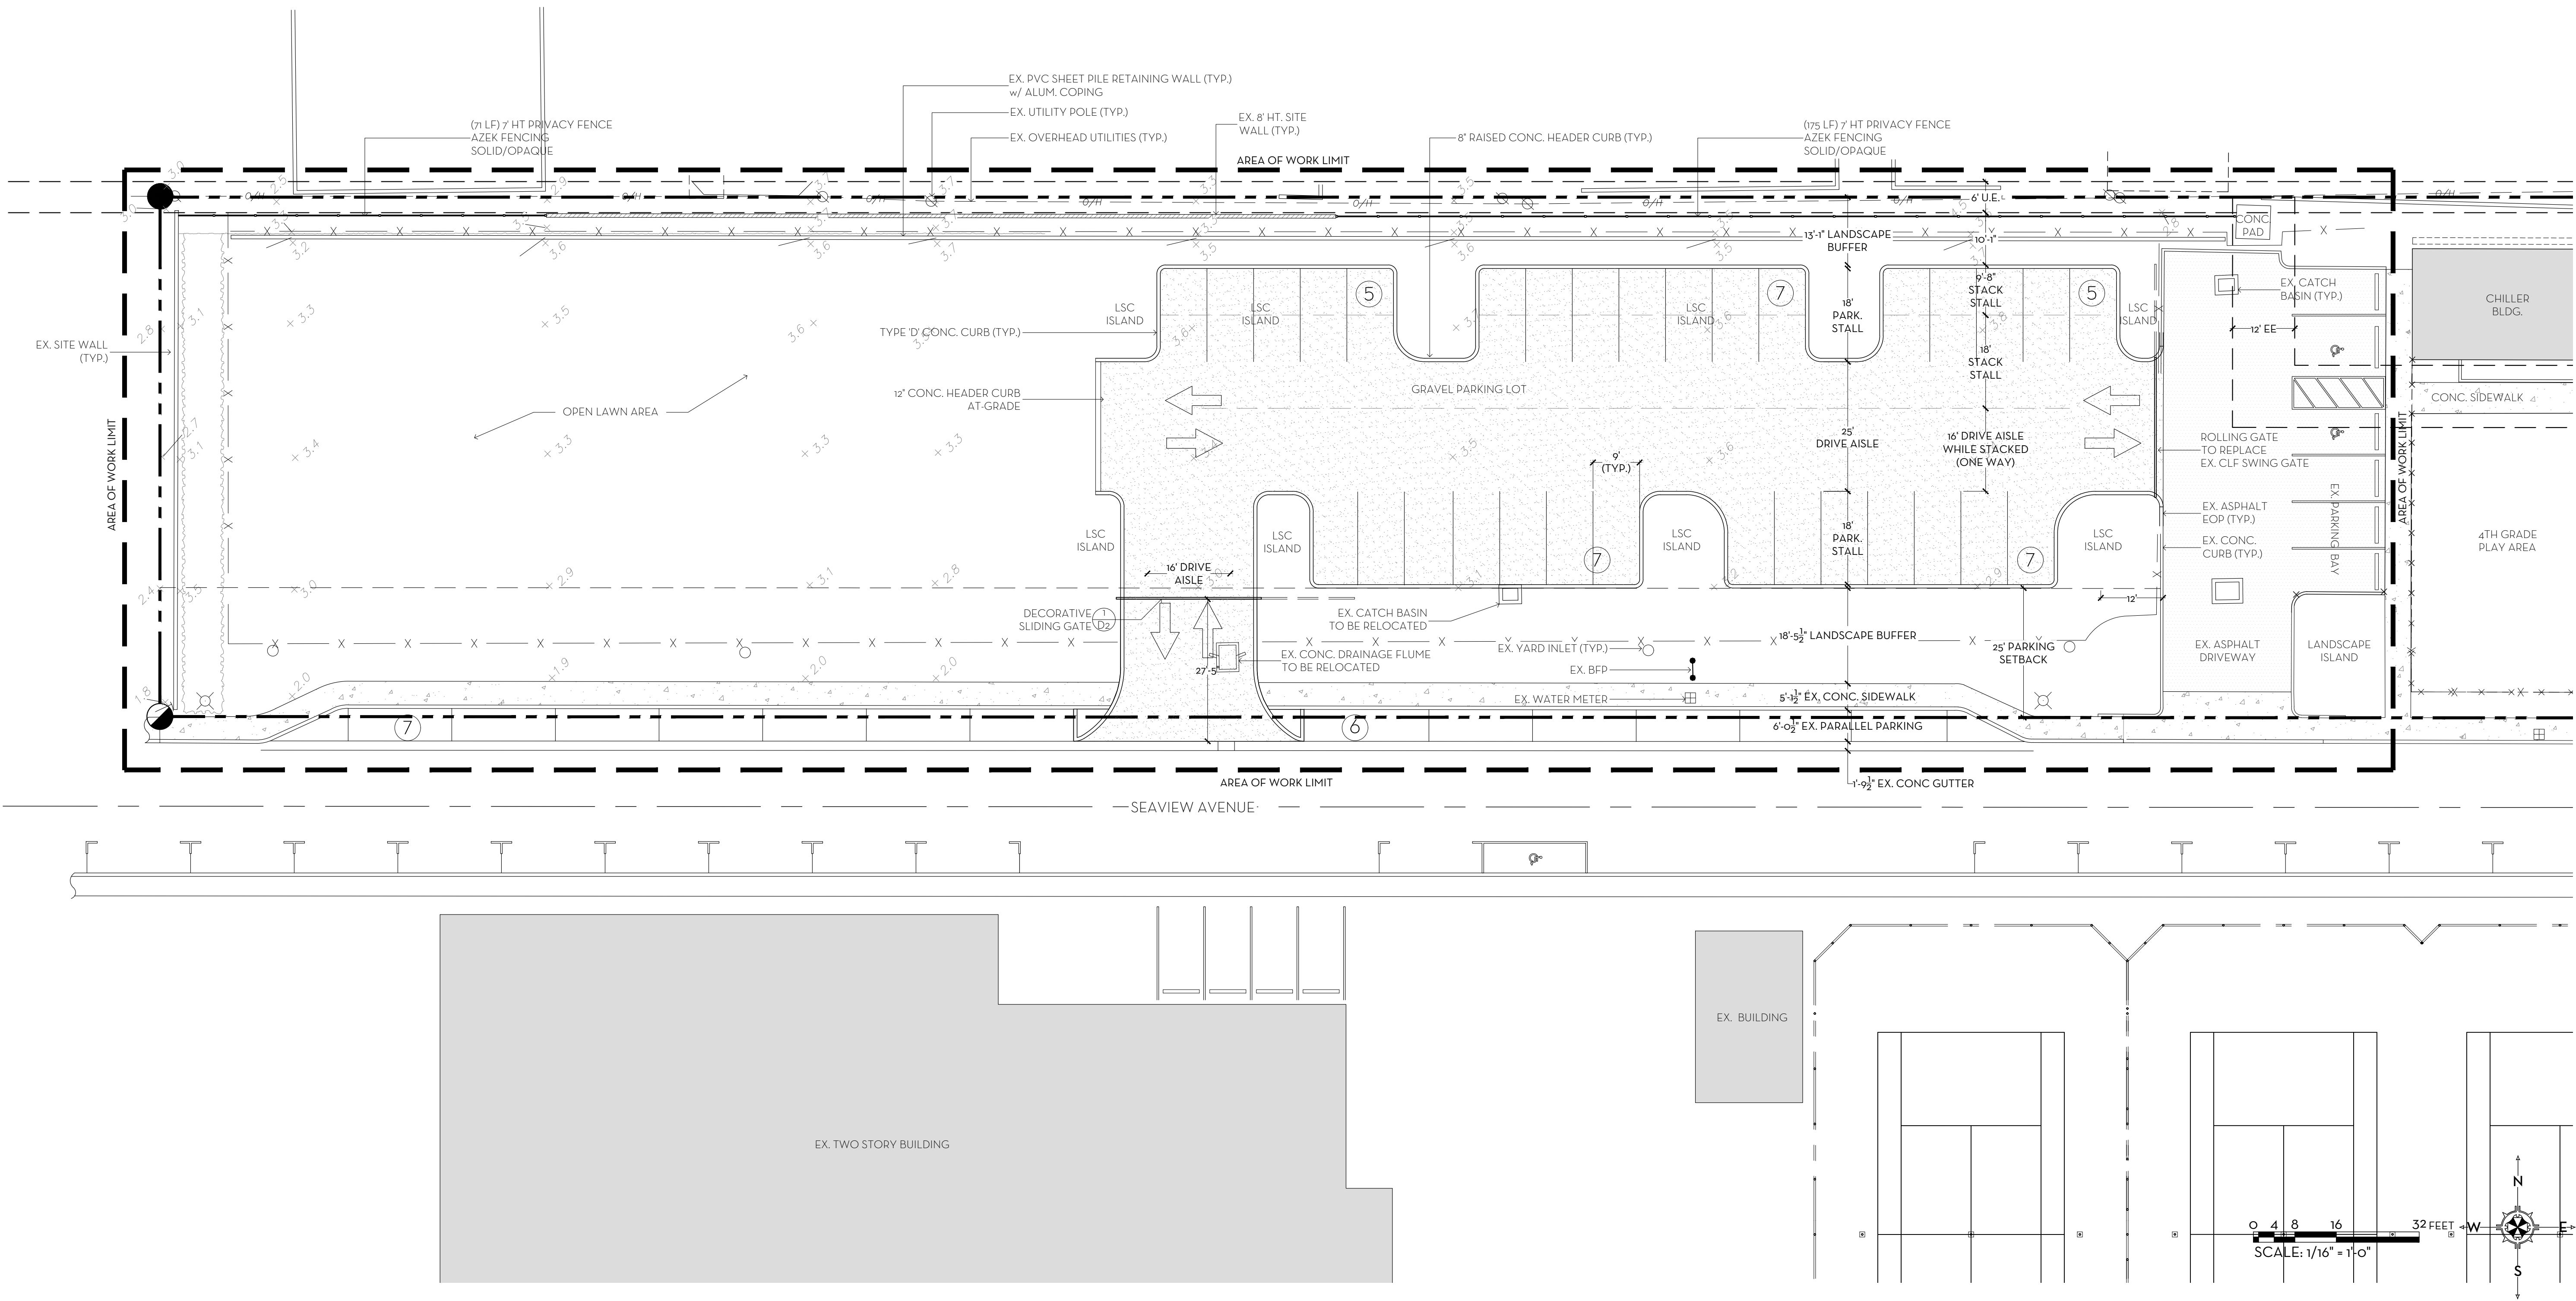

SITE PLAN
PBDA PARKING LOT

241 SEAVIEW AVENUE, PALM BEACH, FLORIDA 33480

08 APR 2022
28 MAR 2022
07 MAR 2022
22 FEB 2022

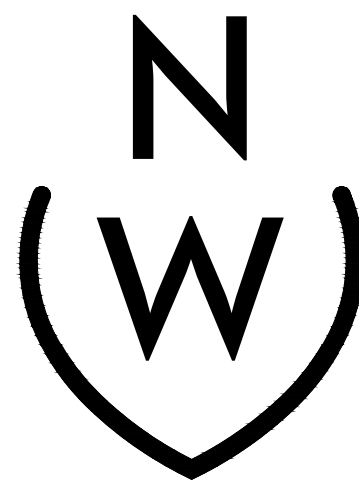


NIEVERA WILLIAMS
DESIGN

625 N. Flagler Drive
Suite 502
West Palm Beach, FL 33401
P: 561-659-2820
F: 561-659-2113


NIEVERAWILLIAMS.COM


COA-22-026 | ZON-22-070

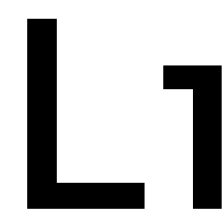

SCALE: 1/16" = 1'-0"

0 4 8 16 32 FEET
SCALE: 1/16" = 1'-0"

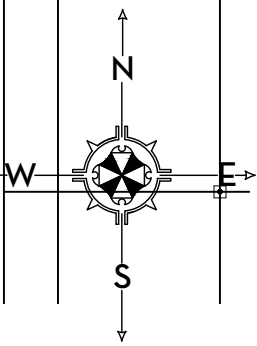

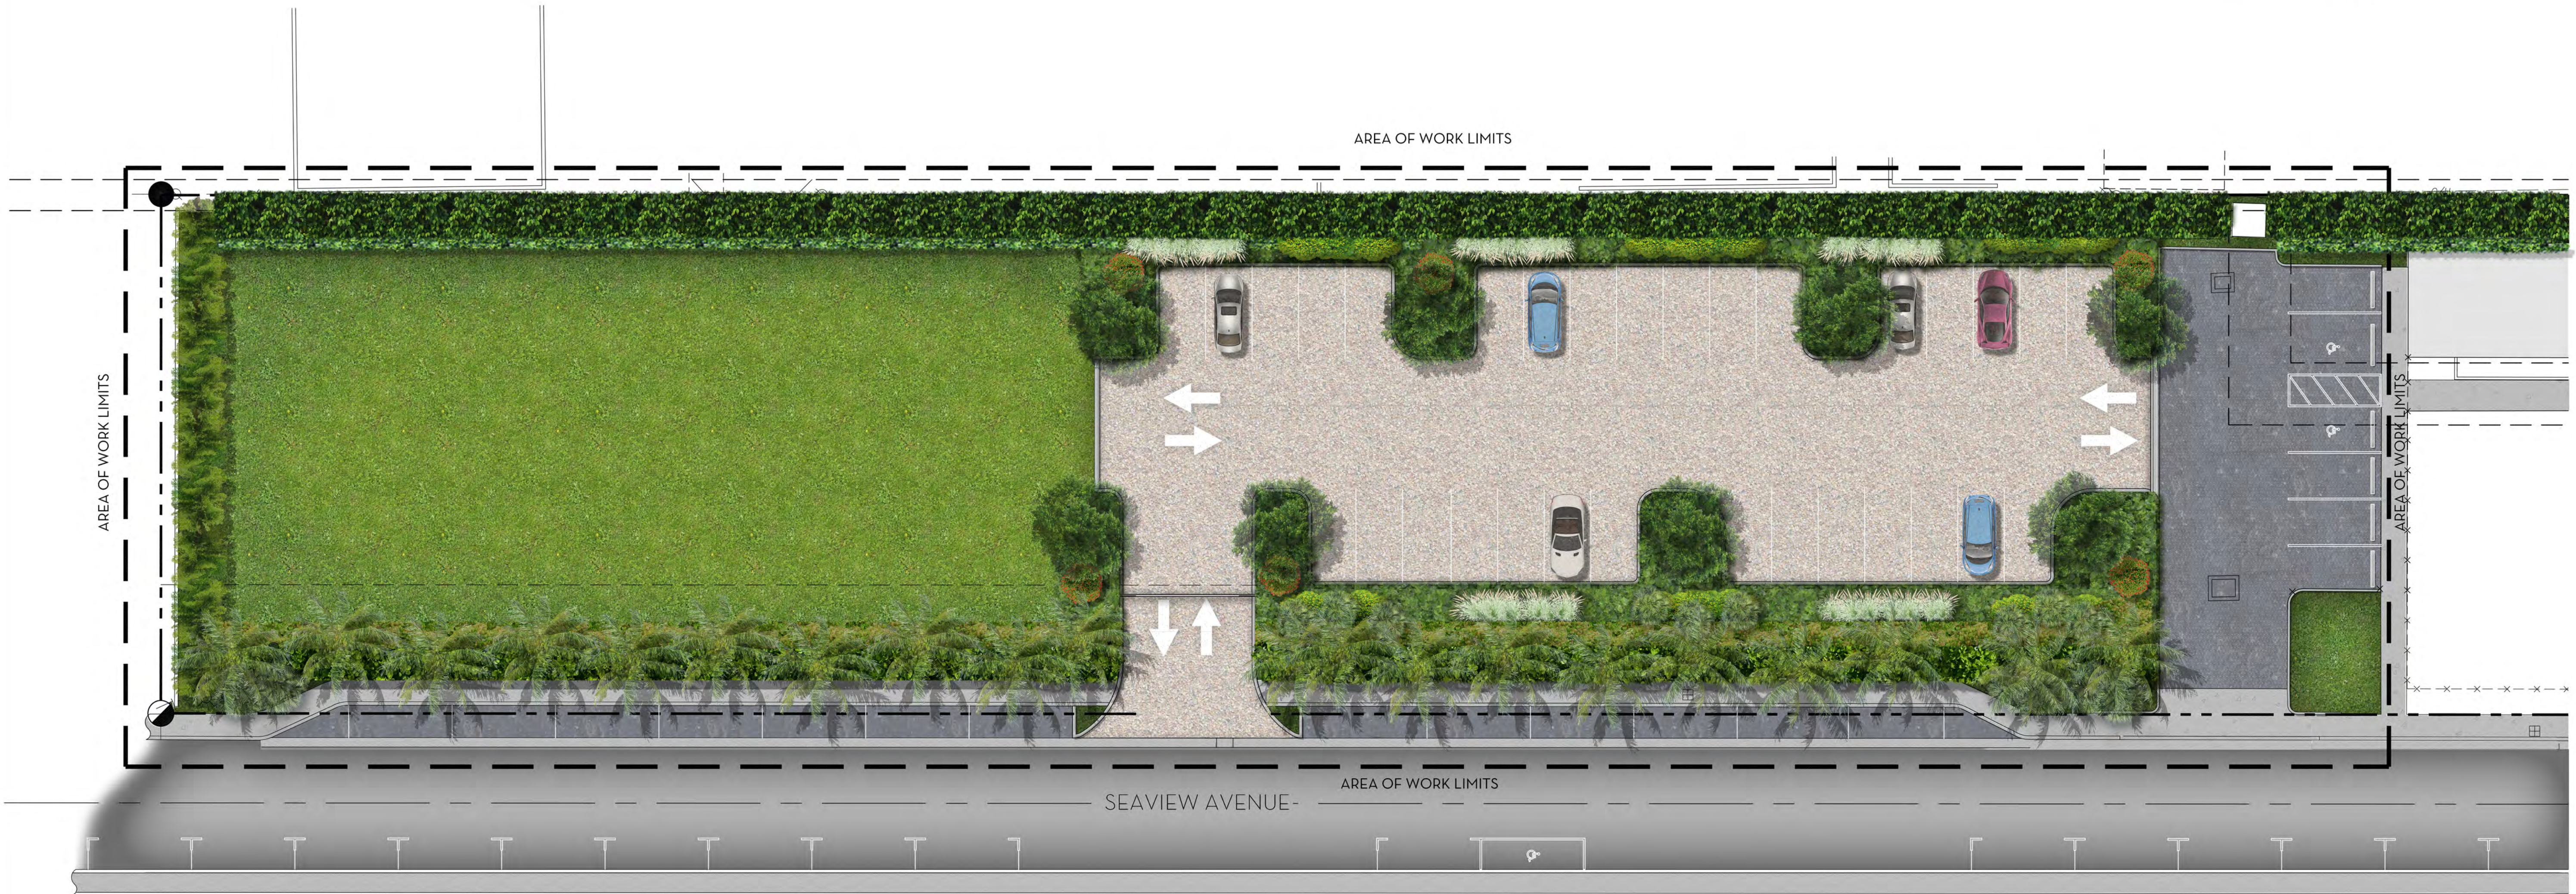

***CURRENTLY PROPOSED**

OVERALL R-B SITE CALCULATIONS:

SITE AREA = 113,168 SQ FT 100%

MINIMUM LANDSCAPE: REQUIRED = 54,584 SQ FT 50%

EXISTING = 68,151 SQ FT 60.2%

PROPOSED = 56,505 SQ FT 49.9%

FRONT SETBACK SITE CALCULATIONS:

25' SETBACK AREA = 28,119 SQ FT 100%

MINIMUM LANDSCAPE: REQUIRED = 11,247 SQ FT 40%

EXISTING = 17,203 SQ FT 61.2%

PROPOSED = 16,851 SQ FT 59.9%

MARIO F. NIEVERA


State of Florida
Landscape Architect
Registration No.
6666856

ILLUSTRATIVE LANDSCAPE PLAN (Option 1)

PBDA PARKING LOT

241 SEAVIEW AVENUE, PALM BEACH, FLORIDA 33480

10 JUN 2022
08 APR 2022
28 MAR 2022
07 MAR 2022
22 FEB 2022

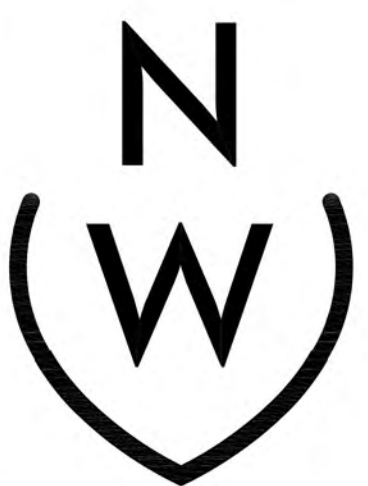

NIEVERA WILLIAMS
DESIGN


625 N. Flagler Drive
Suite 502
West Palm Beach, FL 33401
P: 561-659-2820
F: 561-659-2113


NIEVERAWILLIAMS.COM

COA-22-026 | ZON-22-070

LPO

SCALE: 1/16" = 1'-0"

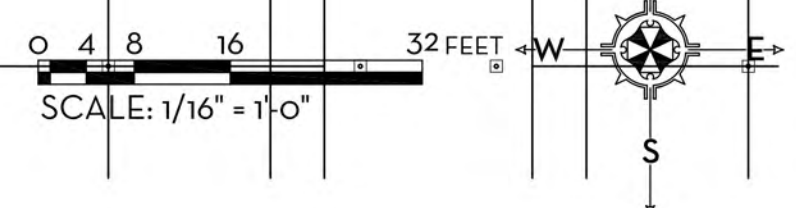

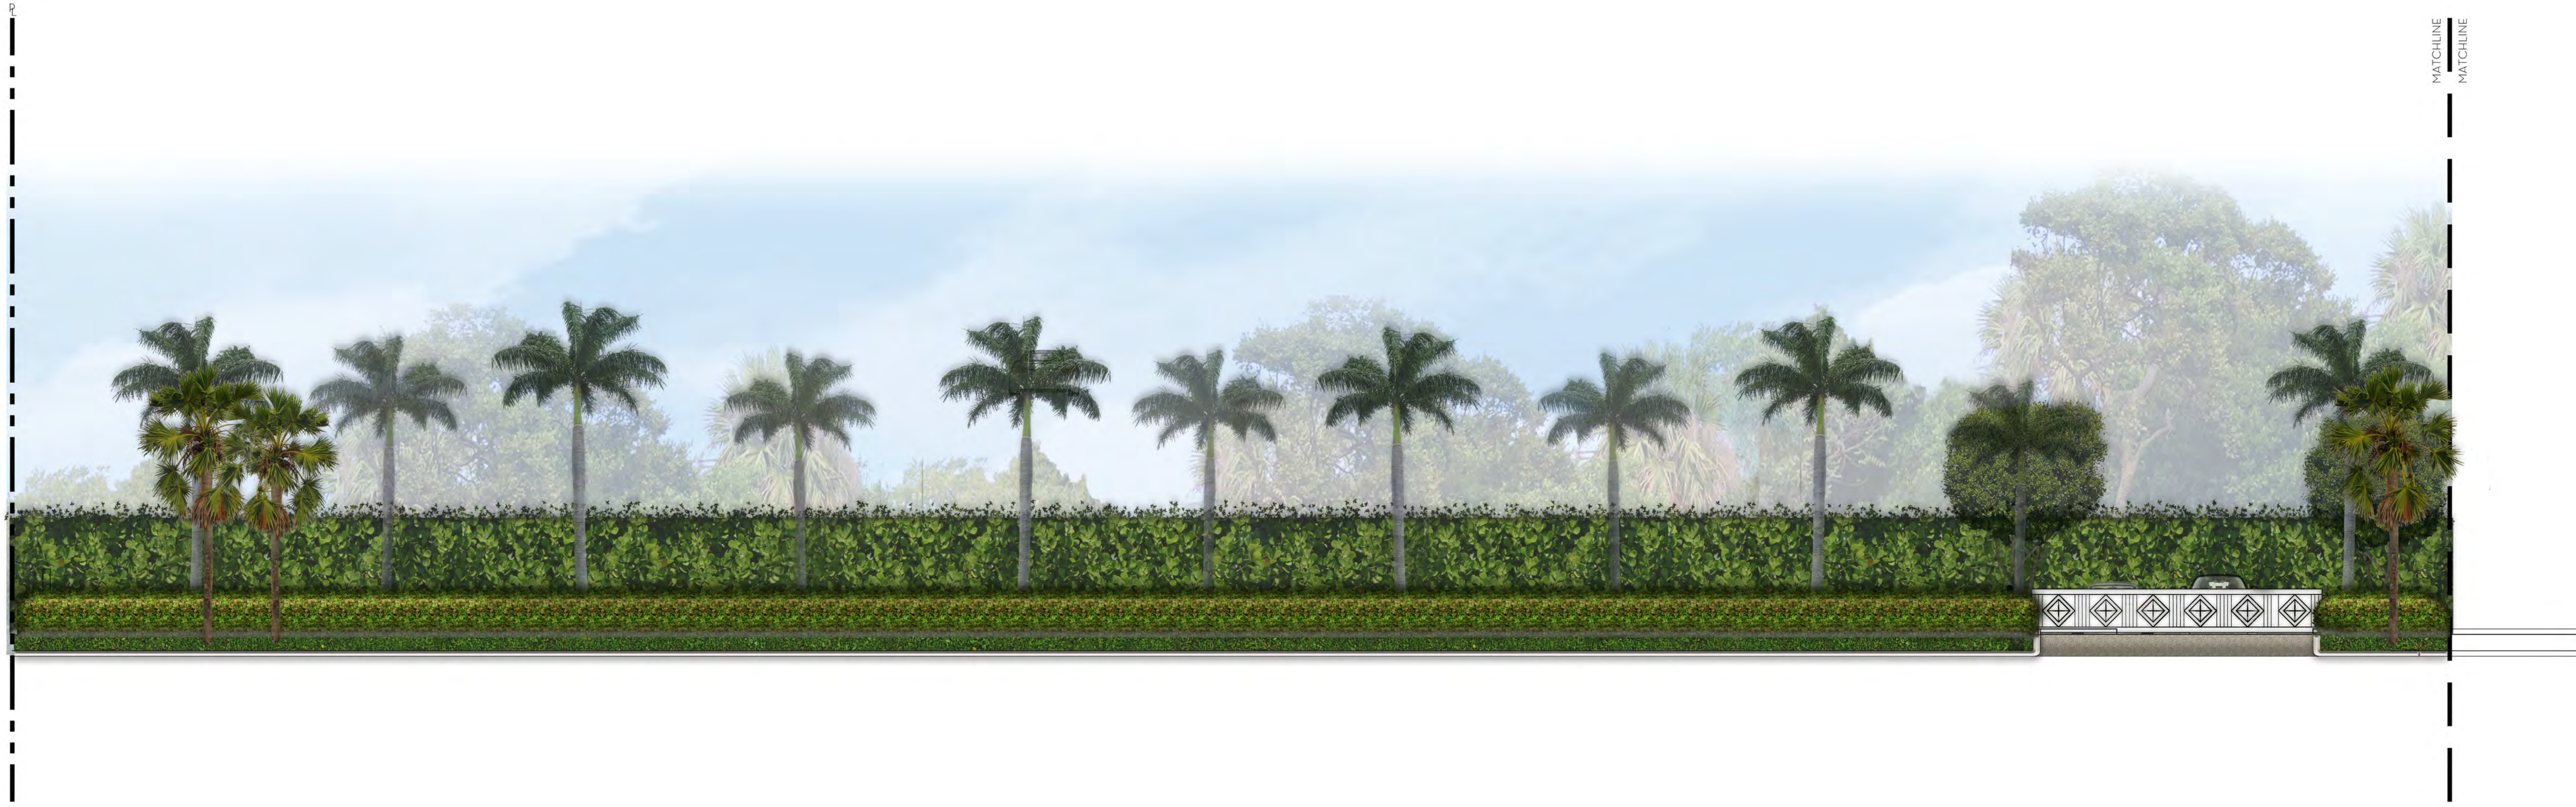


***CURRENTLY PROPOSED**

0 1 4 8 16 FEET
SCALE: 1/8" = 1'-0"

MARIO F. NIEVERA
State of Florida
Landscape Architect
Registration No.
6666856

ELEVATION OPTION 1
PBDA PARKING LOT
241 SEAVIEW AVENUE, PALM BEACH, FLORIDA 33480

08 APR 2022
28 MAR 2022
07 MAR 2022
22 FEB 2022

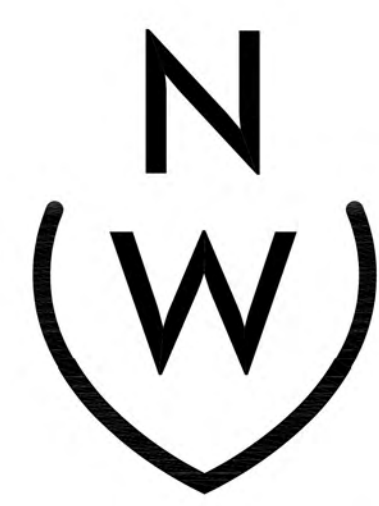

NIEVERA WILLIAMS
DESIGN

625 N. Flagler Drive
Suite 502
West Palm Beach, FL 33401
P: 561-659-2820
F: 561-659-2113

NIEVERAWILLIAMS.COM

COA-22-026 | ZON-22-070

EL1

SCALE: 1/8" = 1'-0"



1
S1 SITE SECTION OPTION 1
SCALE: 1/8"=1'-0"



2
S1 SITE SECTION OPTION 2
SCALE: 1/8"=1'-0"

***CURRENTLY PROPOSED**

0 1 4 8 16 FEET
SCALE: 1/8" = 1'-0"

MARIO F. NIEVERA


State of Florida
Landscape Architect
Registration No.
6666856

SITE SECTION OPTIONS
PBDA PARKING LOT

241 SEAVIEW AVENUE, PALM BEACH, FLORIDA 33480

SCALE: 1/8" = 1'-0"

08 APR 2022
28 MAR 2022
07 MAR 2022
22 FEB 2022

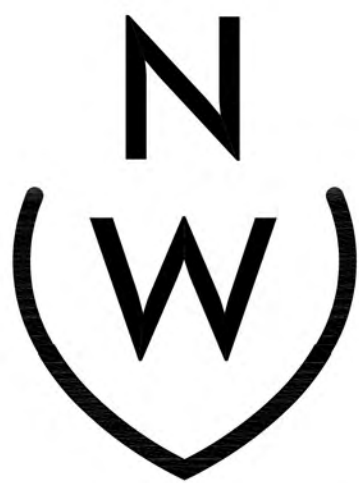

NIEVERA WILLIAMS
DESIGN

625 N. Flagler Drive
Suite 502
West Palm Beach, FL 33401
P: 561-659-2820
F: 561-659-2113

NIEVERAWILLIAMS.COM

COA-22-026 | ZON-22-070

S1



1
IM1
DECORATIVE CONCRETE



2
IM1
CRUSHED COQUINA GRAVEL (FINE)



2
IM1
CRUSHED COQUINA GRAVEL (COARSE)



4
IM1
WOOD PARKING BUMPERS



5
IM1
AZEK FENCING



6
IM1
TURF BLOCK PAVER w/ GRAVEL



7
IM1
TURF BLOCK PAVER w/ GRAVEL

*CURRENTLY PROPOSED


MARIO F. NIEVERA

State of Florida
Landscape Architect
Registration No.
6666856

HARDSCAPE MATERIAL IMAGES
PBDA PARKING LOT

241 SEAVIEW AVENUE, PALM BEACH, FLORIDA 33480

10 JUN 2022
08 APR 2022
28 MAR 2022
07 MAR 2022
22 FEB 2022

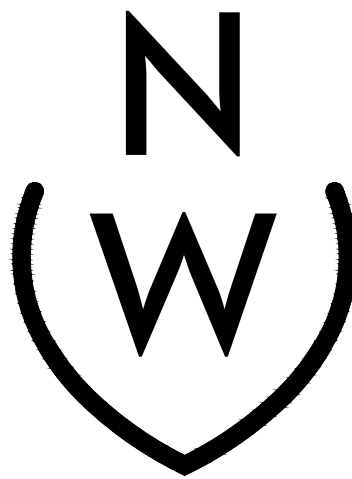

NIEVERA WILLIAMS
DESIGN

625 N. Flagler Drive
Suite 502
West Palm Beach, FL 33401
P: 561-659-2820
F: 561-659-2113

NIEVERAWILLIAMS.COM

COA-22-026 | ZON-22-070

IM1

SCALE: SEE DETAIL

MARIO F. NIEVERA

State of Florida
Landscape Architect
Registration No.
6666856

*CURRENTLY PROPOSED

OVERALL R-B SITE CALCULATIONS:

SITE AREA = 113,168 SQ FT 100%

MINIMUM LANDSCAPE:


REQUIRED = 56,584 SQ FT 50%
EXISTING = 68,151 SQ FT 60.2%
PROPOSED = 56,426 SQ FT 49.86%

FRONT SETBACK SITE CALCULATIONS:

25' SETBACK AREA = 28,119 SQ FT 100%

MINIMUM LANDSCAPE:


REQUIRED = 11,247 SQ FT 40%
EXISTING = 17,203 SQ FT 61.2%
PROPOSED = 16,851 SQ FT 59.9%

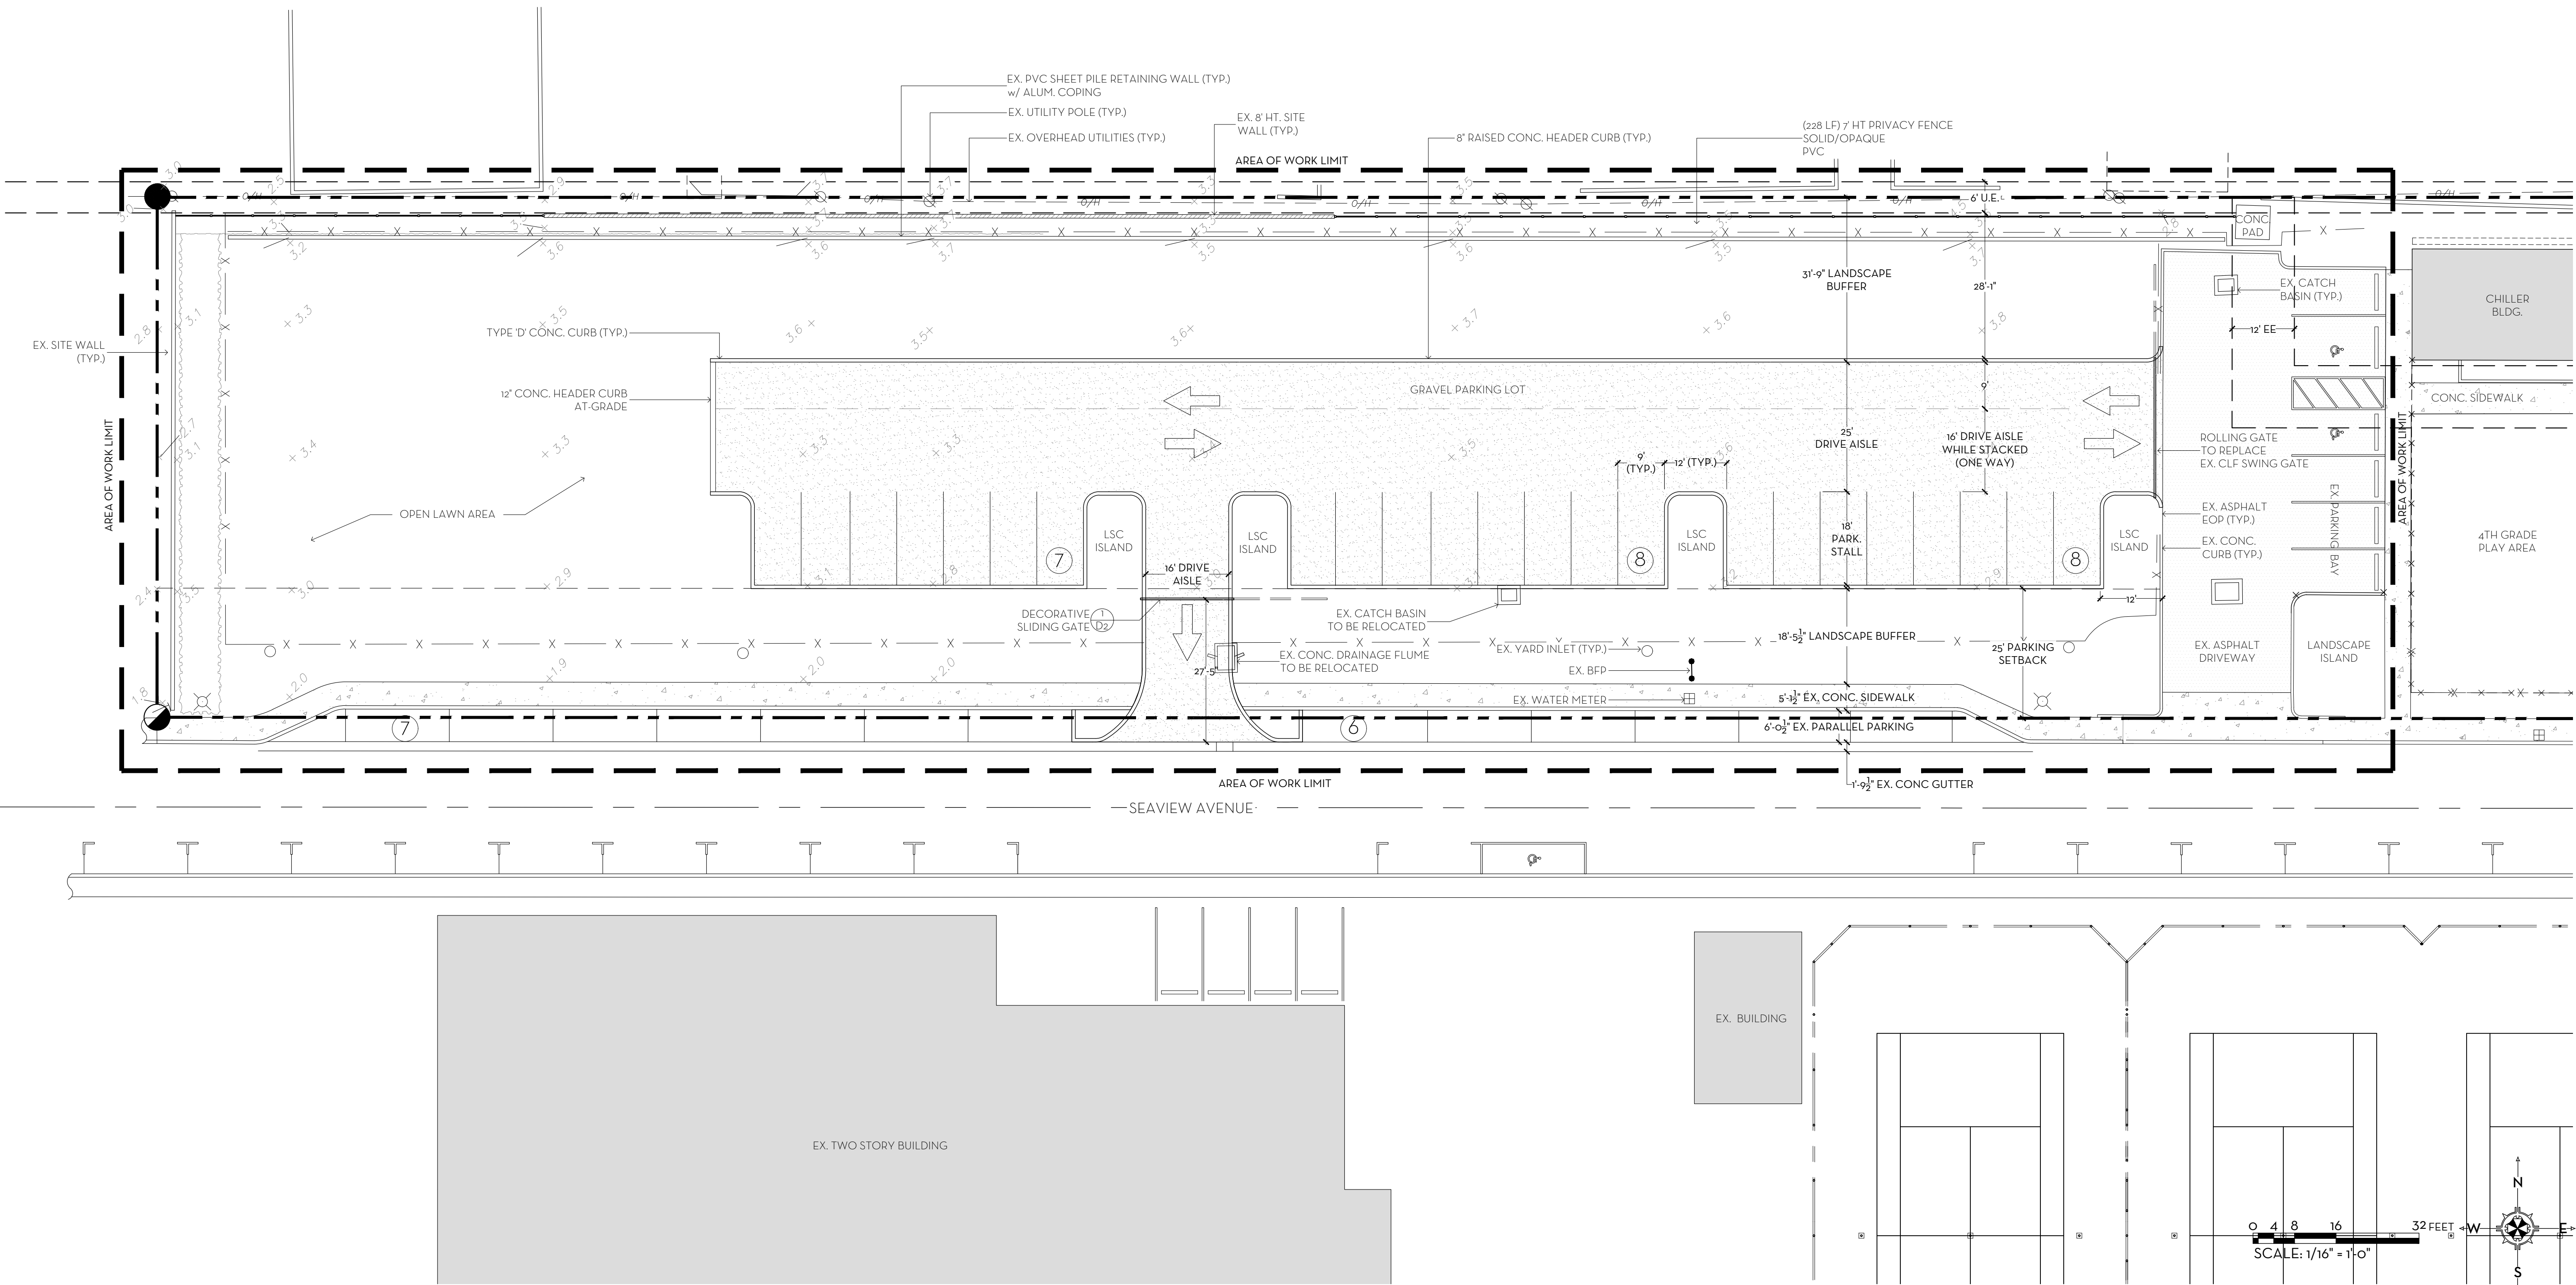

SITE PLAN (Option 2)
PBDA PARKING LOT

241 SEAVIEW AVENUE, PALM BEACH, FLORIDA 33480

10 JUN 2022
08 APR 2022
28 MAR 2022
07 MAR 2022
22 FEB 2022

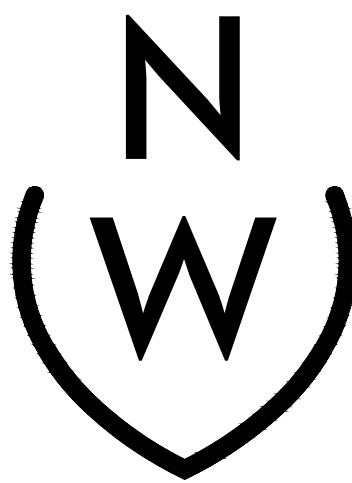


NIEVERA WILLIAMS
DESIGN


625 N. Flagler Drive
Suite 502
West Palm Beach, FL 33401
P: 561-659-2820
F: 561-659-2113

NIEVERAWILLIAMS.COM

COA-22-026 | ZON-22-070

 

SCALE: 1/16" = 1'-0"

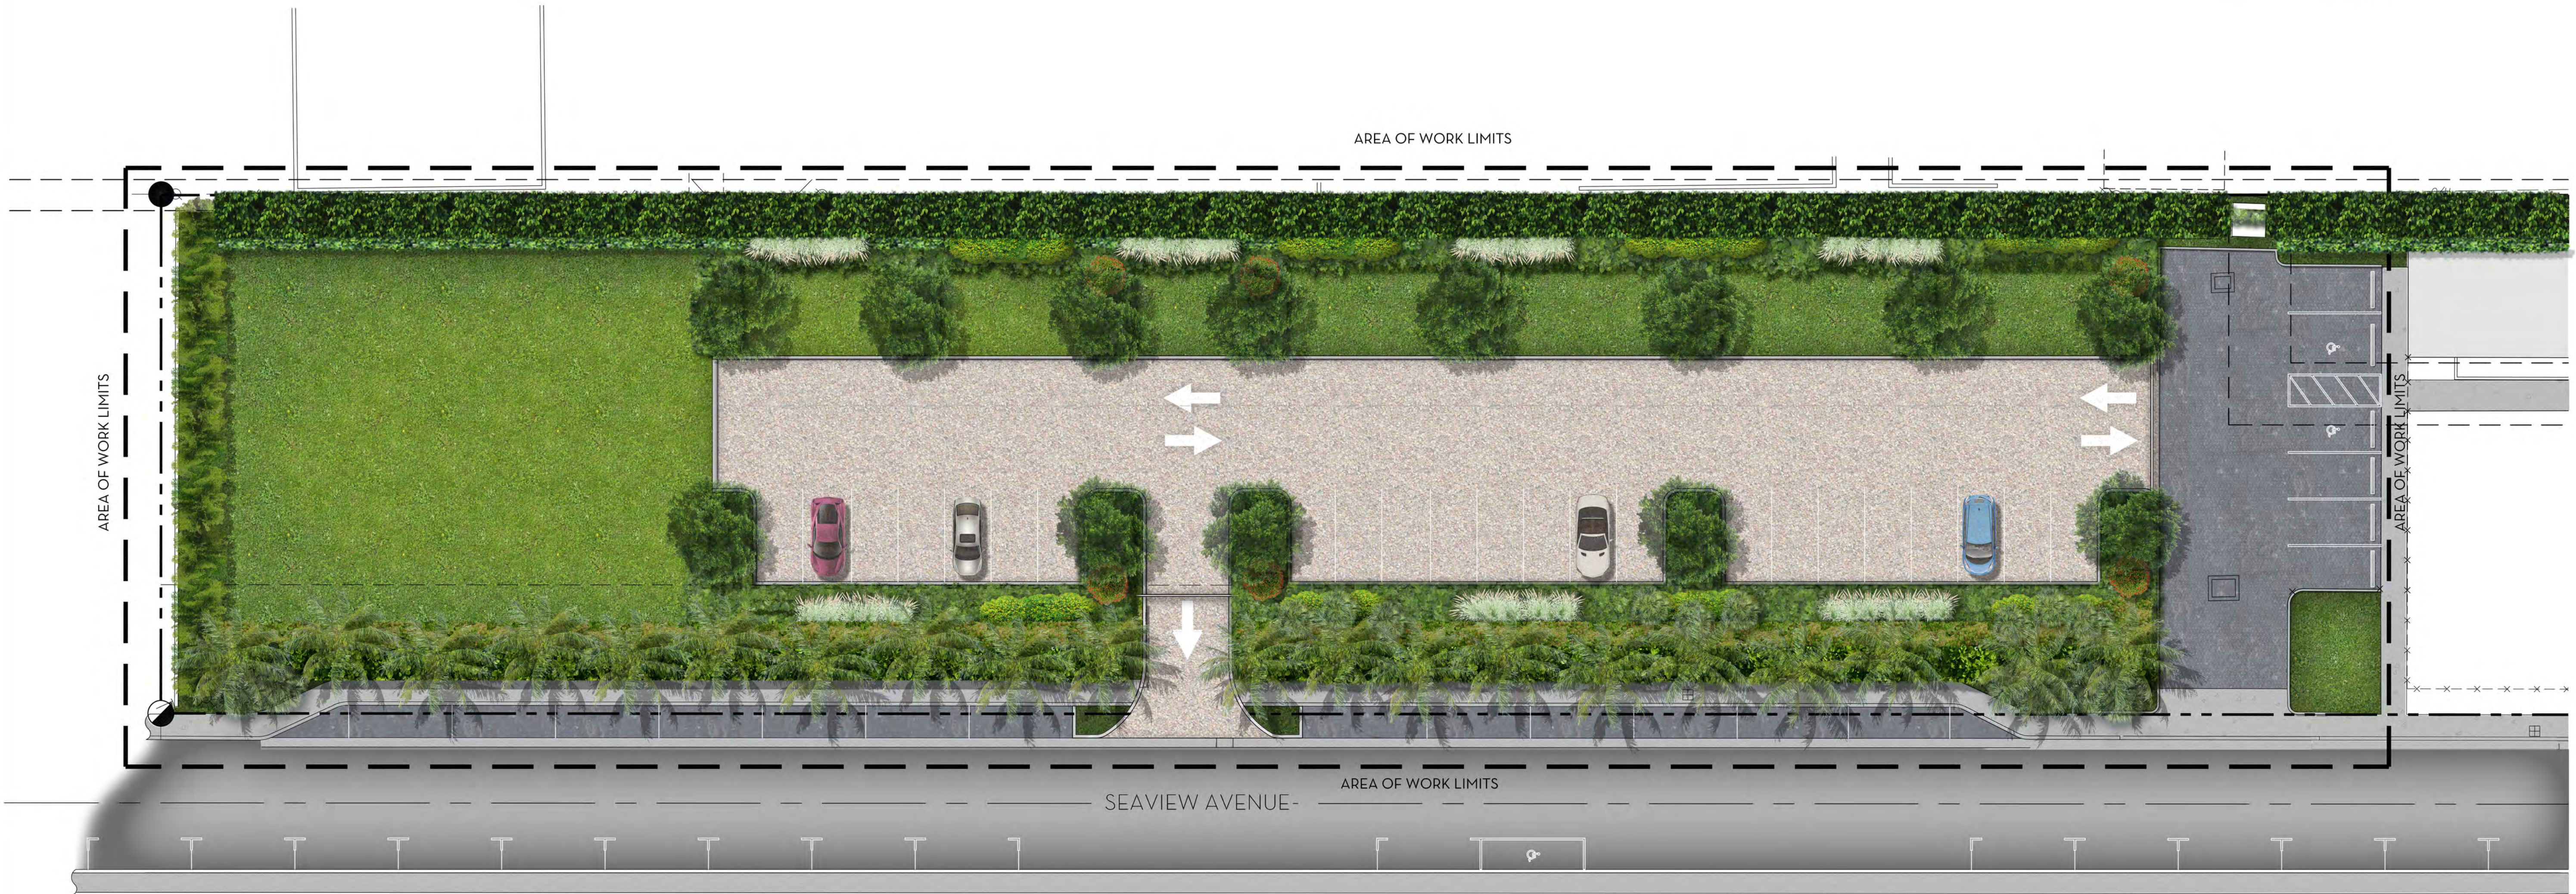

***CURRENTLY PROPOSED**

OVERALL R-B SITE CALCULATIONS:

SITE AREA =	113,168	SQ FT	100%
MINIMUM LANDSCAPE:			
REQUIRED =	54,584	SQ FT	50%
EXISTING =	68,151	SQ FT	60.2%
PROPOSED =	56,426	SQ FT	49.86%

FRONT SETBACK SITE CALCULATIONS:

25' SETBACK AREA =	28,119	SQ FT	100%
MINIMUM LANDSCAPE:			
REQUIRED =	11,247	SQ FT	40%
EXISTING =	17,203	SQ FT	61.2%
PROPOSED =	16,851	SQ FT	59.9%


AREA OF WORK LIMITS

AREA OF WORK LIMITS

SEAVIEW AVENUE

AREA OF WORK LIMITS

AREA OF WORK LIMITS

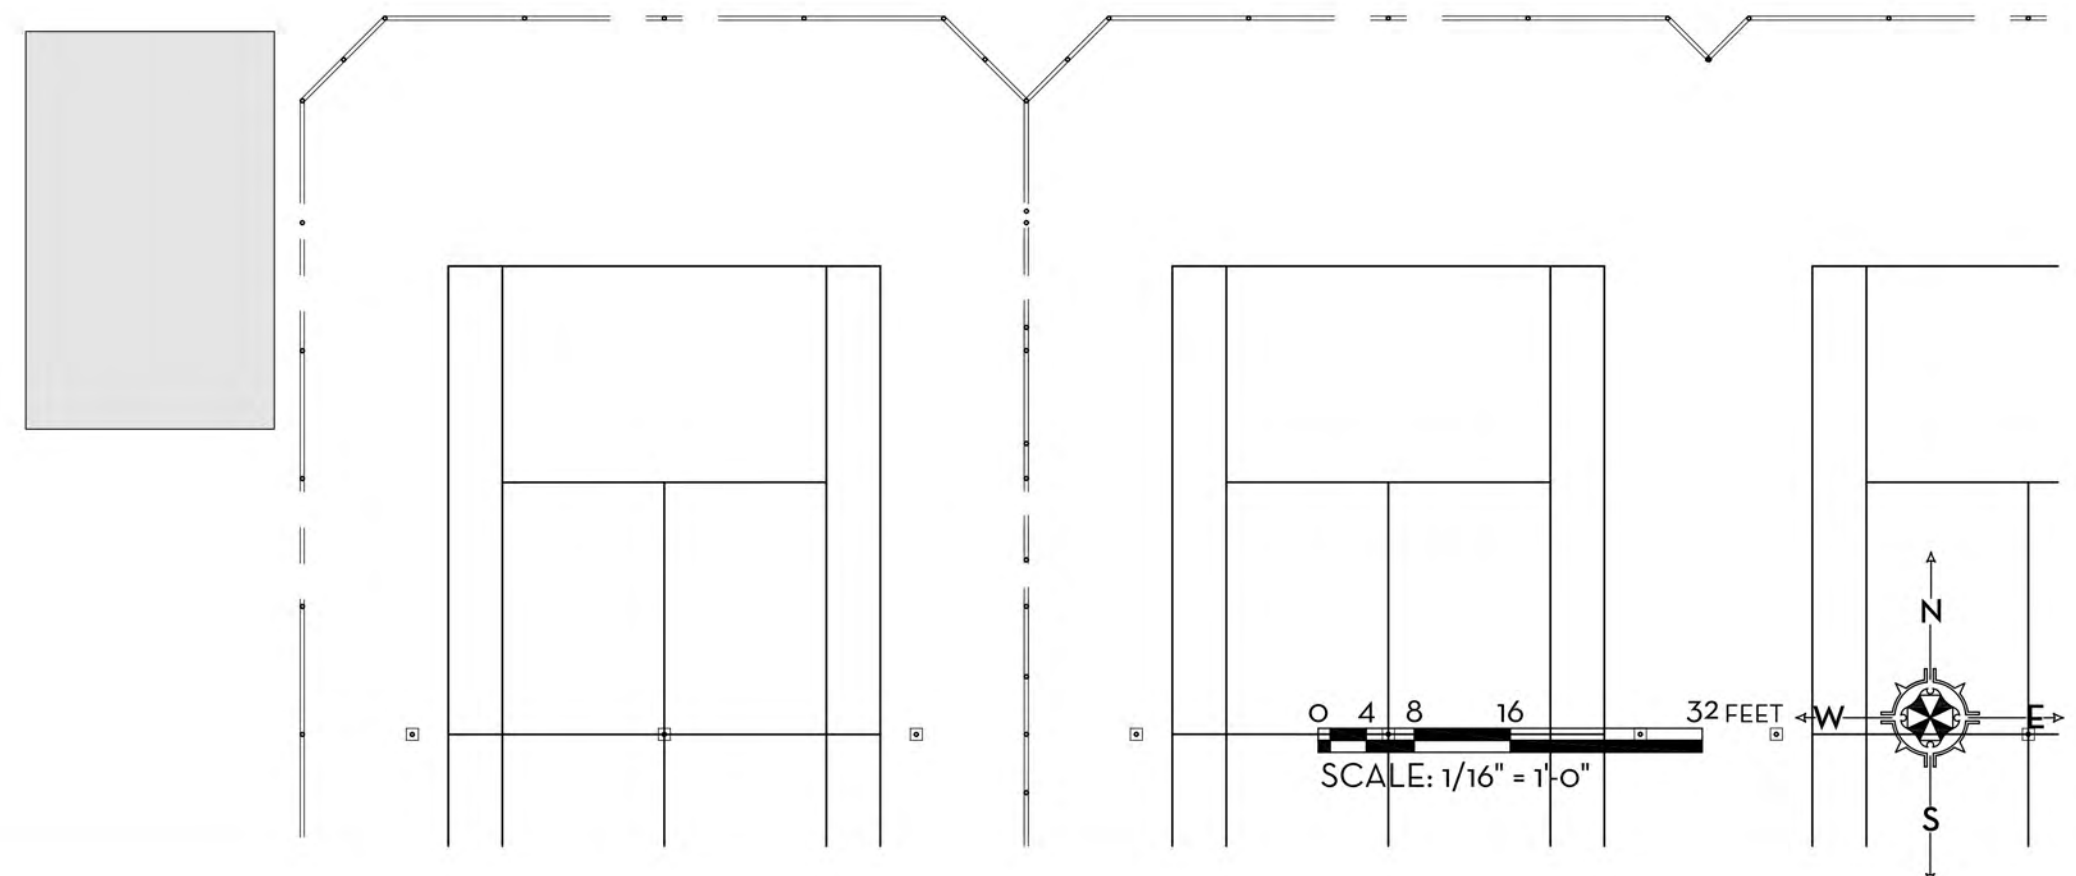

MARIO F. NIEVERA

State of Florida
Landscape Architect
Registration No.
6666856

ILLUSTRATIVE LANDSCAPE PLAN (Option2)

PBDA PARKING LOT

241 SEAVIEW AVENUE, PALM BEACH, FLORIDA 33480

10 JUN 2022
08 APR 2022
28 MAR 2022
07 MAR 2022
22 FEB 2022



NIEVERA WILLIAMS
DESIGN


625 N. Flagler Drive
Suite 502
West Palm Beach, FL 33401
P: 561-659-2820
F: 561-659-2113

NIEVERAWILLIAMS.COM

COA-22-026 | ZON-22-070

LPO

SCALE: 1/16" = 1'-0"

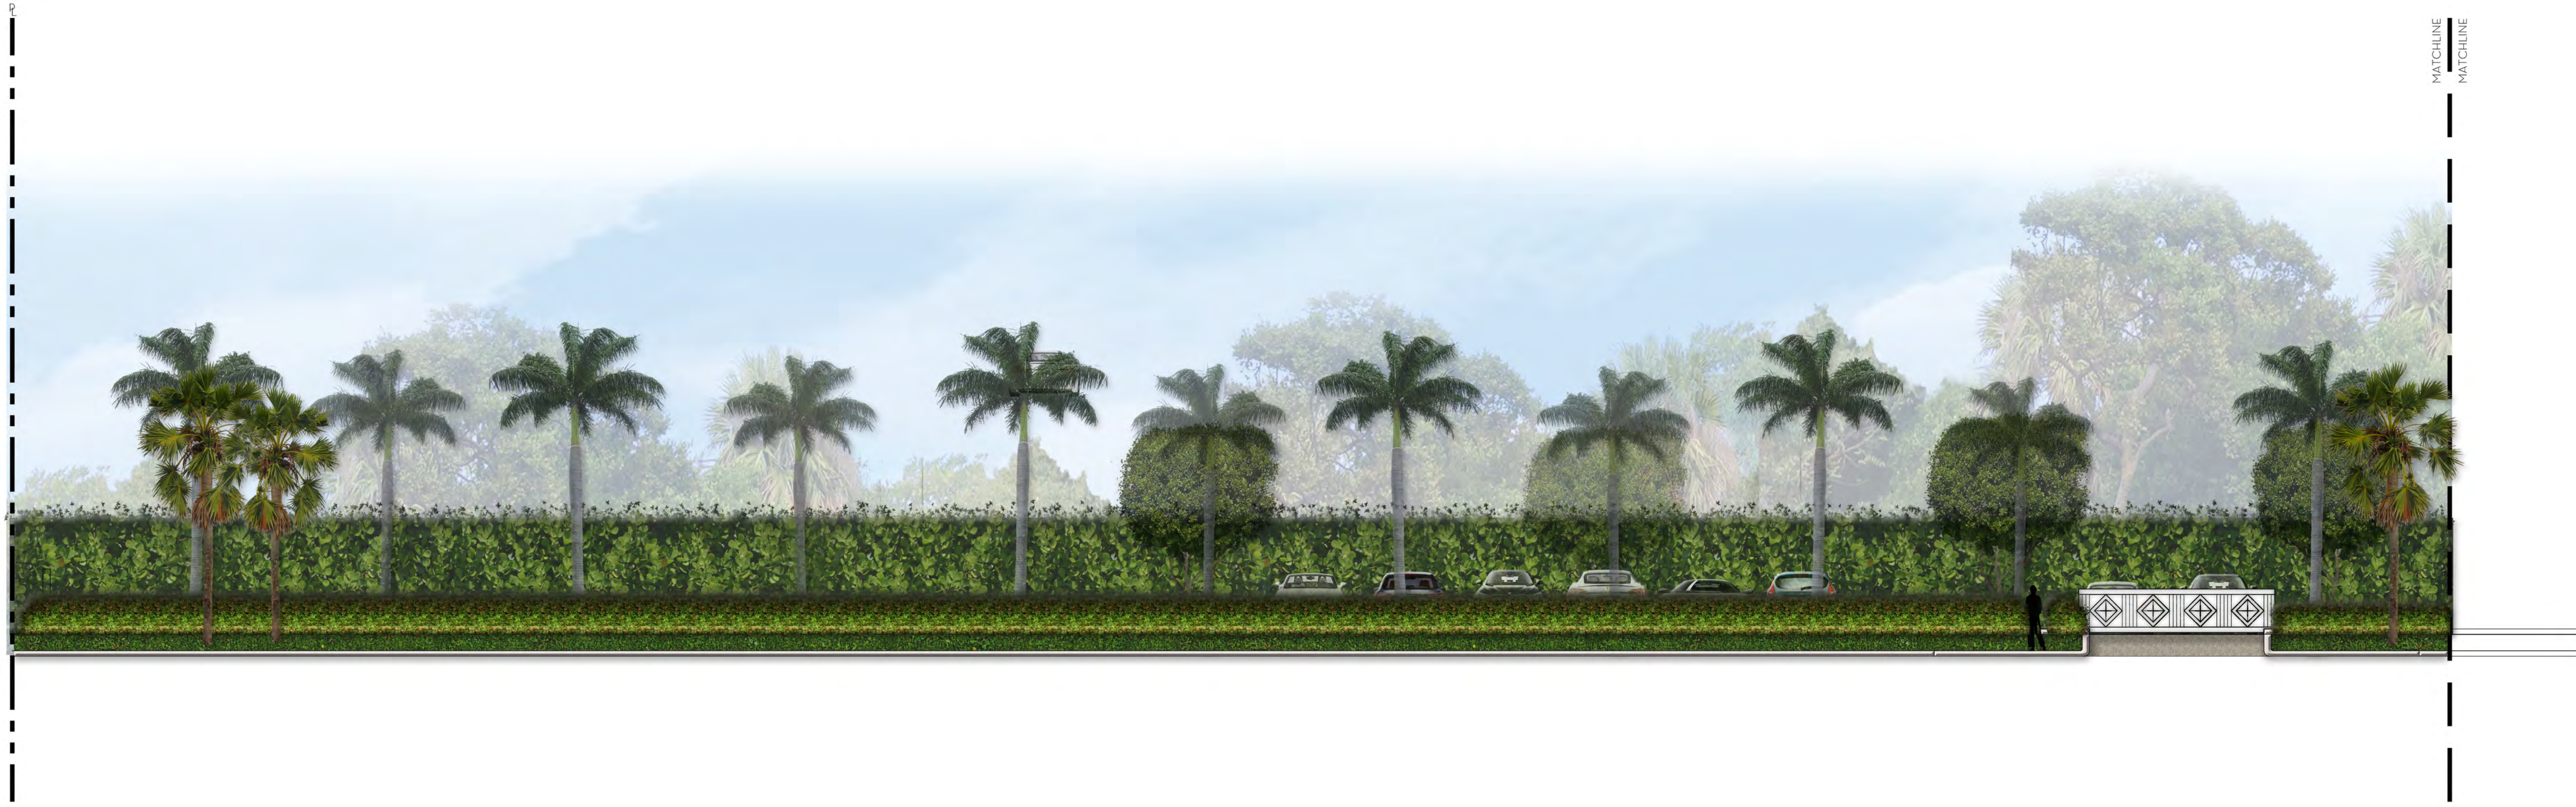

***CURRENTLY PROPOSED**


0 1 4 8 16 FEET
SCALE: 1/8" = 1'-0"

MARIO F. NIEVERA
State of Florida
Landscape Architect
Registration No.
6666856

ELEVATION OPTION 2
PBDA PARKING LOT
241 SEAVIEW AVENUE, PALM BEACH, FLORIDA 33480

SCALE: 1/8" = 1'-0"

08 APR 2022
28 MAR 2022
07 MAR 2022
22 FEB 2022

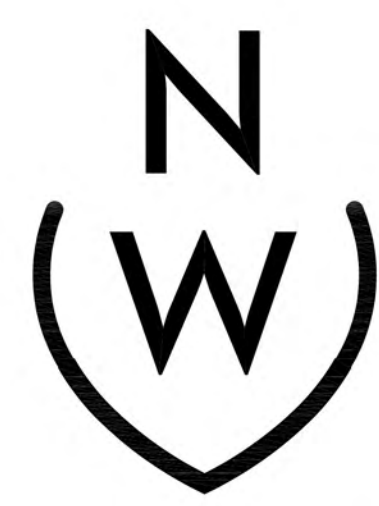

NIEVERA WILLIAMS
DESIGN

625 N. Flagler Drive
Suite 502
West Palm Beach, FL 33401
P: 561-659-2820
F: 561-659-2113

NIEVERAWILLIAMS.COM

COA-22-026 | ZON-22-070

EL1



1
S1 SITE SECTION OPTION 1
SCALE: 1/8"=1'-0"



2
S1 SITE SECTION OPTION 2
SCALE: 1/8"=1'-0"

***CURRENTLY PROPOSED**

0 1 4 8 16 FEET
SCALE: 1/8" = 1'-0"

MARIO F. NIEVERA


State of Florida
Landscape Architect
Registration No.
6666856

SITE SECTION OPTIONS
PBDA PARKING LOT

241 SEAVIEW AVENUE, PALM BEACH, FLORIDA 33480

SCALE: 1/8" = 1'-0"

08 APR 2022
28 MAR 2022
07 MAR 2022
22 FEB 2022

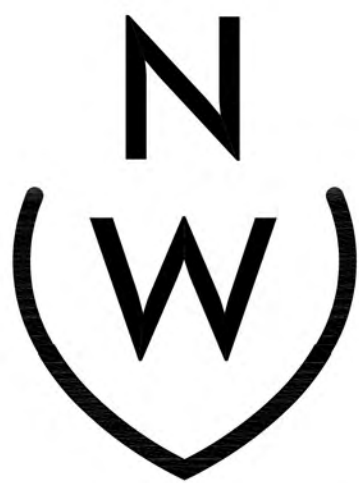

NIEVERA WILLIAMS
DESIGN

625 N. Flagler Drive
Suite 502
West Palm Beach, FL 33401
P: 561-659-2820
F: 561-659-2113

NIEVERAWILLIAMS.COM

COA-22-026 | ZON-22-070

S1