


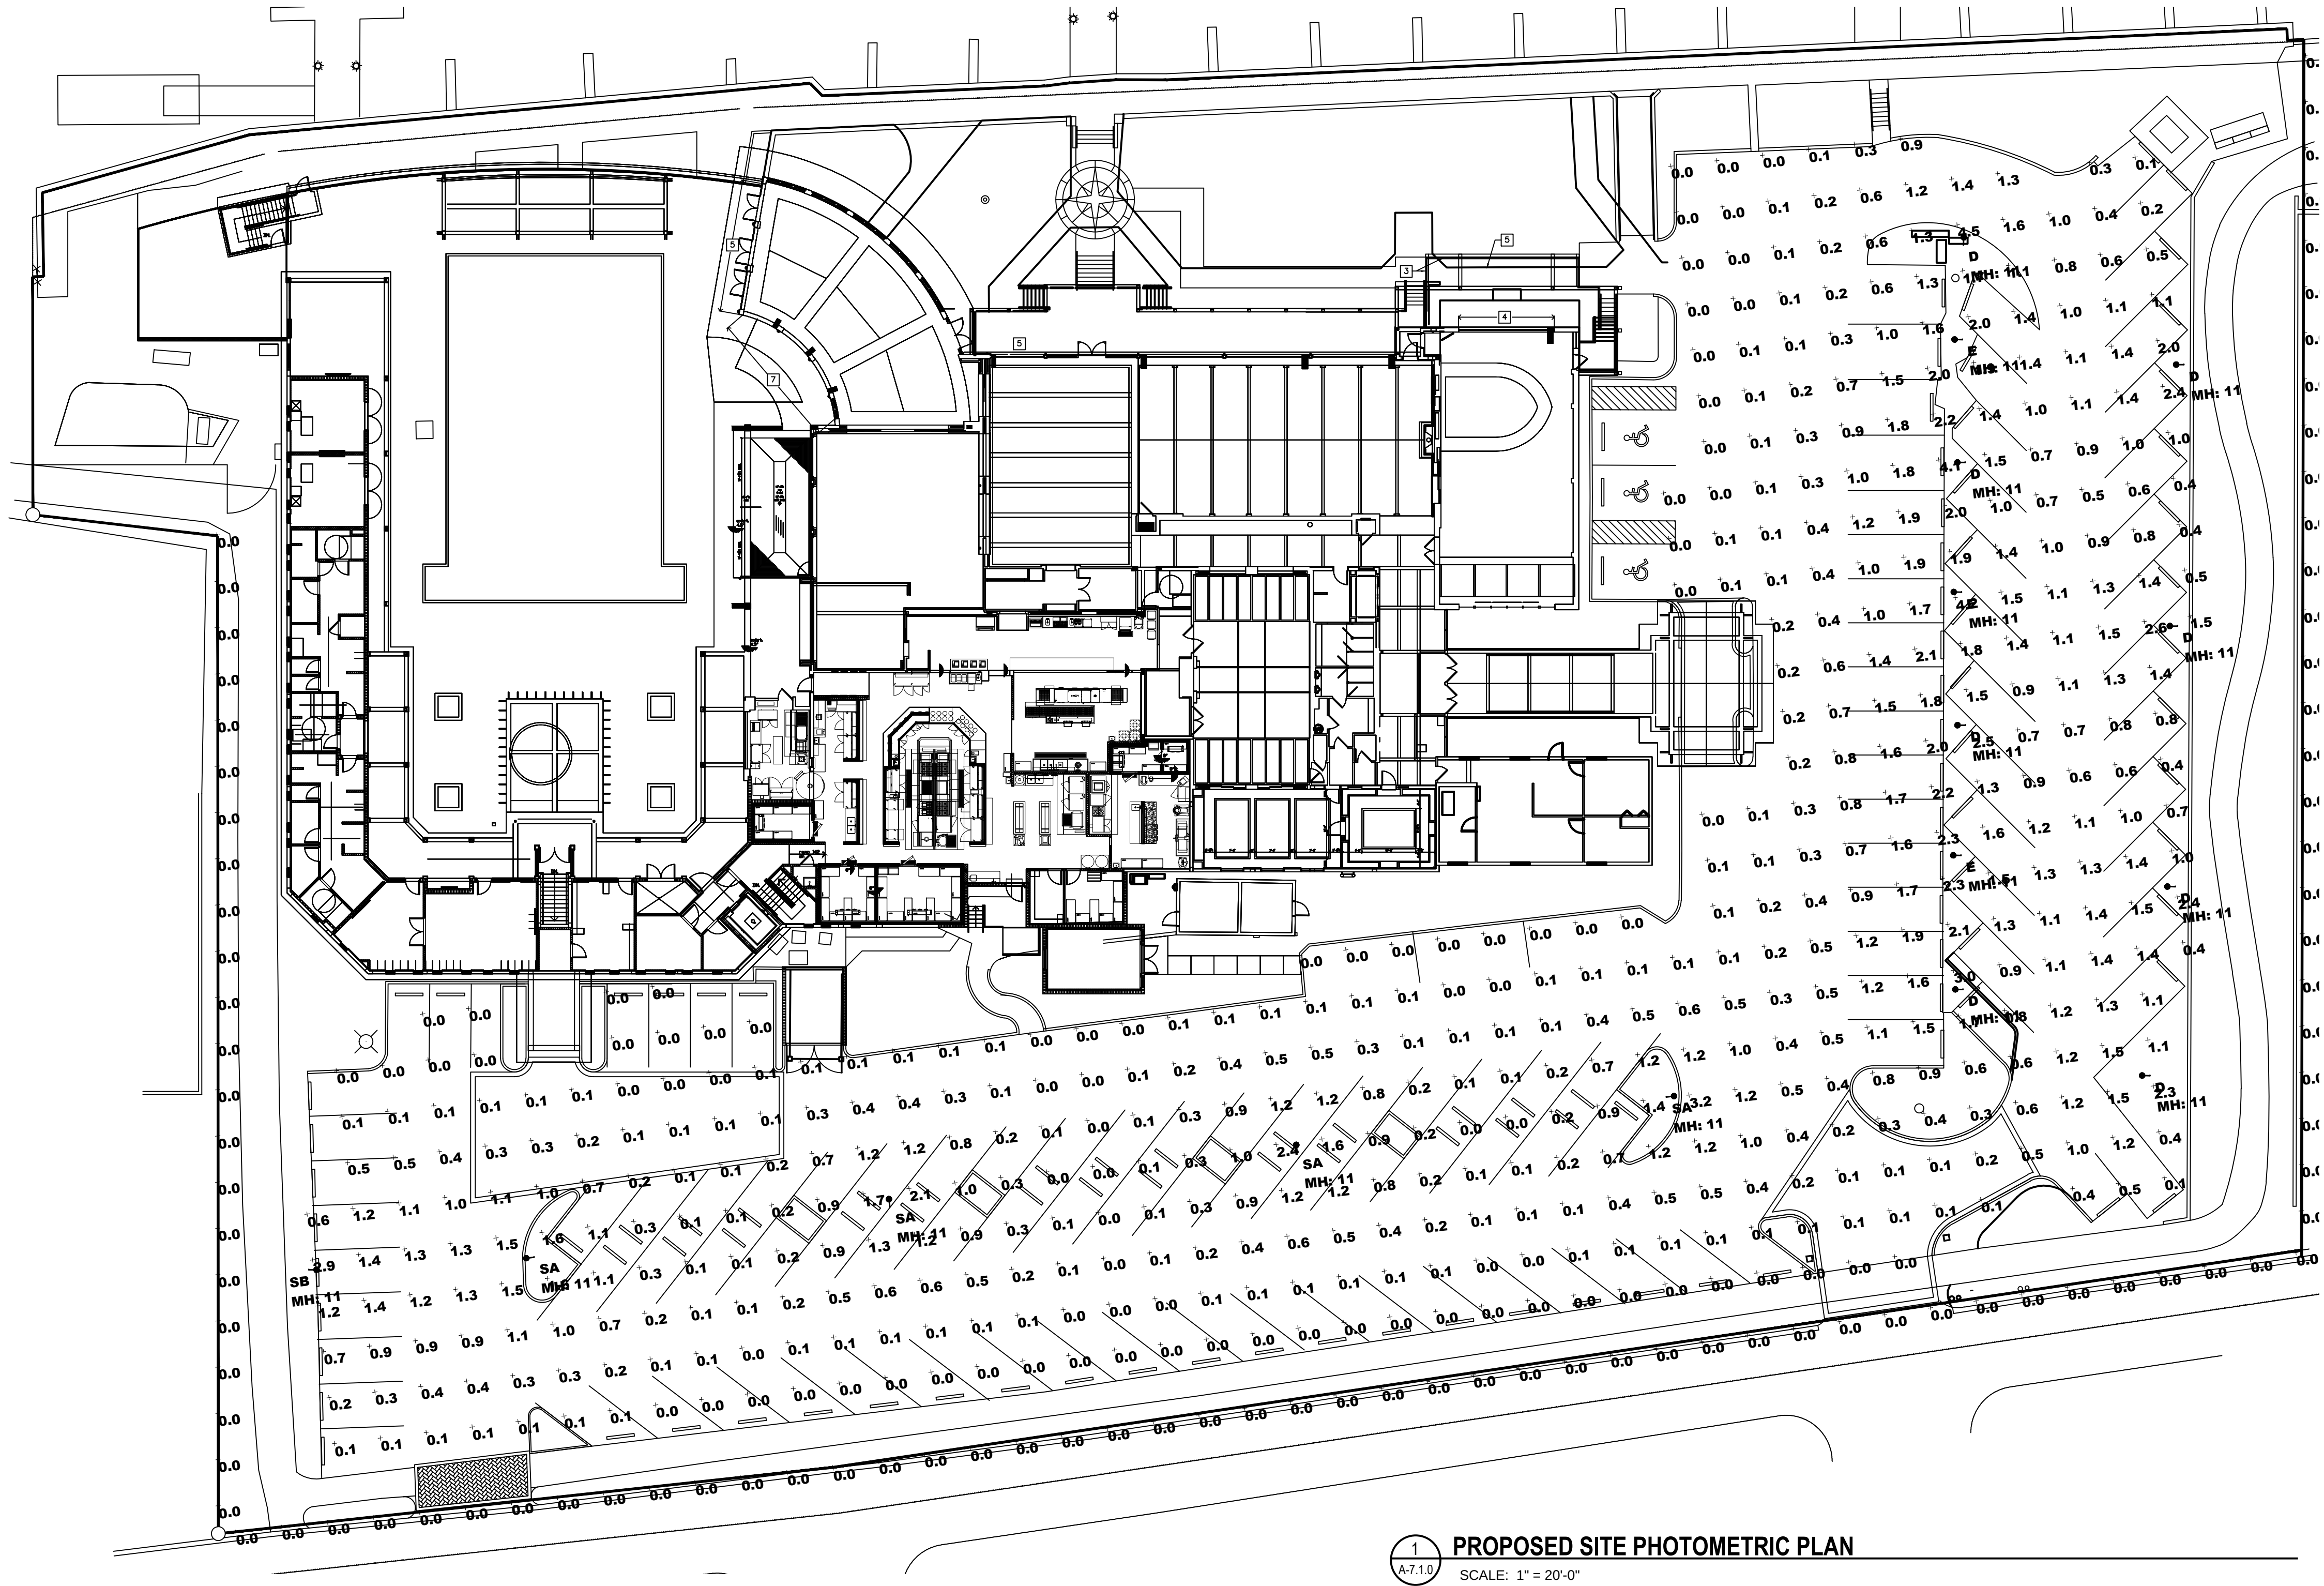

EXISTING SITE LIGHTING AT THE NORTH
PARKING AREA TO BE REPLACED WITH
NEW PROPOSED FIXTURE



PROPOSED SINGLE LIGHT POLE FIXTURE

Luminaire Schedule: SAILFISH CLUB OF FLORIDA INC. - SITE_REV 2 PALM BEACH, FL 07/20/22										
Symbol	Qty	Label	Arrangement	Manufacturer	Catalog Number	Mounting	LLF	Luminaire Lumens	Luminaire Watts	Arrangement Watts
	8	D	Single	U.S. Architectural Lighting	DSS30/VLED-IV/48LED-350mA/TRA/****/1/RAL***	POLE MOUNT A.F.G. (bottom of fixture)	0.855	2502	40.7	40.7
	3	E	Single	U.S. Architectural Lighting	DSS30/VLED-VSQ/48LED-350mA/TRA/****/1/RAL***	POLE MOUNT A.F.G. (bottom of fixture)	0.855	2624	40.7	40.7
	4	SA	Single	U.S. Architectural Lighting	DSS30/VLED-VSQ/48LED-350mA/TRA/****/1/RAL***	POLE MOUNT A.F.G. (bottom of fixture)	0.855	2624	40.7	40.7
	1	SB	Single	U.S. Architectural Lighting	DSS30/VLED-IV/48LED-350mA/TRA/****/1/RAL***	POLE MOUNT A.F.G. (bottom of fixture)	0.855	2502	40.7	40.7

Calculation Summary: SAILFISH CLUB OF FLORIDA INC. - SITE_REV 2 PALM BEACH, FL 07/20/2022							
Label	Calc Type	Units	Avg	Max	Min	Avg/Min	Max/Min
PARKING LOT BOTTOM	Illuminance	Fc	0.63	4.5	0.0	N.A.	N.A.
PROPERTY LINE SPILL	Illuminance	Fc	0.00	0.0	0.0	N.A.	N.A.

285 BANYAN BLVD
West Palm Beach Florida 33401
561.684.6844 • Fax 561.684.5594
spinaorourke.com
FL Lic # PA20002399

SPINAOROURKE

+ PARTNERS

Architecture • Interior Design
Keith M. Spina # ART13419

PROPOSED RENOVATIONS FOR:
SAILFISH CLUB OF FLORIDA

1338 NORTH LAKE WAY
PALM BEACH, FLORIDA 33480

THESE DRAWINGS ARE FOR THE EXCLUSIVE USE OF SPINA OROURKE + PARTNERS, INC. AND MAY NOT BE DUPLICATED, REPRODUCED OR USED IN ANY MANNER WITHOUT THE EXPRESS WRITTEN CONSENT OF SPINA OROURKE + PARTNERS, INC. ALL RIGHTS RESERVED

Revisions:
REV. 1 - 07-25-22

Project no: 21217
Date: 05-02-22
Drawn by: CLS/GAE
Project Architect: CLS

A-7.1.1
FINAL SUBMITTAL