




O'KEEFFE BUILDING

COVER

B-0.0.0

Second Submittal

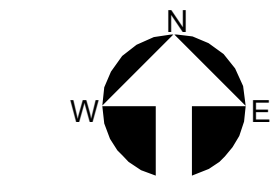

Project no: 2953
Date: 2024.09.23
Drawn by: Author
Project Manager: Checker

Revisions

THESE DRAWINGS ARE FOR THE EXCLUSIVE USE OF SPINA OROURKE + PARTNERS, INC. AND MAY NOT BE REPRODUCED, COPIED, OR USED IN ANY MANNER WITHOUT THE EXPRESS WRITTEN CONSENT OF SPINA OROURKE + PARTNERS, INC. ALL RIGHTS ARE RESERVED.

**The Society of the Four Arts -
Esther B. O'Keeffe Building**
100 Four Arts Plaza, Palm Beach, FL 33480




**SPINA OROURKE
+ PARTNERS**
Architecture • Interior Design
Keith M. Spina #

285 Banyan Blvd
West Palm Beach
FL 33407
spinaorourke.com
AA26002399


**BEYER
BLINDER
BELLE**

120 Broadway
20th Floor
New York, NY 10271
212.777.7800
beyerblinderbelle.com

VIEW FROM SOUTHWEST

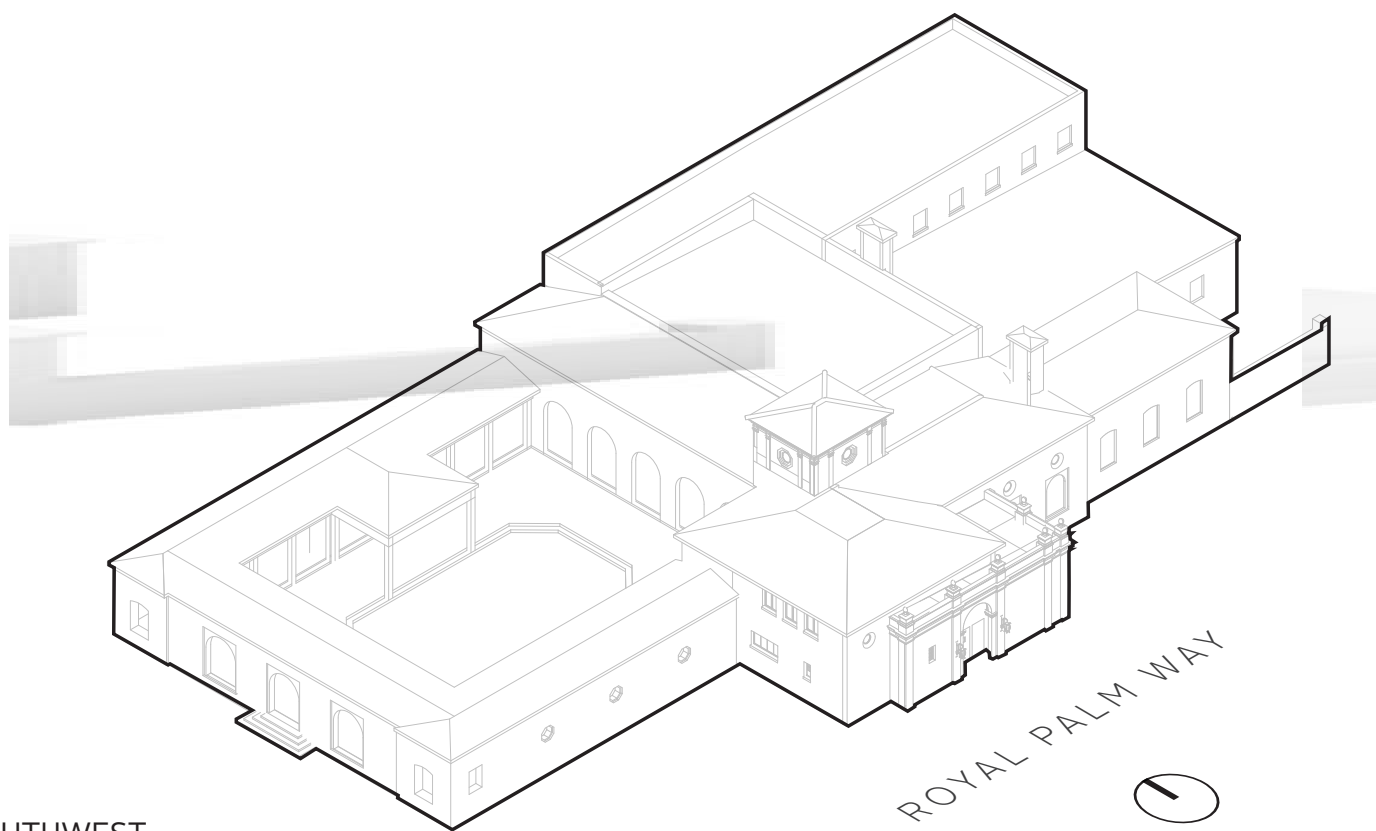

VIEW FROM NORTHEAST

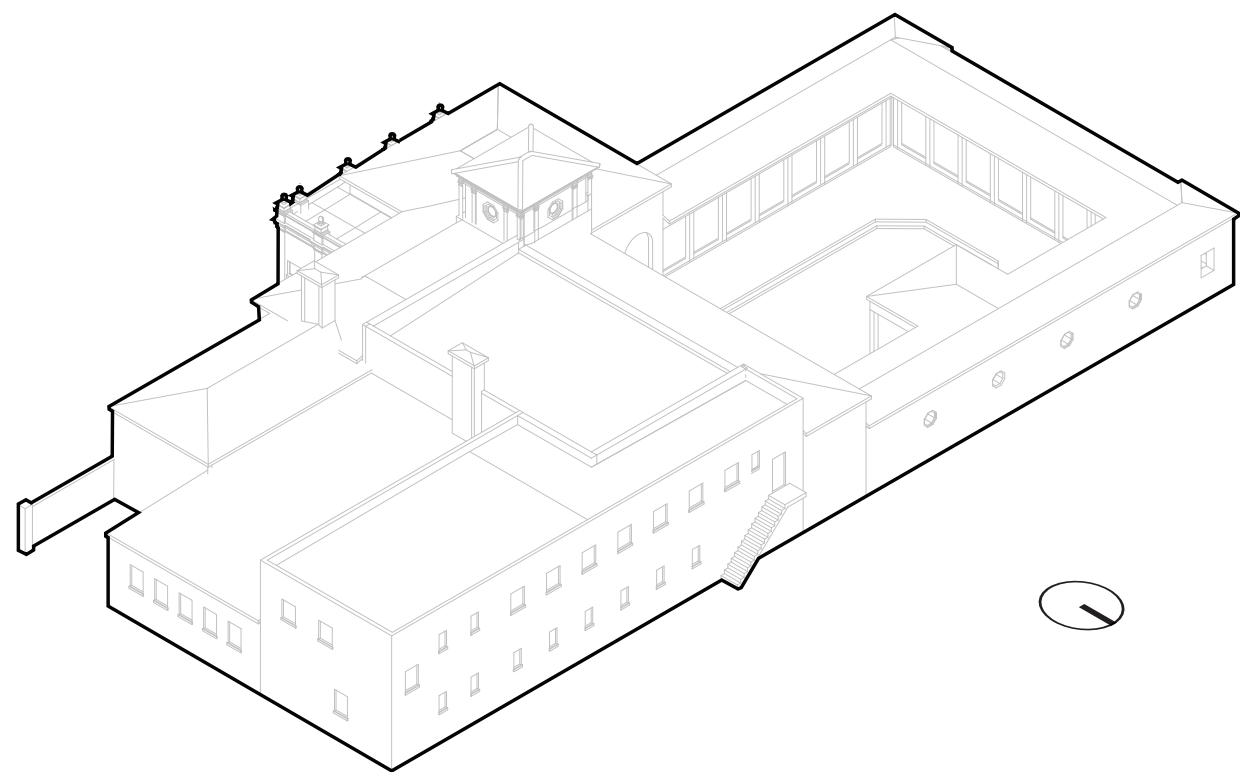

6 AXONOMETRIC DIAGRAMS OF BUILDING IN 1930
B-1.0.0 NTS - DRAWN BY BBB, 2023



3 PHOTO - CENTRAL LOGGIA, LOOKING NORTH, CIRCA 1930
B-1.0.0 NTS - COURTESY HISTORICAL SOCIETY OF PALM BEACH COUNTY



5 PHOTO - LOGGIA AND SOUTH CLOISTER FROM PATIO, CIRCA 1930
B-1.0.0 NTS - COURTESY HISTORICAL SOCIETY OF PALM BEACH COUNTY





2 PHOTO - LOUNGE LOOKING NORTH INTO DINING ROOM, CIRCA 1930
B-1.0.0 NTS - COURTESY HISTORICAL SOCIETY OF PALM BEACH COUNTY




8 PHOTO - AERIAL OF THE SITE FROM SOUTHWEST, CIRCA 1930
B-1.0.0 NTS - COURTESY HISTORICAL SOCIETY OF PALM BEACH COUNTY




4 PHOTO - SOUTH ELEVATION FROM ROYAL PALM WAY, CIRCA 1930
B-1.0.0 NTS - COURTESY HISTORICAL SOCIETY OF PALM BEACH COUNTY

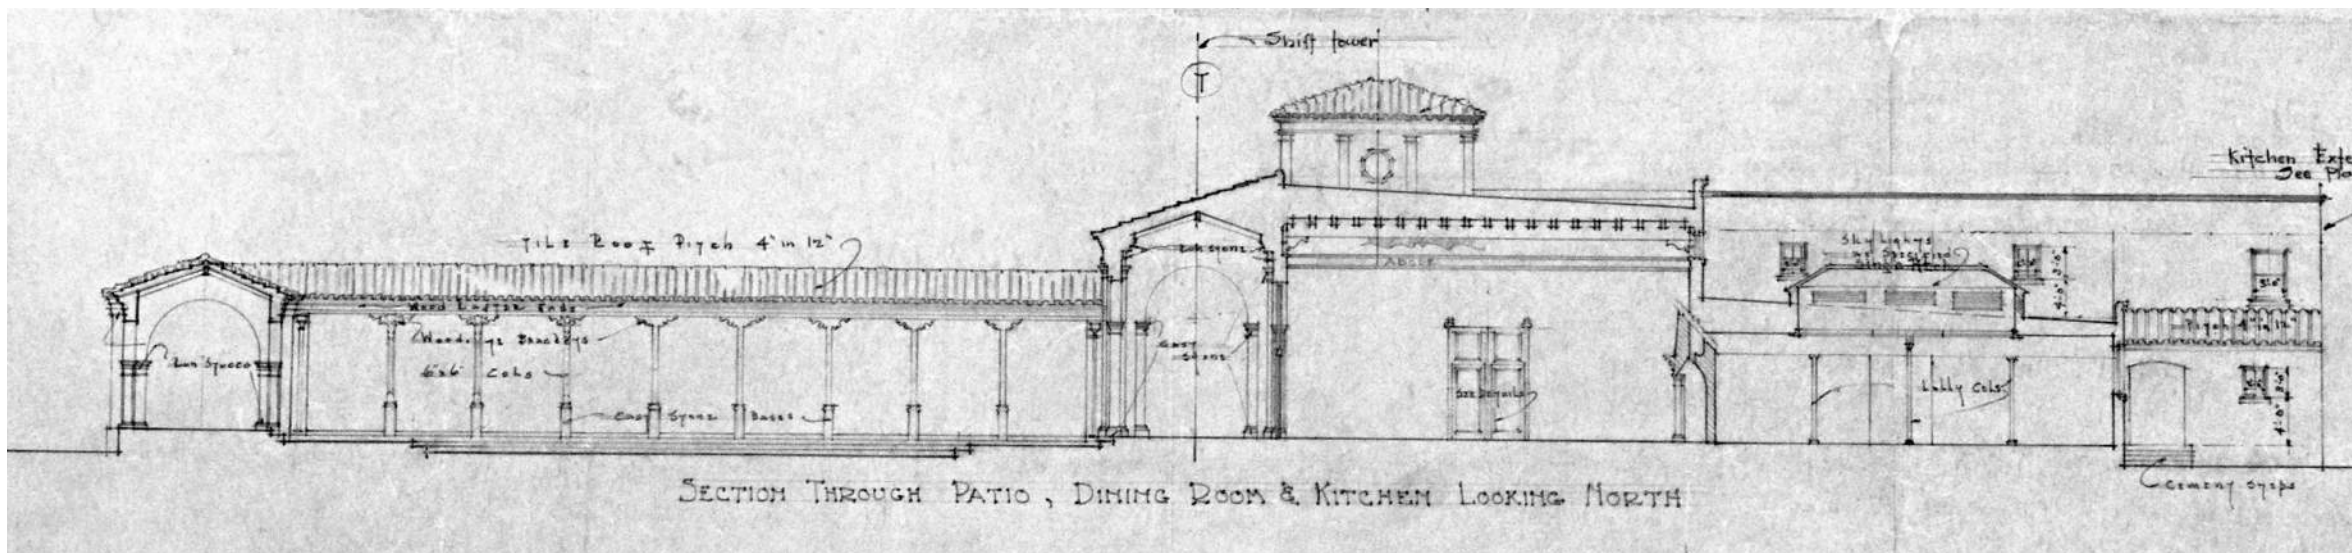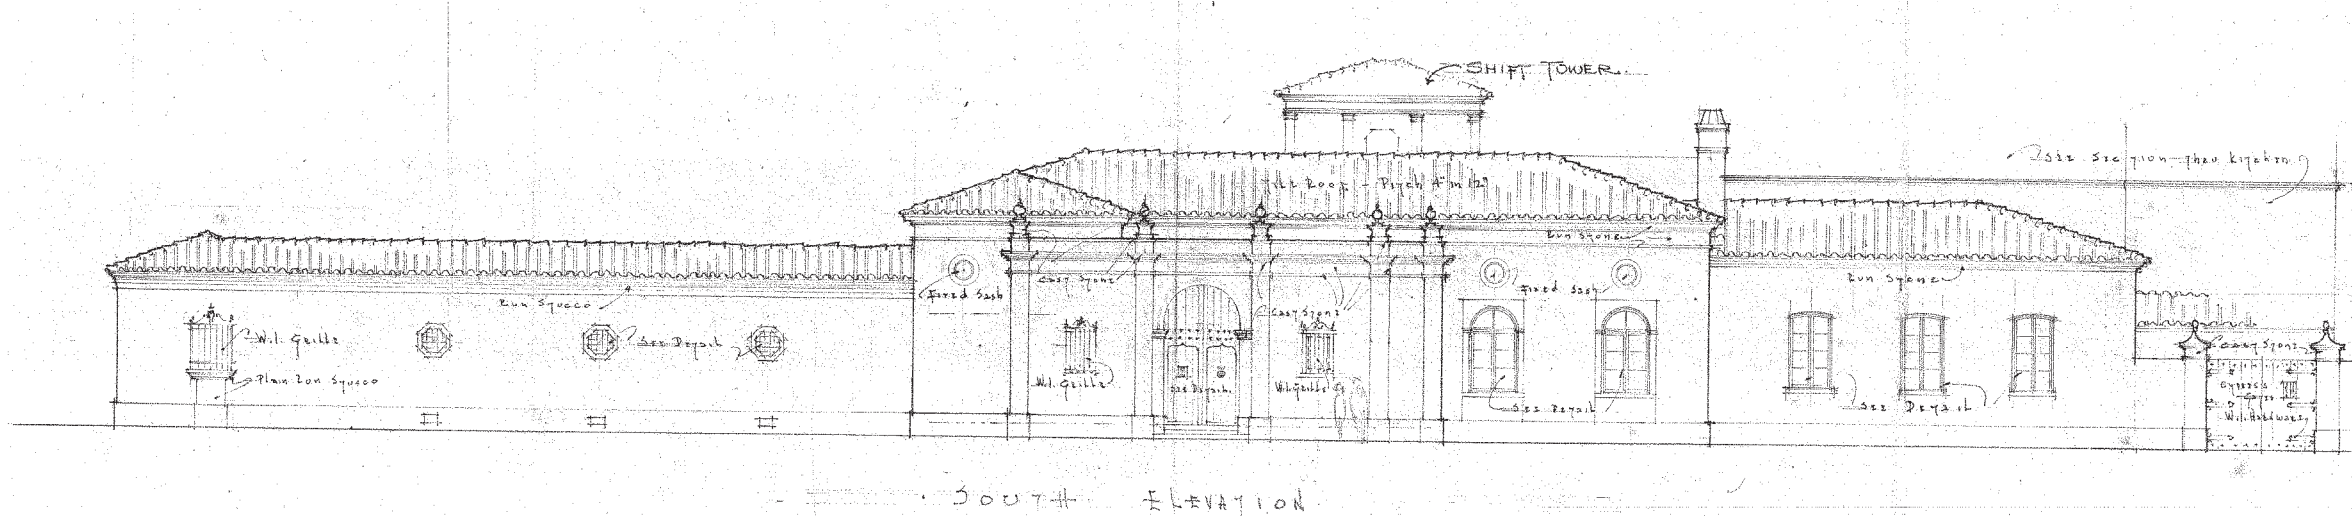

1 SOUTH ELEVATION & E-W SECTION LOOKING NORTH - ADDISON MIZNER, 1925
B-1.0.0 NTS - COURTESY HISTORICAL SOCIETY OF PALM BEACH COUNTY

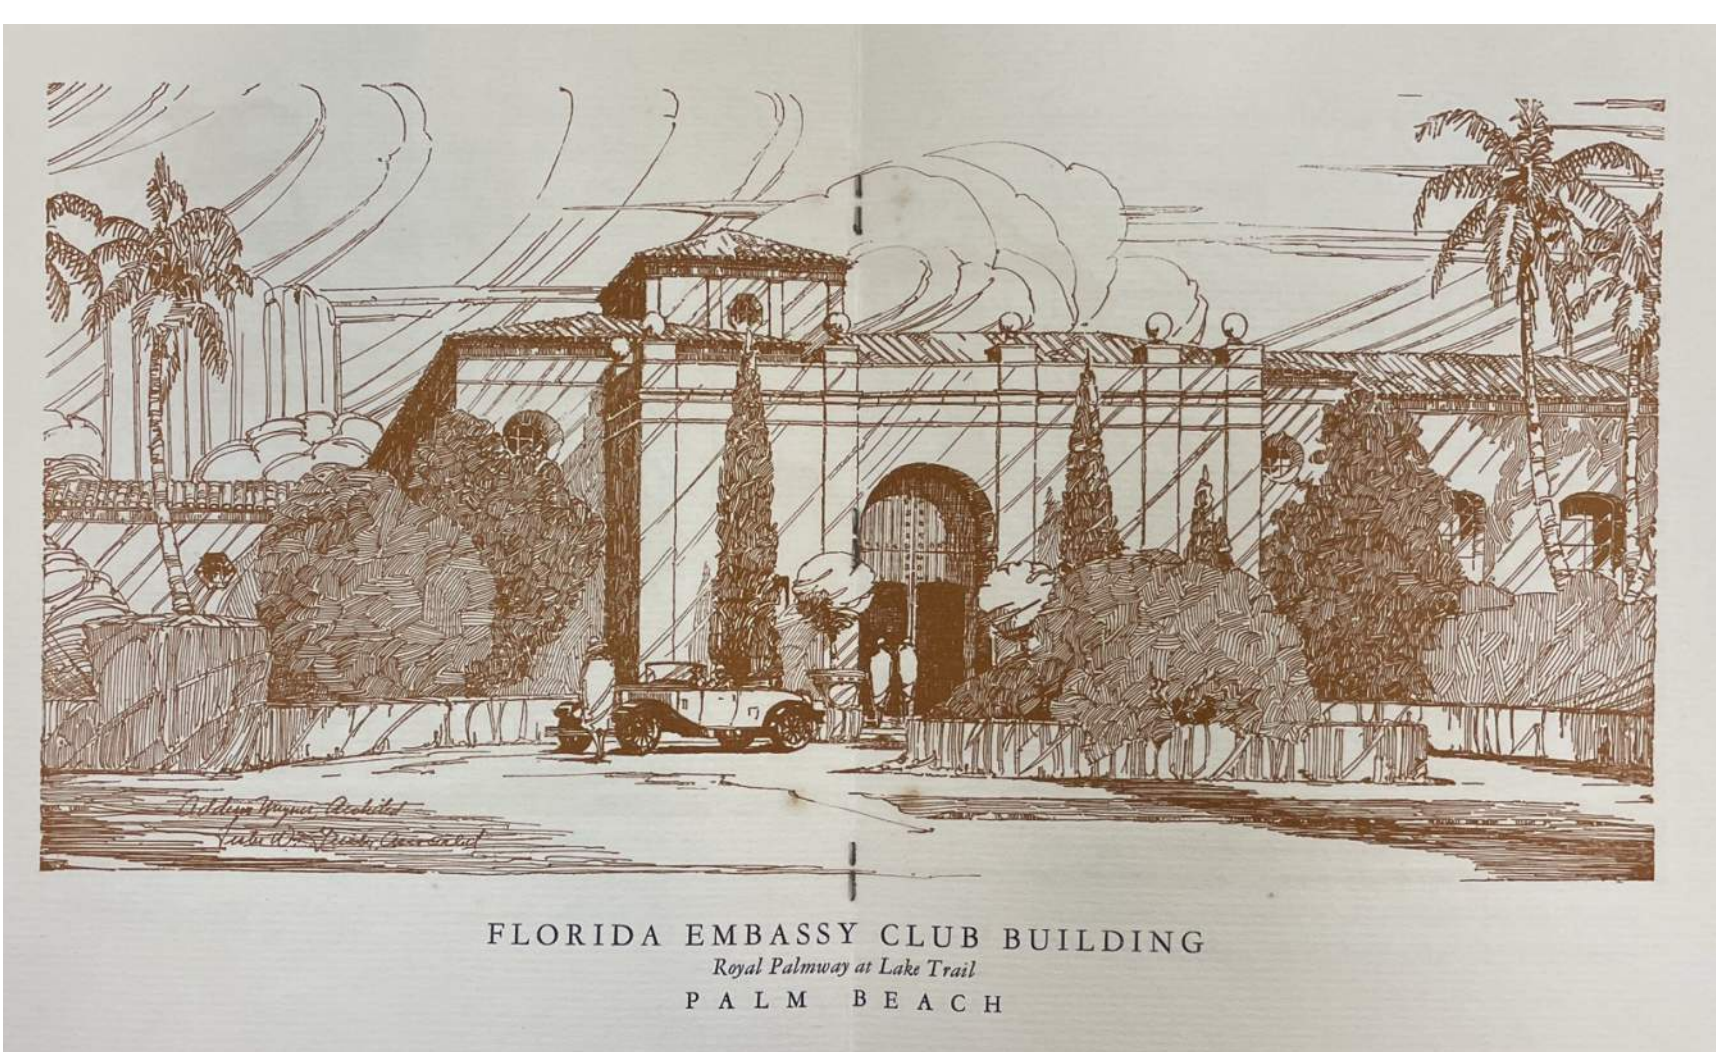

7 FACADE SKETCH, FROM EMBASSY CLUB MEMBERSHIP BROCHURE, 1929
B-1.0.0 NTS - COURTESY HISTORICAL SOCIETY OF PALM BEACH COUNTY

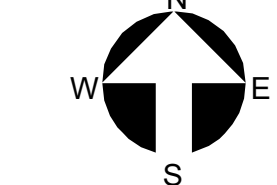

B-1.0.0

Second Submittal

THESE DRAWINGS ARE FOR THE EXCLUSIVE USE OF SPINA OROURKE + PARTNERS, INC. AND MAY NOT BE REPRODUCED, REPRODUCED OR USED IN ANY MANNER WITHOUT THE EXPRESS WRITTEN CONSENT OF SPINA OROURKE + PARTNERS, INC. ALL RIGHTS RESERVED.

Revisions

Project no: 2953
Date: 2024.09.23
Drawn by: Author
Project Manager: Checker

The Society of the Four Arts -
Esther B. O'Keeffe Building

100 Four Arts Plaza, Palm Beach, FL 33480




SPINA OROURKE
+ PARTNERS
Architecture • Interior Design
Keith M. Spina #


285 Banyan Blvd
West Palm Beach
FL 33407
305.884.3340
spinaorourke.com
AA26002399

BEYER
BLINDER
BELLE

120 Broadway
20th Floor
New York, NY 10271
212.777.7800
beyerblinderbelle.com

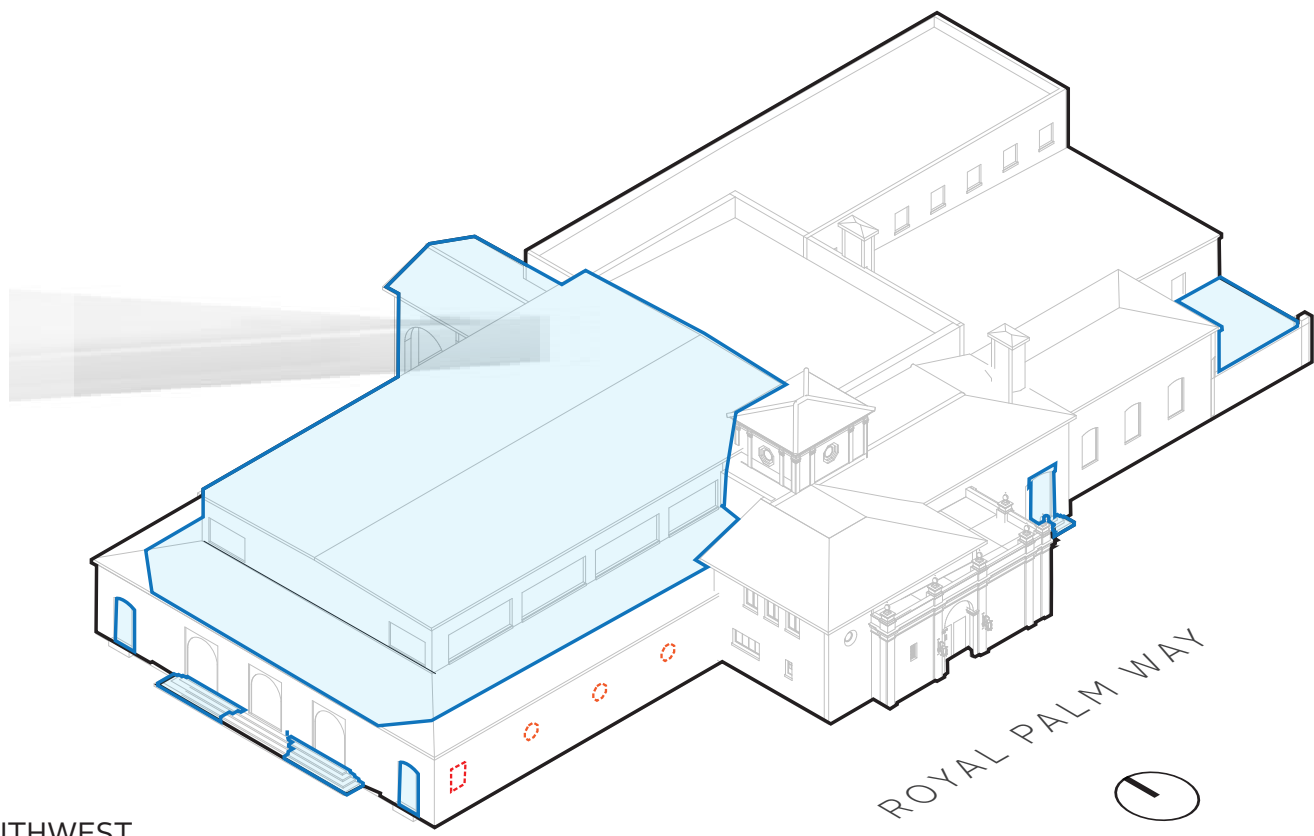

VIEW FROM SOUTHWEST

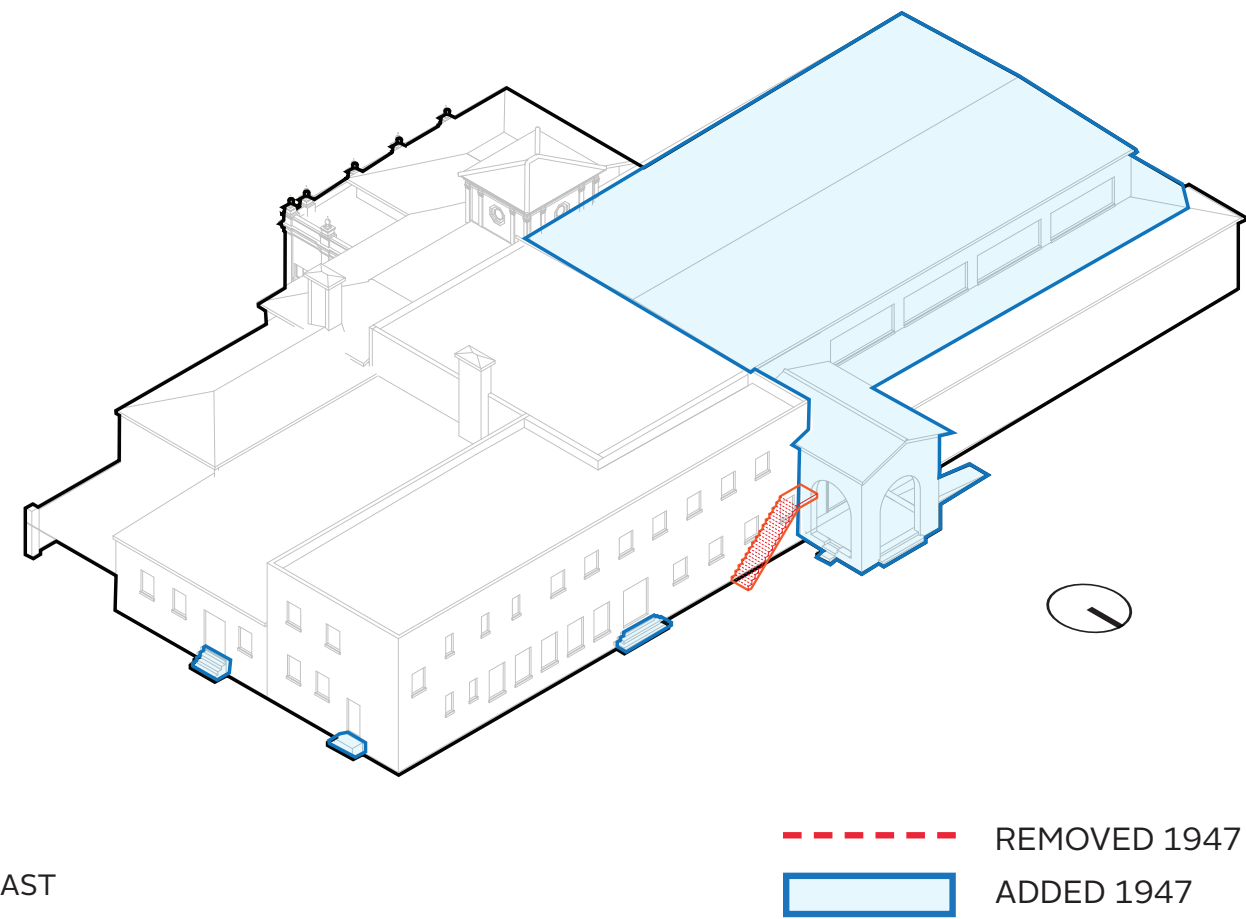

VIEW FROM NORTHEAST

6 AXONOMETRIC DIAGRAMS OF BUILDING IN 1947
B-1.0.1 NTS - DRAWN BY BBB, 2023



3 PHOTO - LOBBY (FORMER LOGGIA), LOOKING SOUTH, CIRCA 1947
B-1.0.1 NTS - COURTESY HISTORICAL SOCIETY OF PALM BEACH COUNTY



8 PHOTO - AUDITORIUM LOOKING WEST TO STAGE, CIRCA 1947
B-1.0.1 NTS - COURTESY HISTORICAL SOCIETY OF PALM BEACH COUNTY



5 PHOTO - AUDITORIUM LOOKING EAST TO FORMER LOGGIA, CIRCA 1947
B-1.0.1 NTS - COURTESY HISTORICAL SOCIETY OF PALM BEACH COUNTY




2 PHOTO - MAIN GALLERY (FORMERLY DINING) LOOKING NORTH, CIRCA 1947
B-1.0.1 NTS - COURTESY HISTORICAL SOCIETY OF PALM BEACH COUNTY



7 FACADE SKETCH, FROM EMBASSY CLUB MEMBERSHIP BROCHURE, 1929
B-1.0.1 NTS - COURTESY HISTORICAL SOCIETY OF PALM BEACH COUNTY




4 PHOTO - SOUTH ELEVATION FROM ROYAL PALM WAY, CIRCA 1947
B-1.0.1 NTS - COURTESY HISTORICAL SOCIETY OF PALM BEACH COUNTY

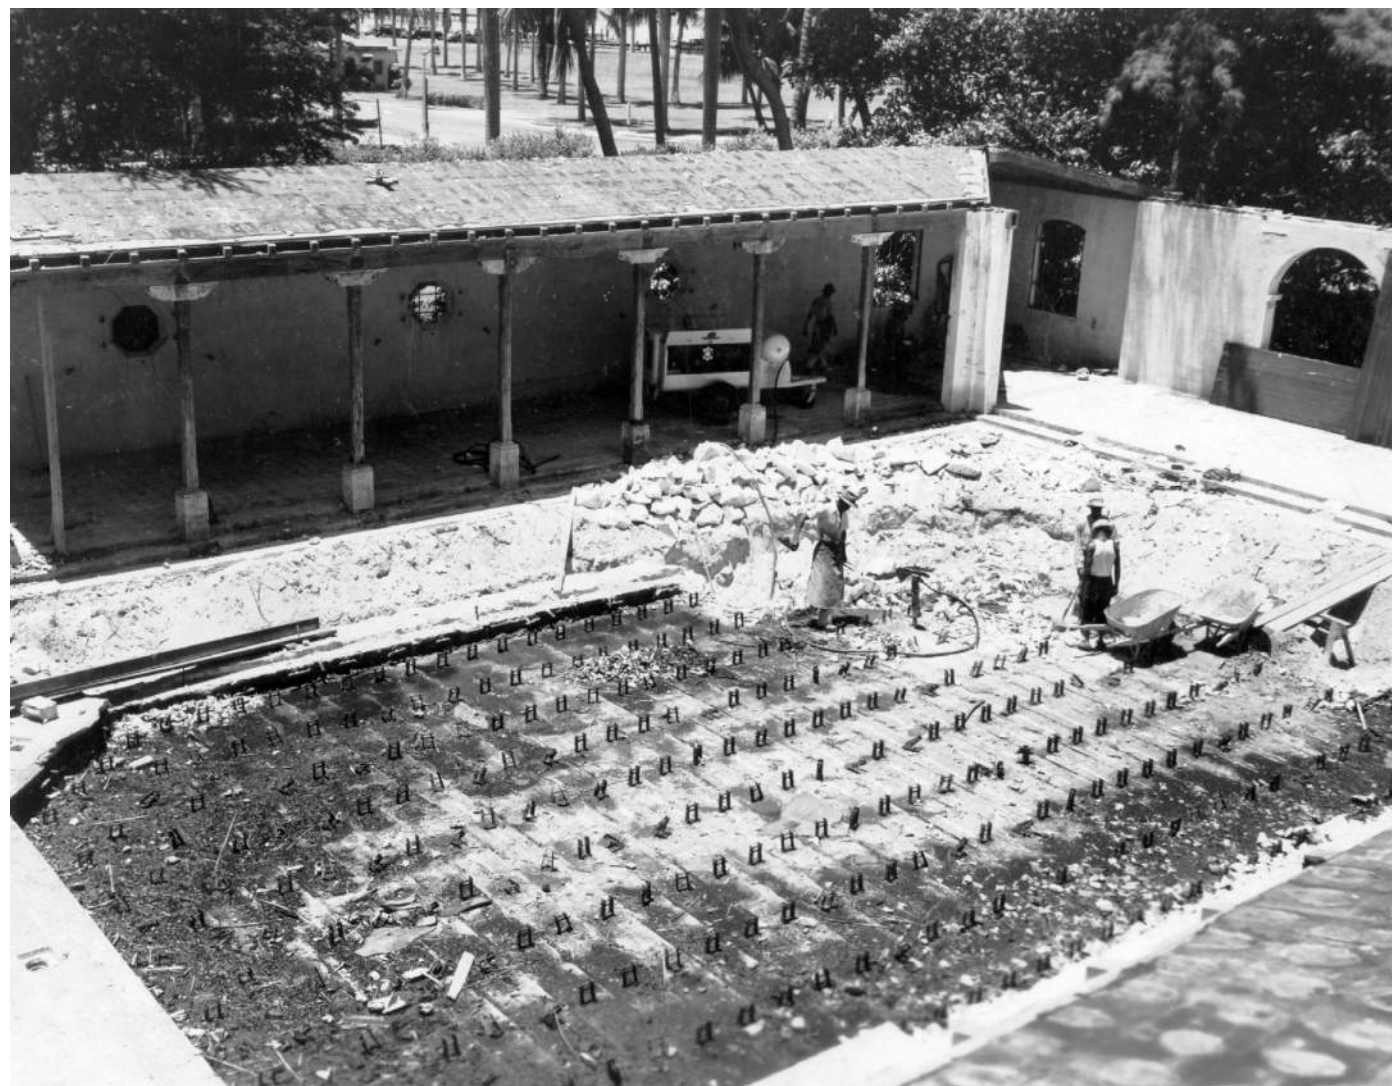


1 PHOTO - 1930 SOUTH CLOISTER AND DANCE FLOOR DURING DEMOLITION, CIRCA 1947
B-1.0.1 NTS - COURTESY HISTORICAL SOCIETY OF PALM BEACH COUNTY

VIEW FROM SOUTHWEST

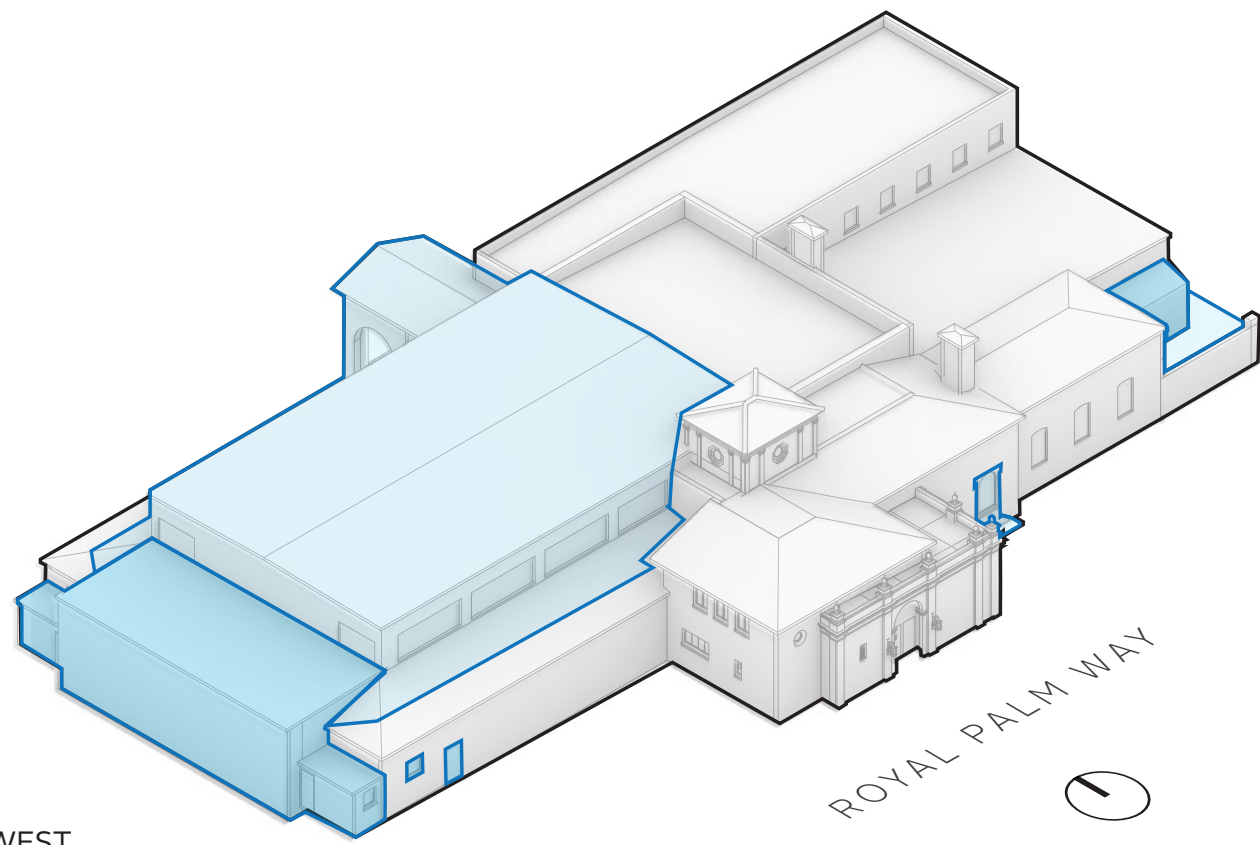

VIEW FROM NORTHEAST

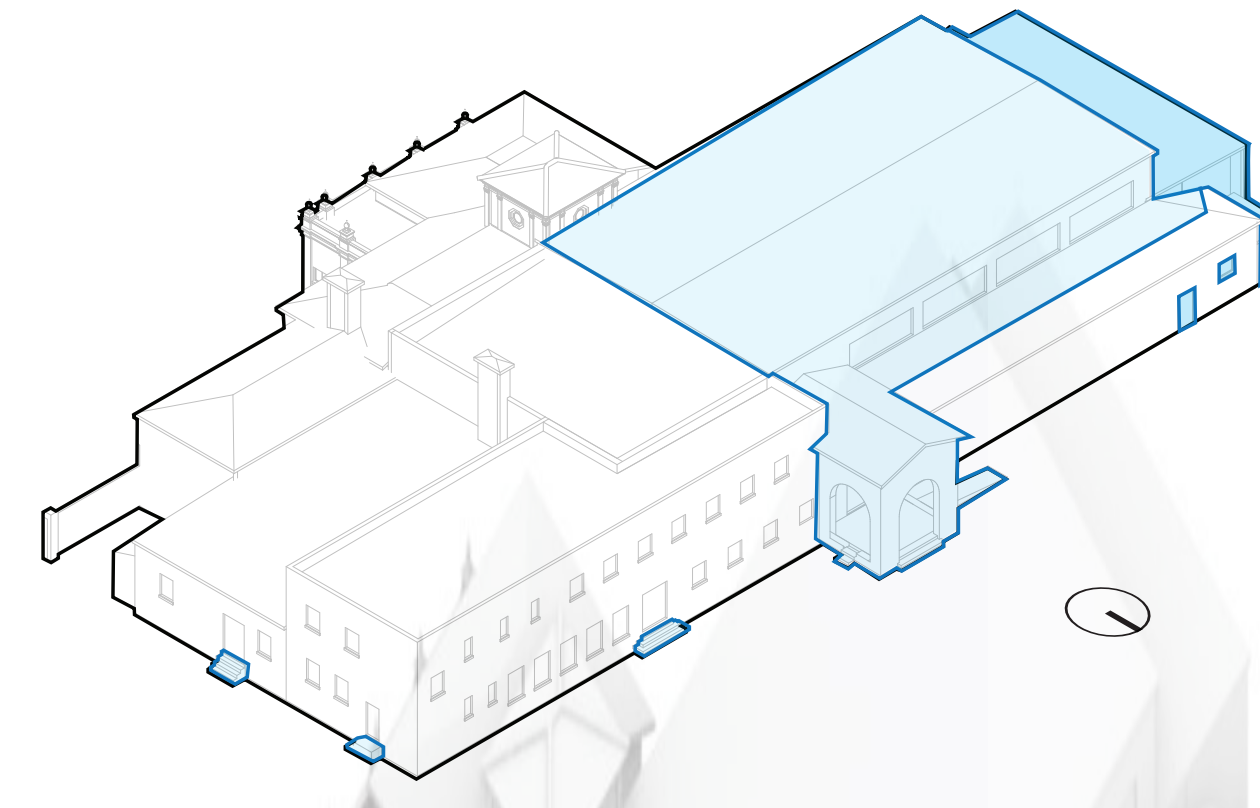


ADDED 1947
ADDED 1957


4 AXONOMETRIC DIAGRAMS OF BUILDING IN 1957
B-1.0.2 NTS - DRAWN BY BBB, 2023



1 PHOTO - EXISTING CONDITIONS, WEST ELEVATION (OCTOBER 2022)
B-1.0.2 NTS

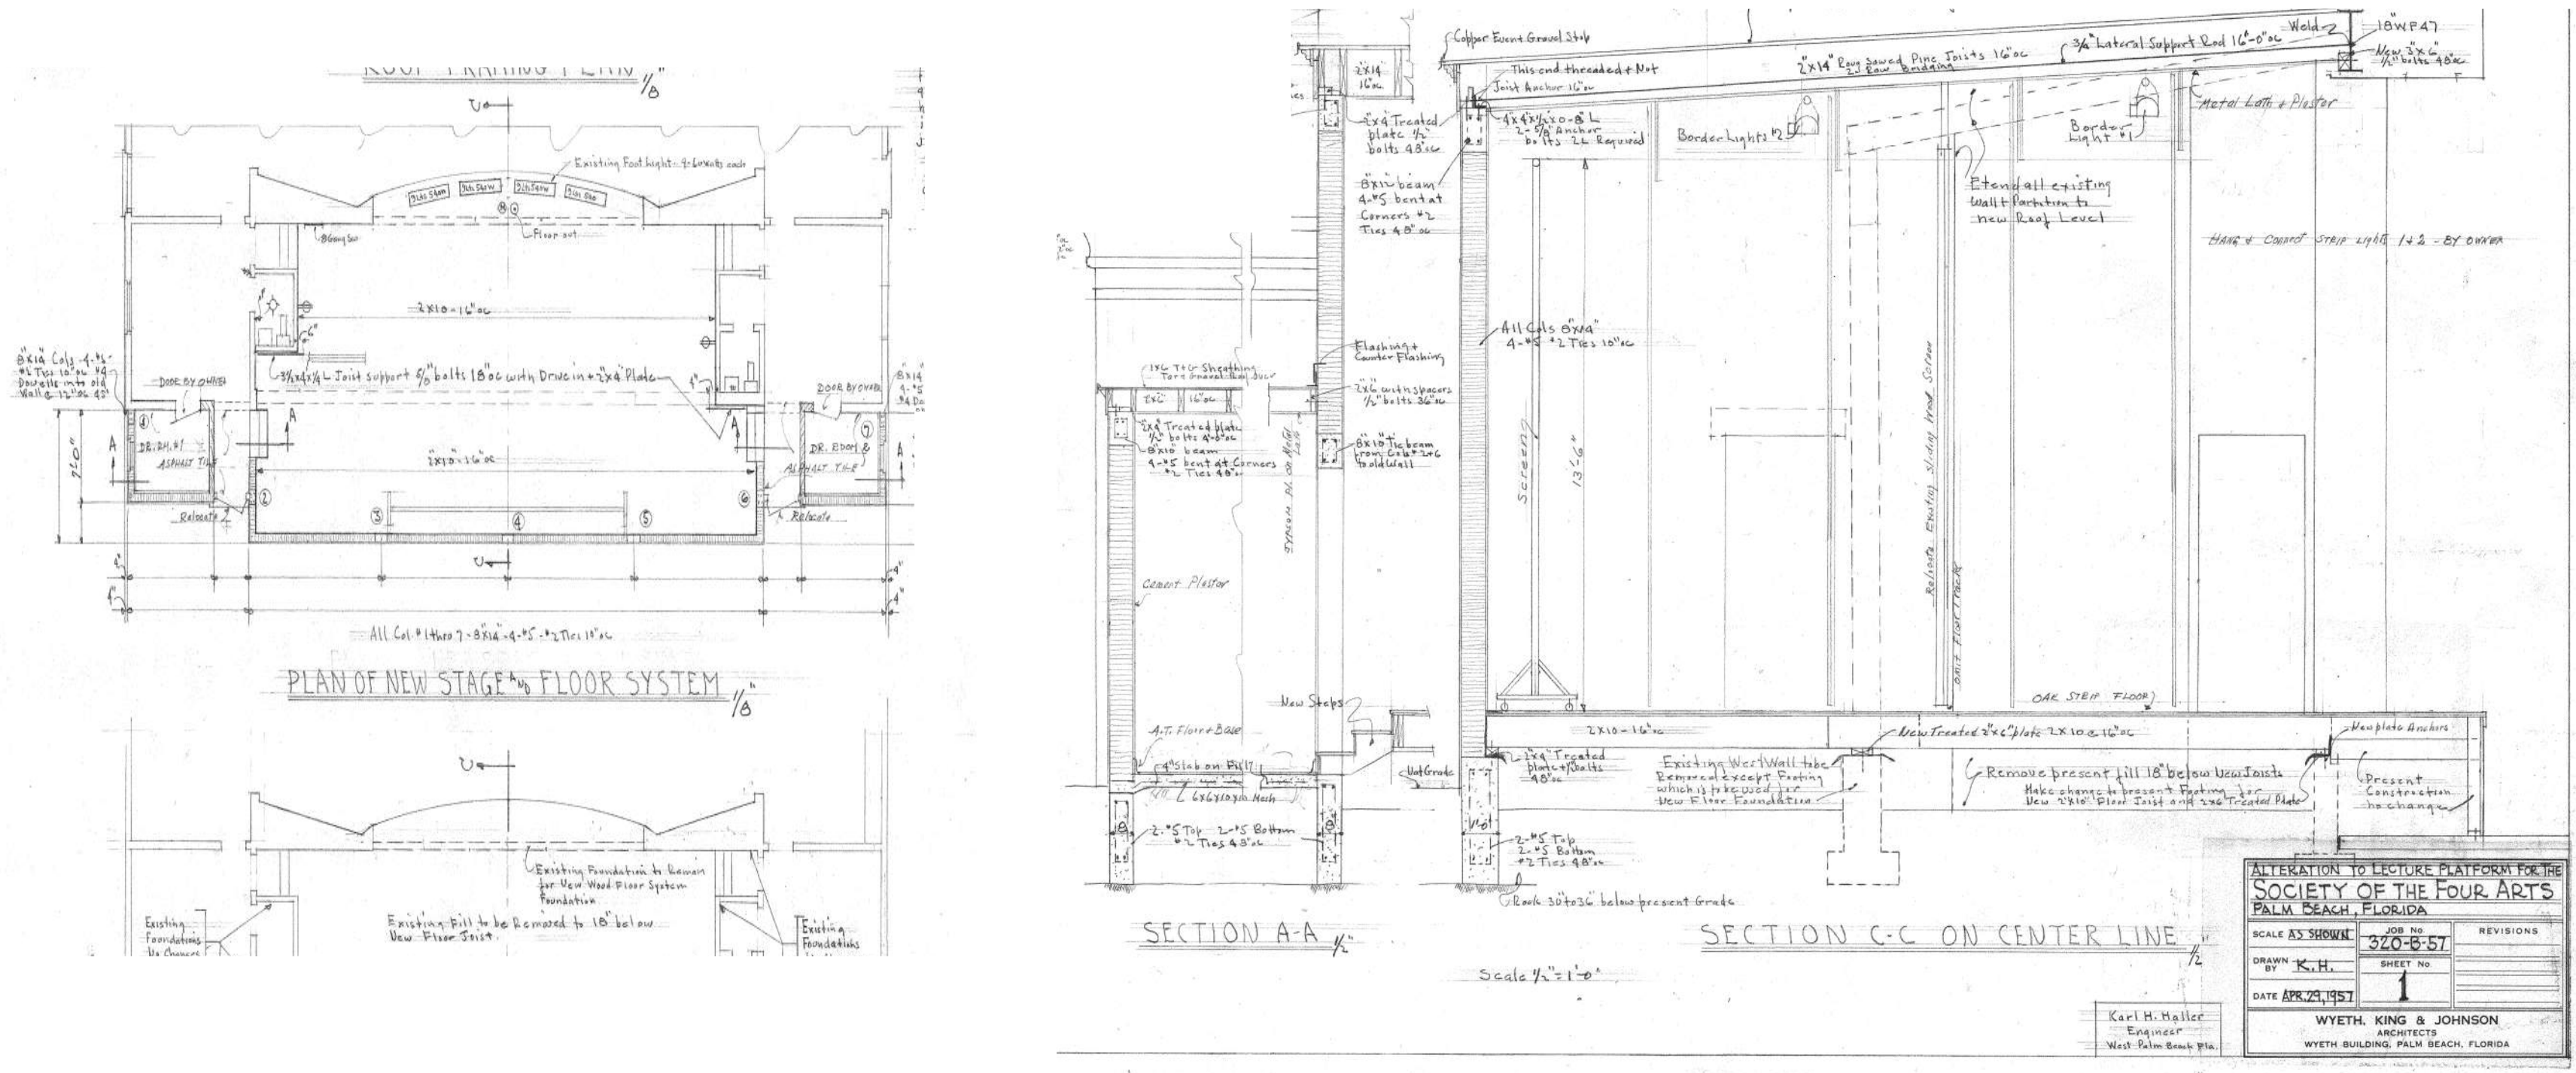

3 DETAILS FOR BACKSTAGE EXPANSION AS CONSTRUCTED - WYETH, KING & JOHNSON, 1957
B-1.0.2 SCALE IS 50% OF NOTED HISTORIC SCALE ON DRAWING - COURTESY THE PRESERVATION FOUNDATION OF PALM BEACH

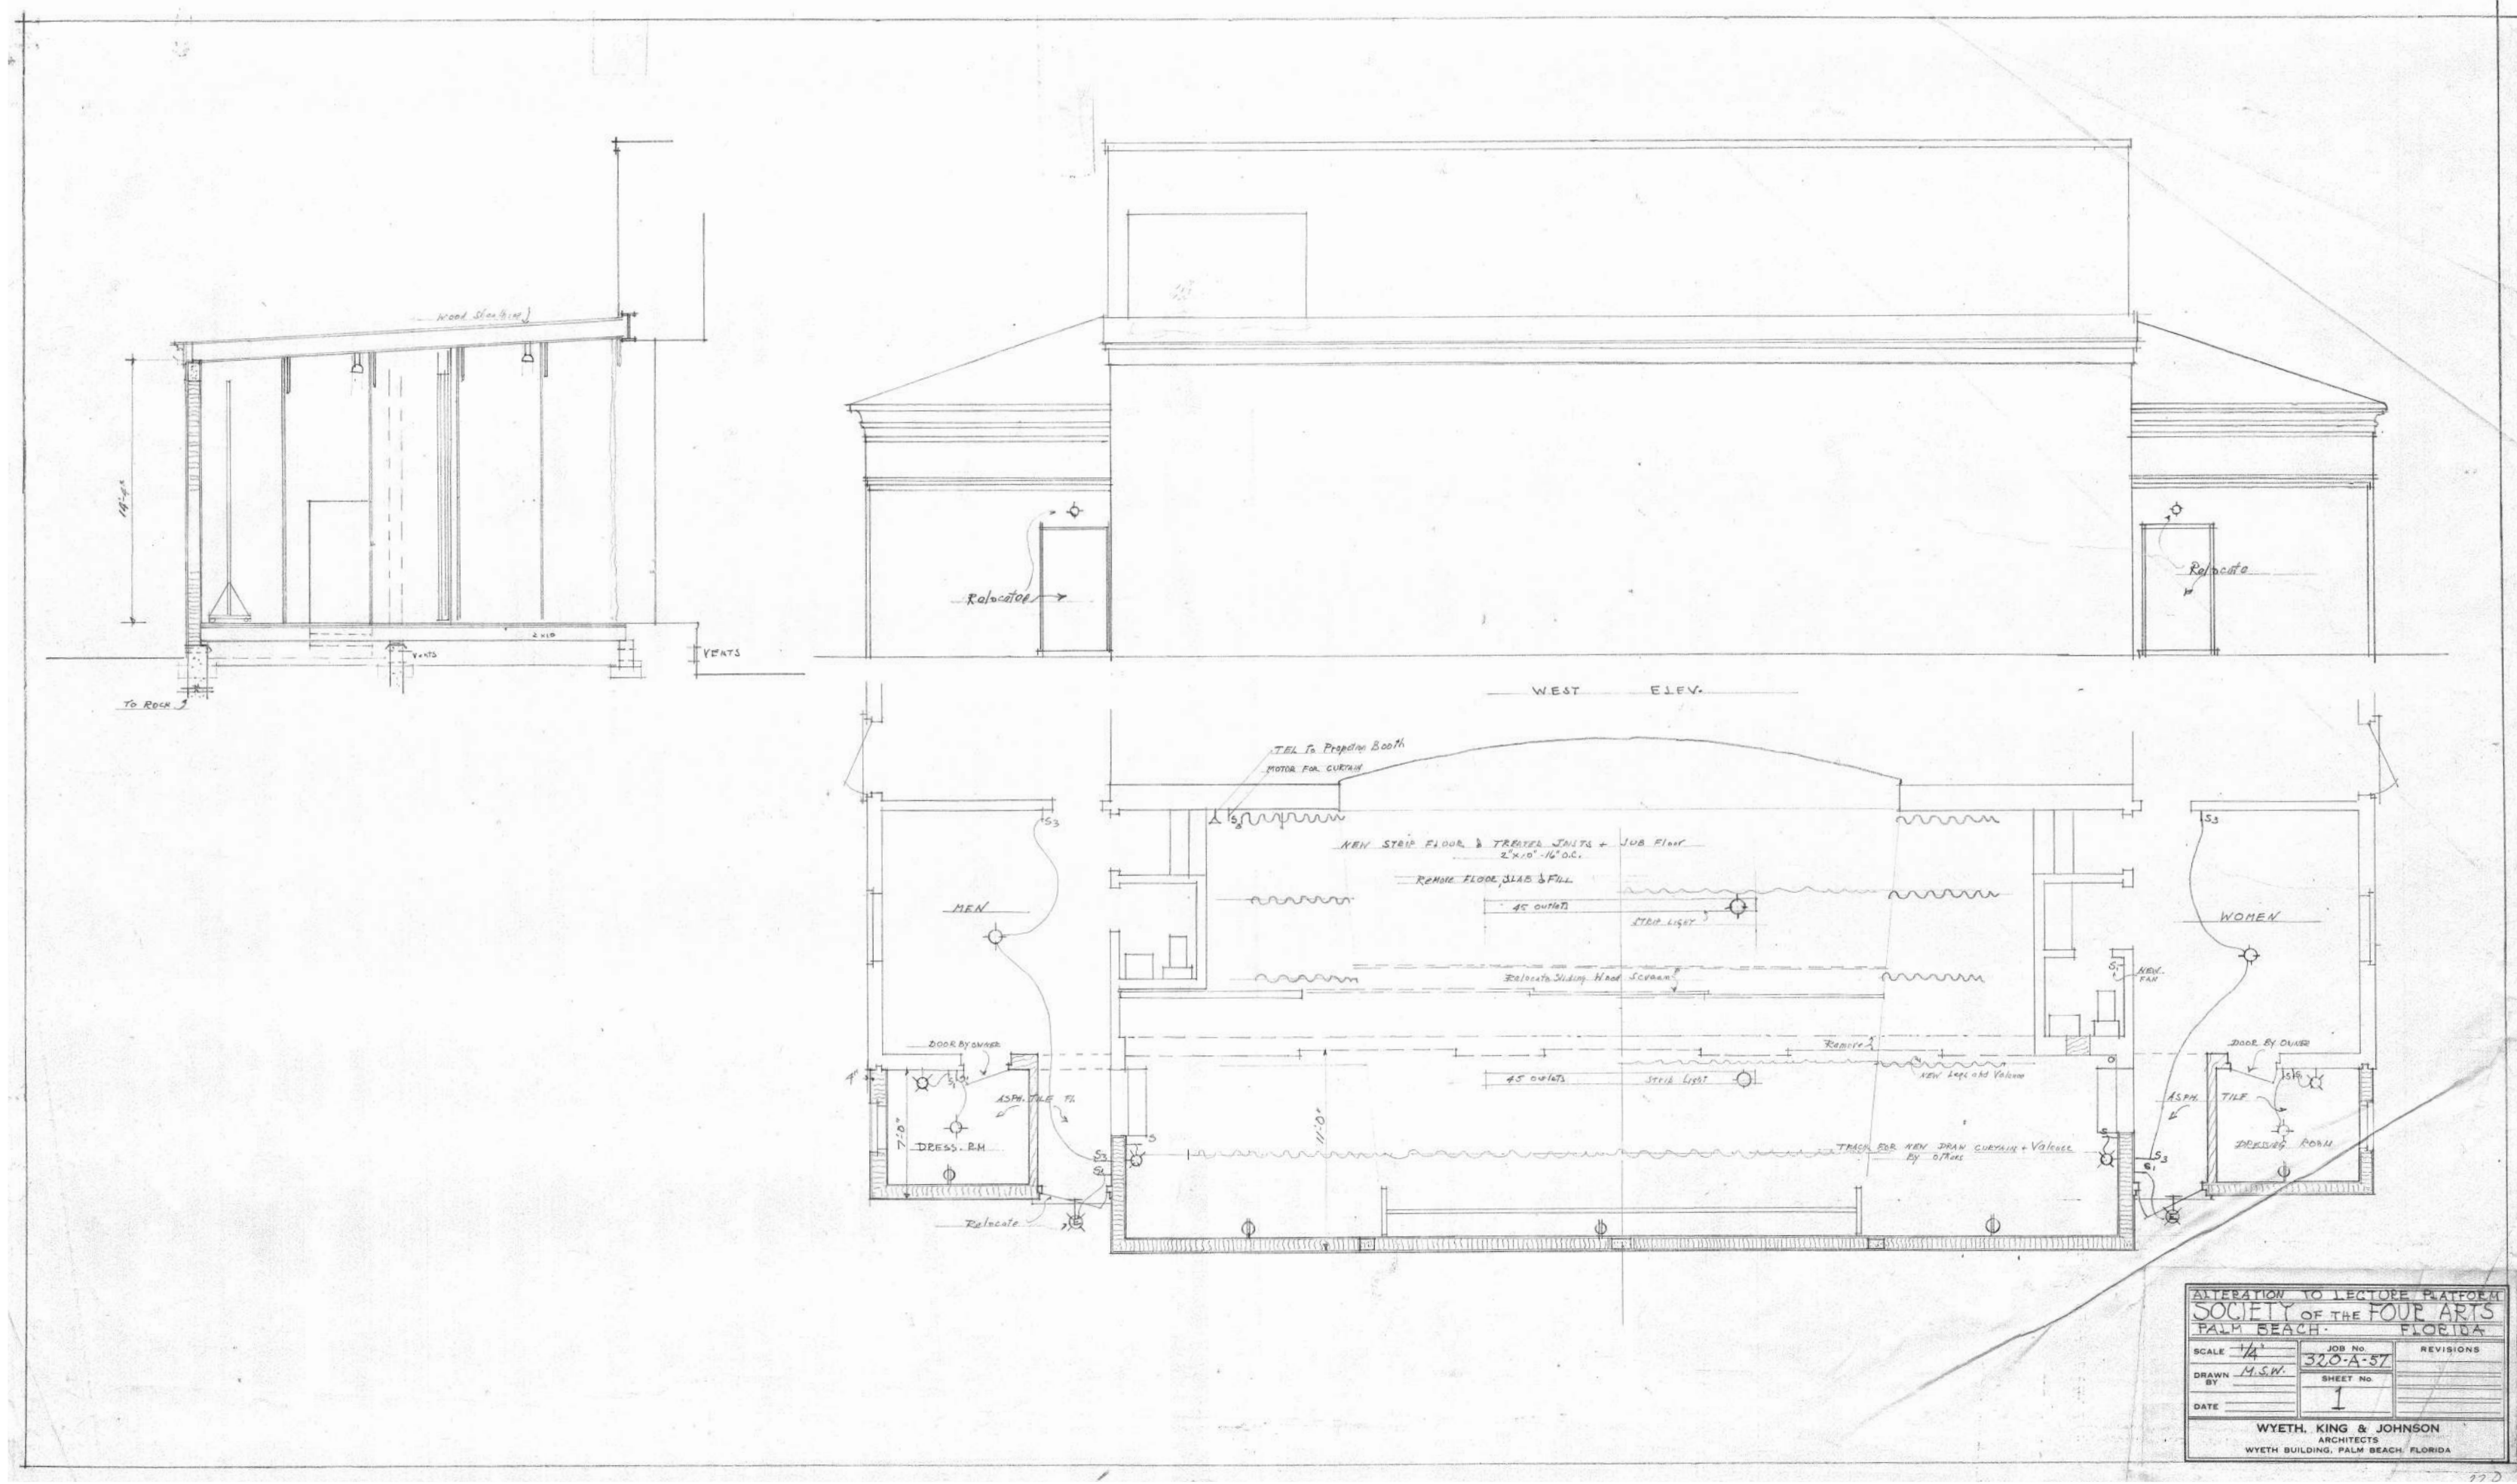

1 INITIAL BACKSTAGE EXPANSION STUDY - WYETH, KING & JOHNSON, 1957
B-1.0.2 SCALE IS 50% OF NOTED HISTORIC SCALE ON DRAWING - COURTESY THE PRESERVATION FOUNDATION OF PALM BEACH




PROPOSED ENLARGEMENT TO THE STAGE FOR
THE SOCIETY OF THE FOUR ARTS: PALM BEACH: FLA.
WYETH, KING & JOHNSON JOHN L VOLK
ASSOCIATED ARCHITECTS

UNBUILT PROPOSALS

B-1.1.0

Second Submittal

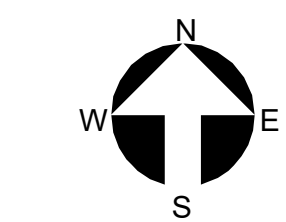

Project no: 2953
Date: 2024.09.23
Drawn by: Author
Project Manager: Checker

Revisions

THESE DRAWINGS ARE FOR THE
EXCLUSIVE USE OF SPINA OROURKI
PARTNERS, INC. AND MAY NOT BE
DUPLICATED, REPRODUCED OR USED
IN ANY MANNER WITHOUT THE
EXPRESS WRITTEN CONSENT OF SPINA
OROURKE + PARTNERS, INC. ALL
RIGHTS RESERVED

The Society of the Four Arts - Esther B. O'Keeffe Building

100 Four Arts Plaza, Palm Beach, FL 33480



SPINASOURCE
+ PARTNERS


Architecture • Interior Design
Keith M. Spina #



CDINIA CORPORATION
285 Banyan Blvd

**BEYER
BLINDER
BELLE**

120 Broadway
20th Floor
New York, NY, 10271
212 777 7800
beverblinderbelle.com

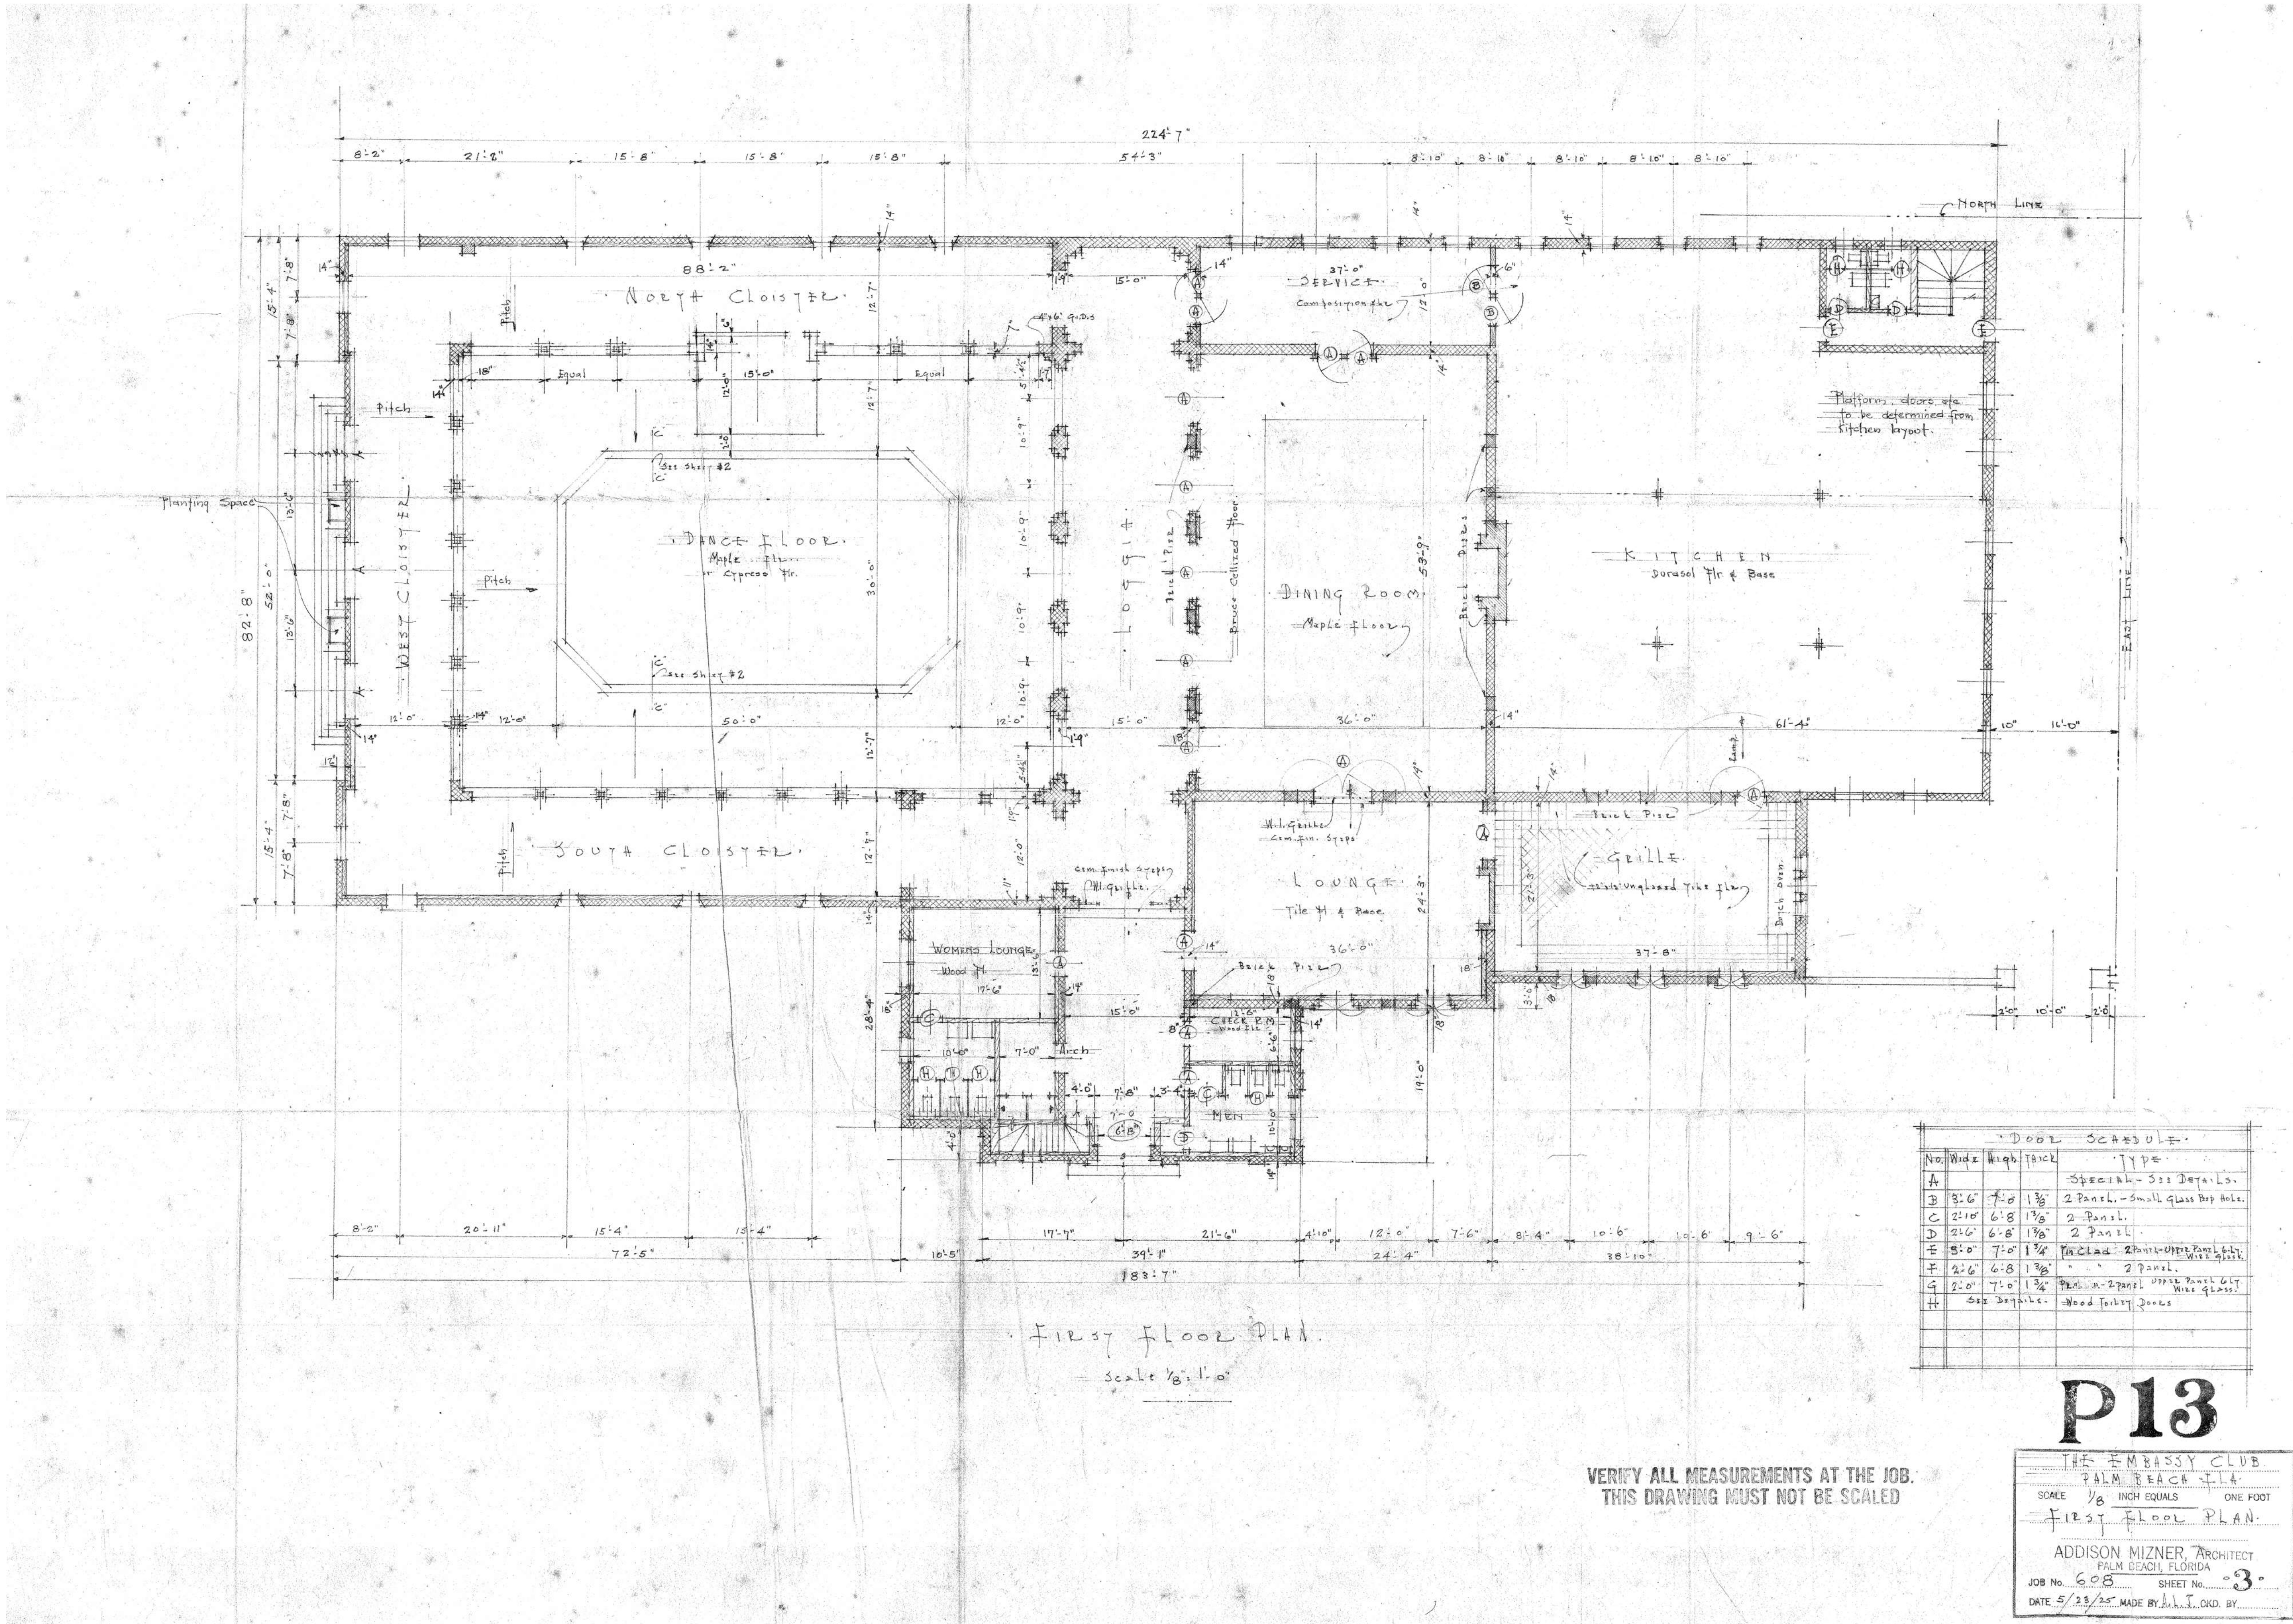

1 FIRST FLOOR PLAN - ADDISON MIZNER, 1925
B-2.1.0 3/32" = 1'-0"

BEYER BLINDER BELLE
120 Broadway
20th Floor
New York, NY, 10271
212.777.7800
beyerblinderbelle.com

285 Banyan Blvd
West Palm Beach
FL 33407
888.888.8847
spinaorourke.com
A25002399

SPINAOROURKE + PARTNERS
Architecture • Interior Design
Keith M. Spina P

The Society of the Four Arts -
Esther B. O'Keefe Building
100 Four Arts Plaza, Palm Beach, FL 33480


THESE DRAWINGS ARE FOR THE EXCLUSIVE USE OF SPINAOROURKE + PARTNERS, INC. AND MAY NOT BE REPRODUCED, COPIED, OR USED IN ANY MANNER WITHOUT THE EXPRESS WRITTEN CONSENT OF SPINAOROURKE + PARTNERS, INC. ALL RIGHTS RESERVED.

Revisions

Project no: 2953
Date: 2024.09.23
Drawn by: Author
Project Manager: Checker



HISTORIC PLAN - FIRST FLOOR - MIZNER


B-2.1.0
Second Submittal

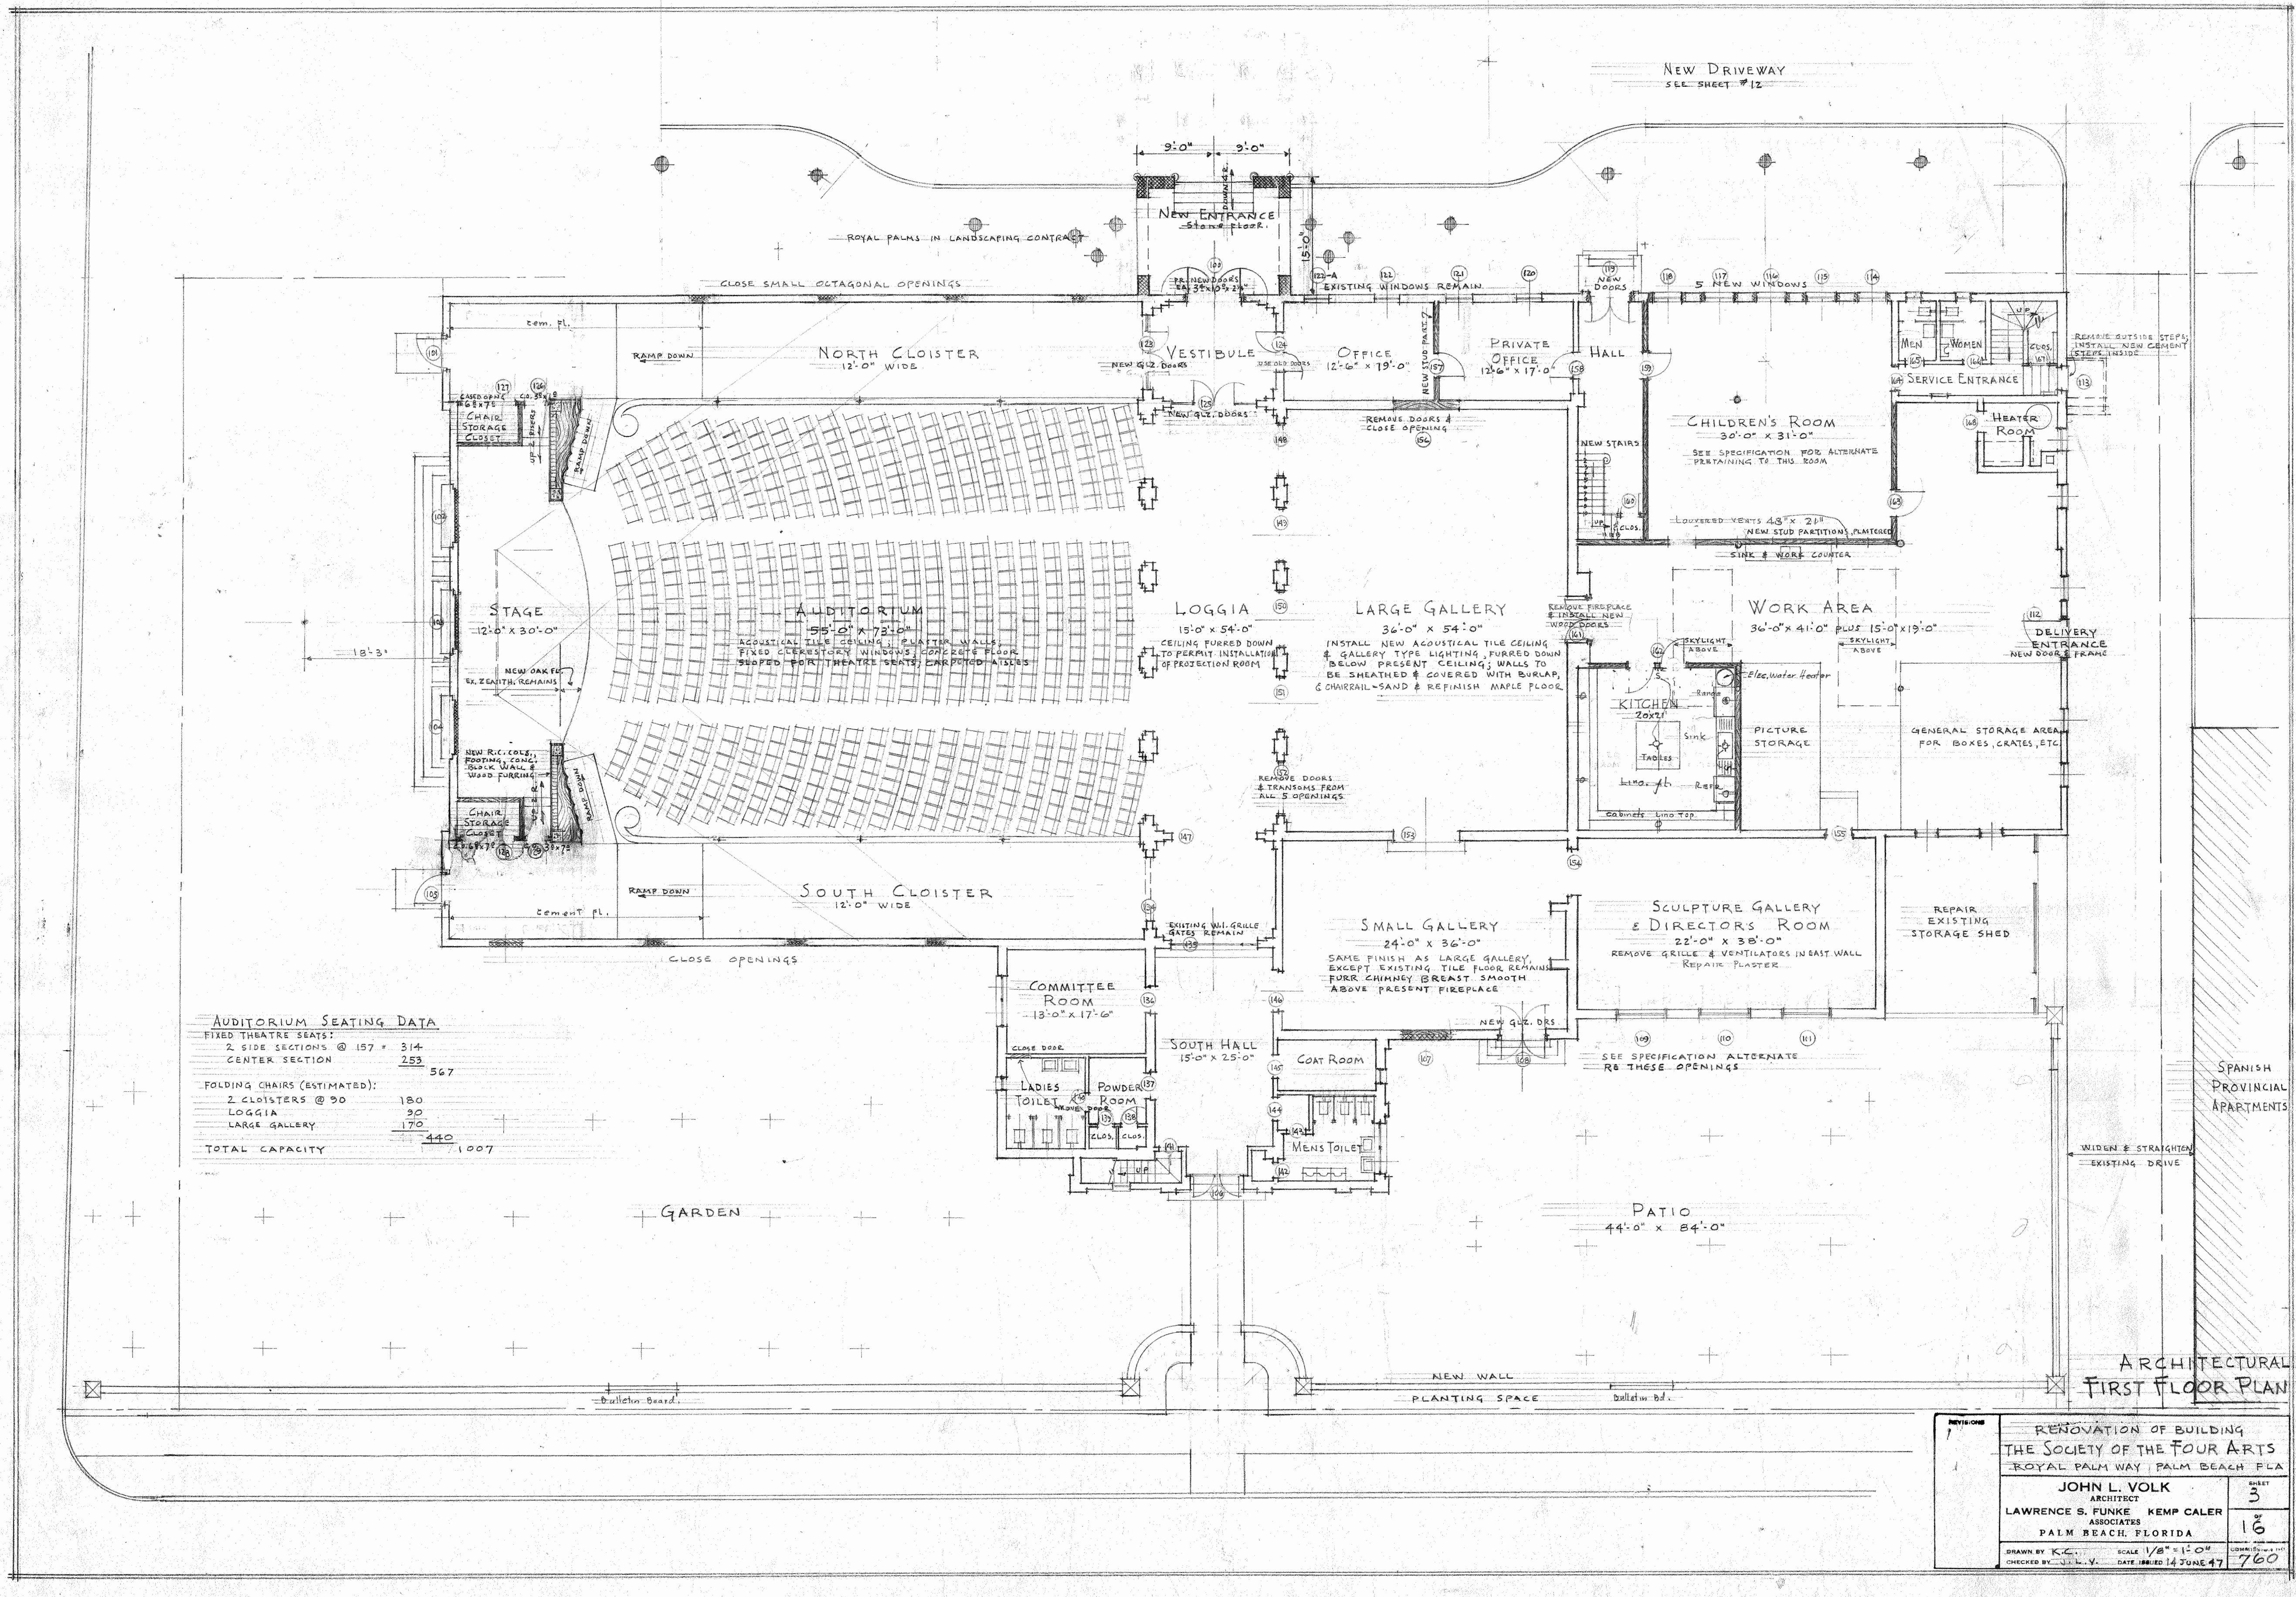

1 FIRST FLOOR PLAN - JOHN VOLK, 1947
B-2.1.1 3/32" = 1'-0"

1 EXISTING PLAN - GROUND FLOOR
B-2.1.2 3/32" = 1'-0"

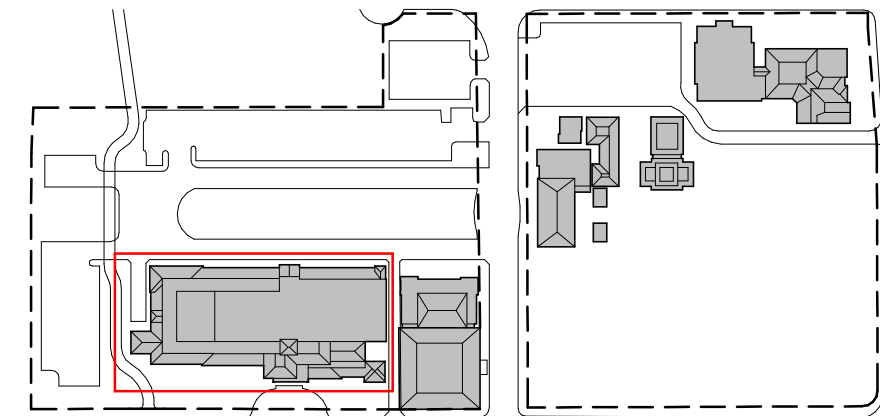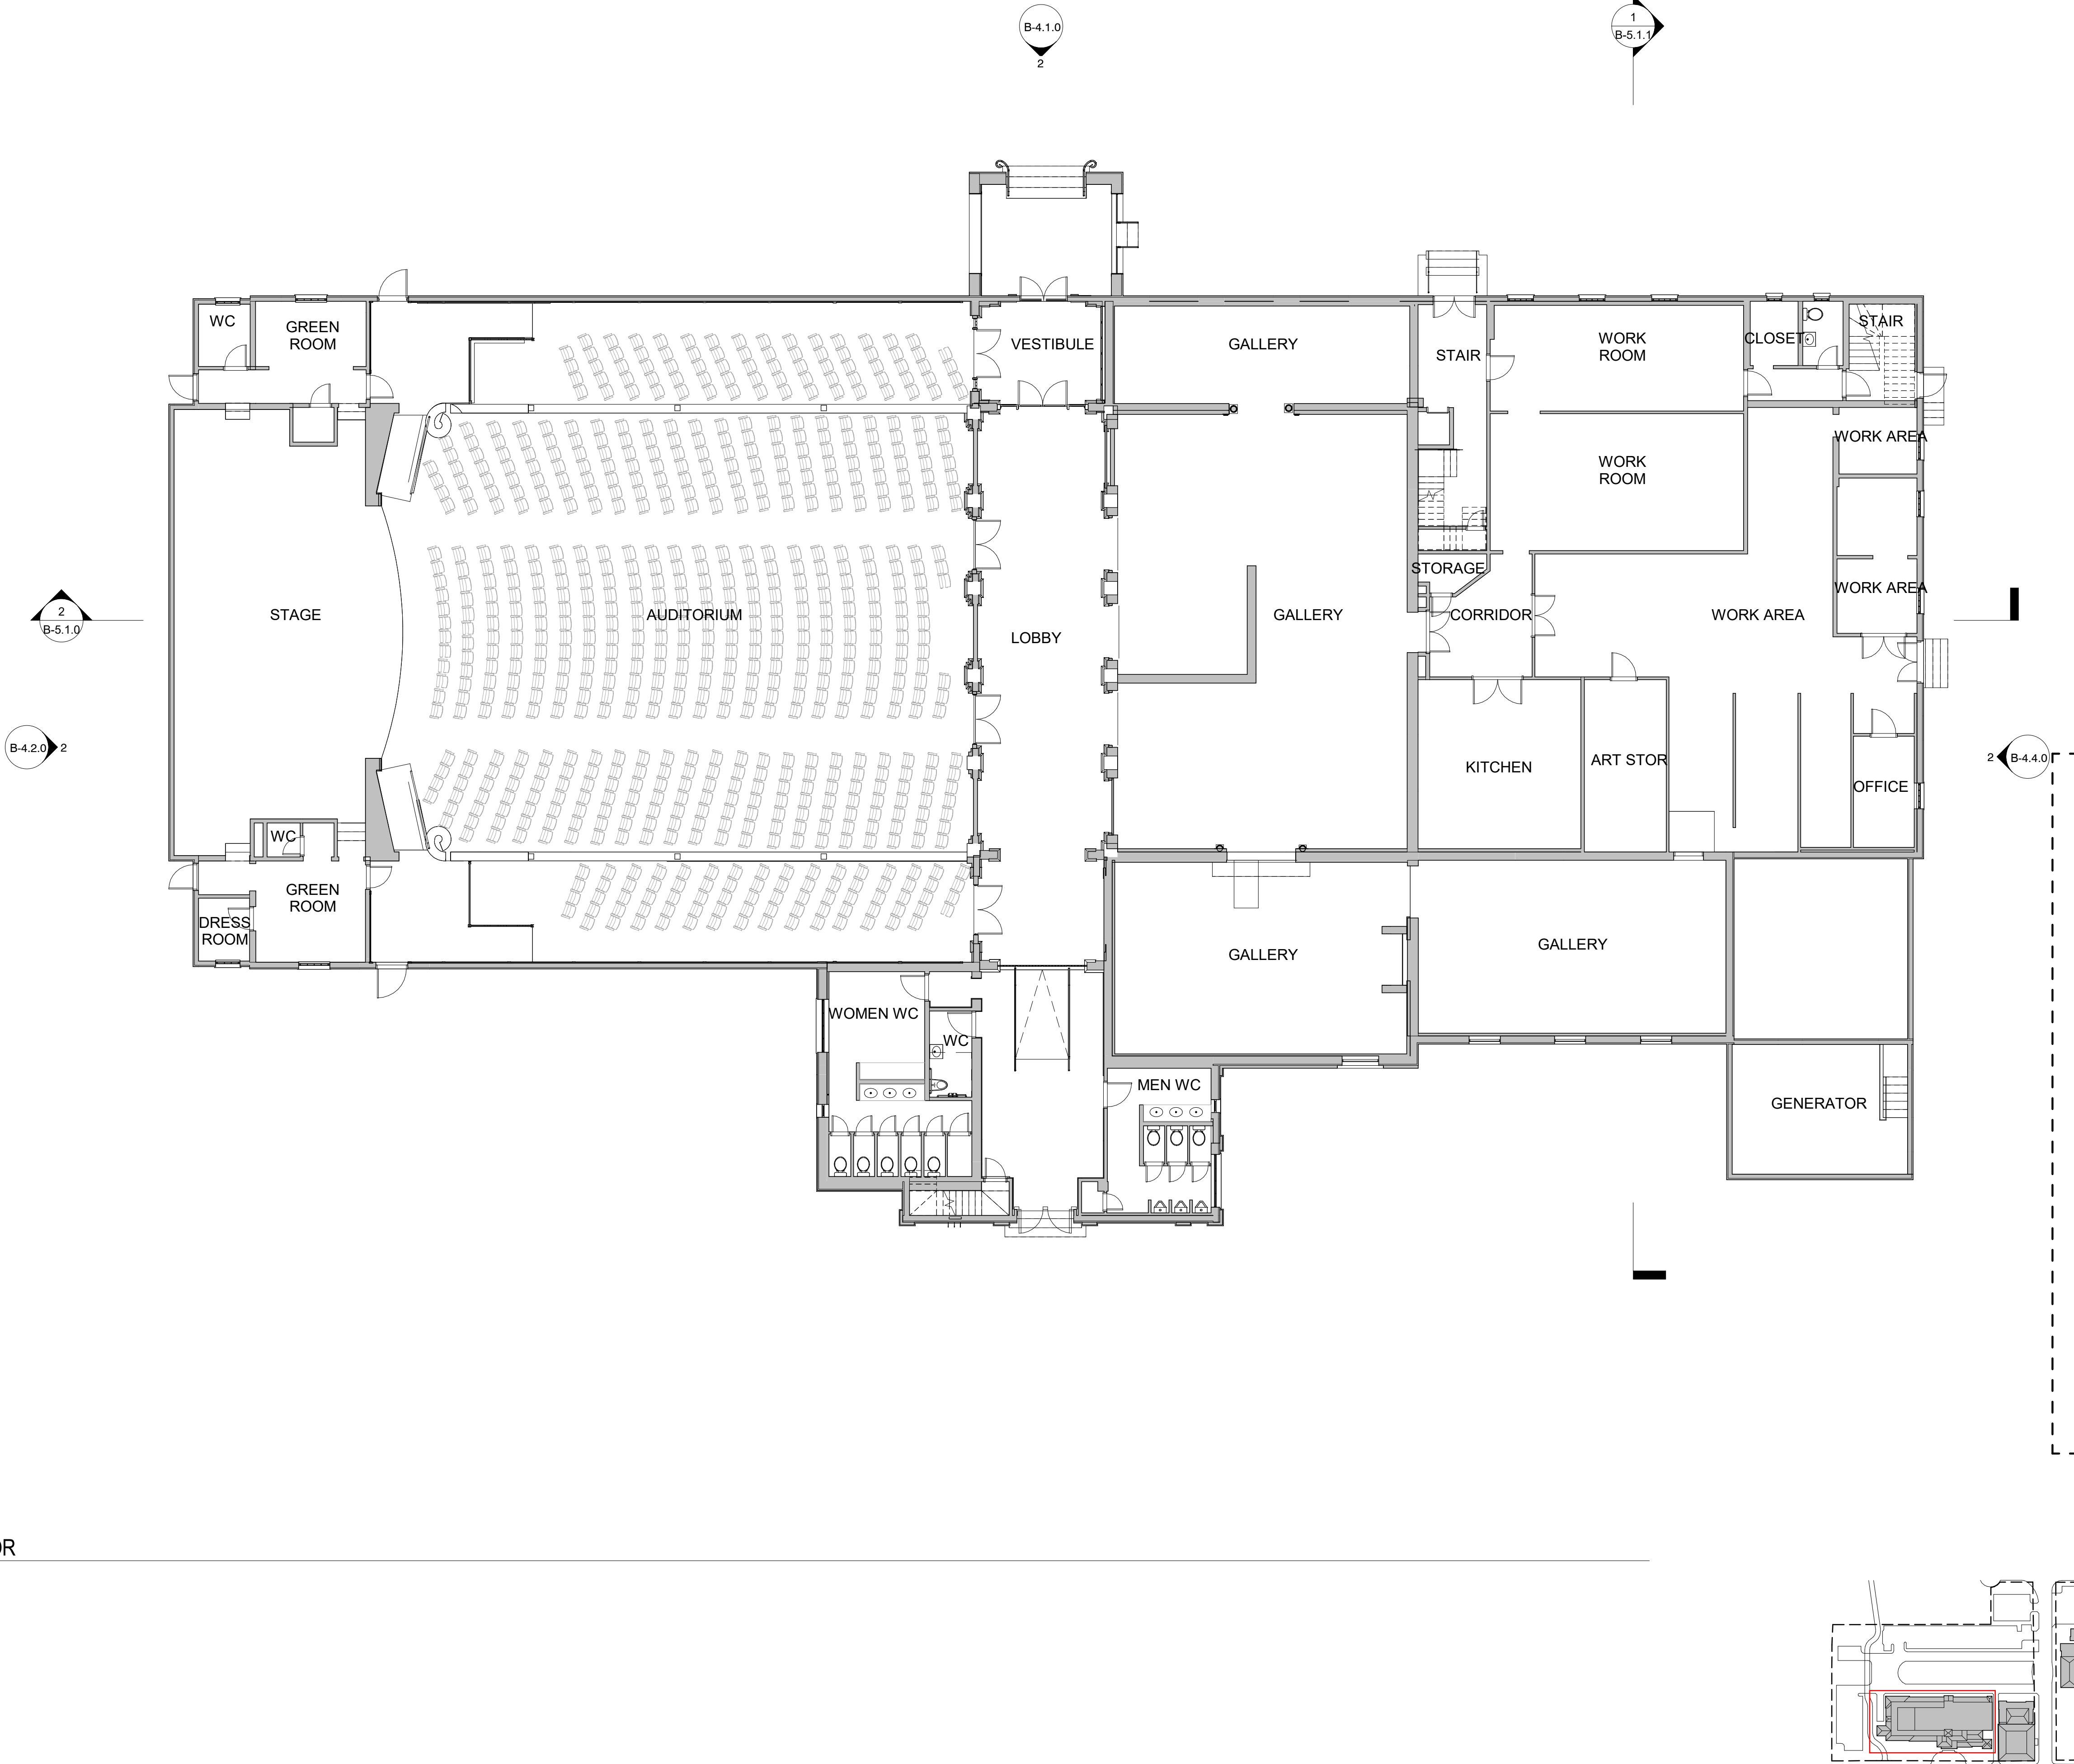

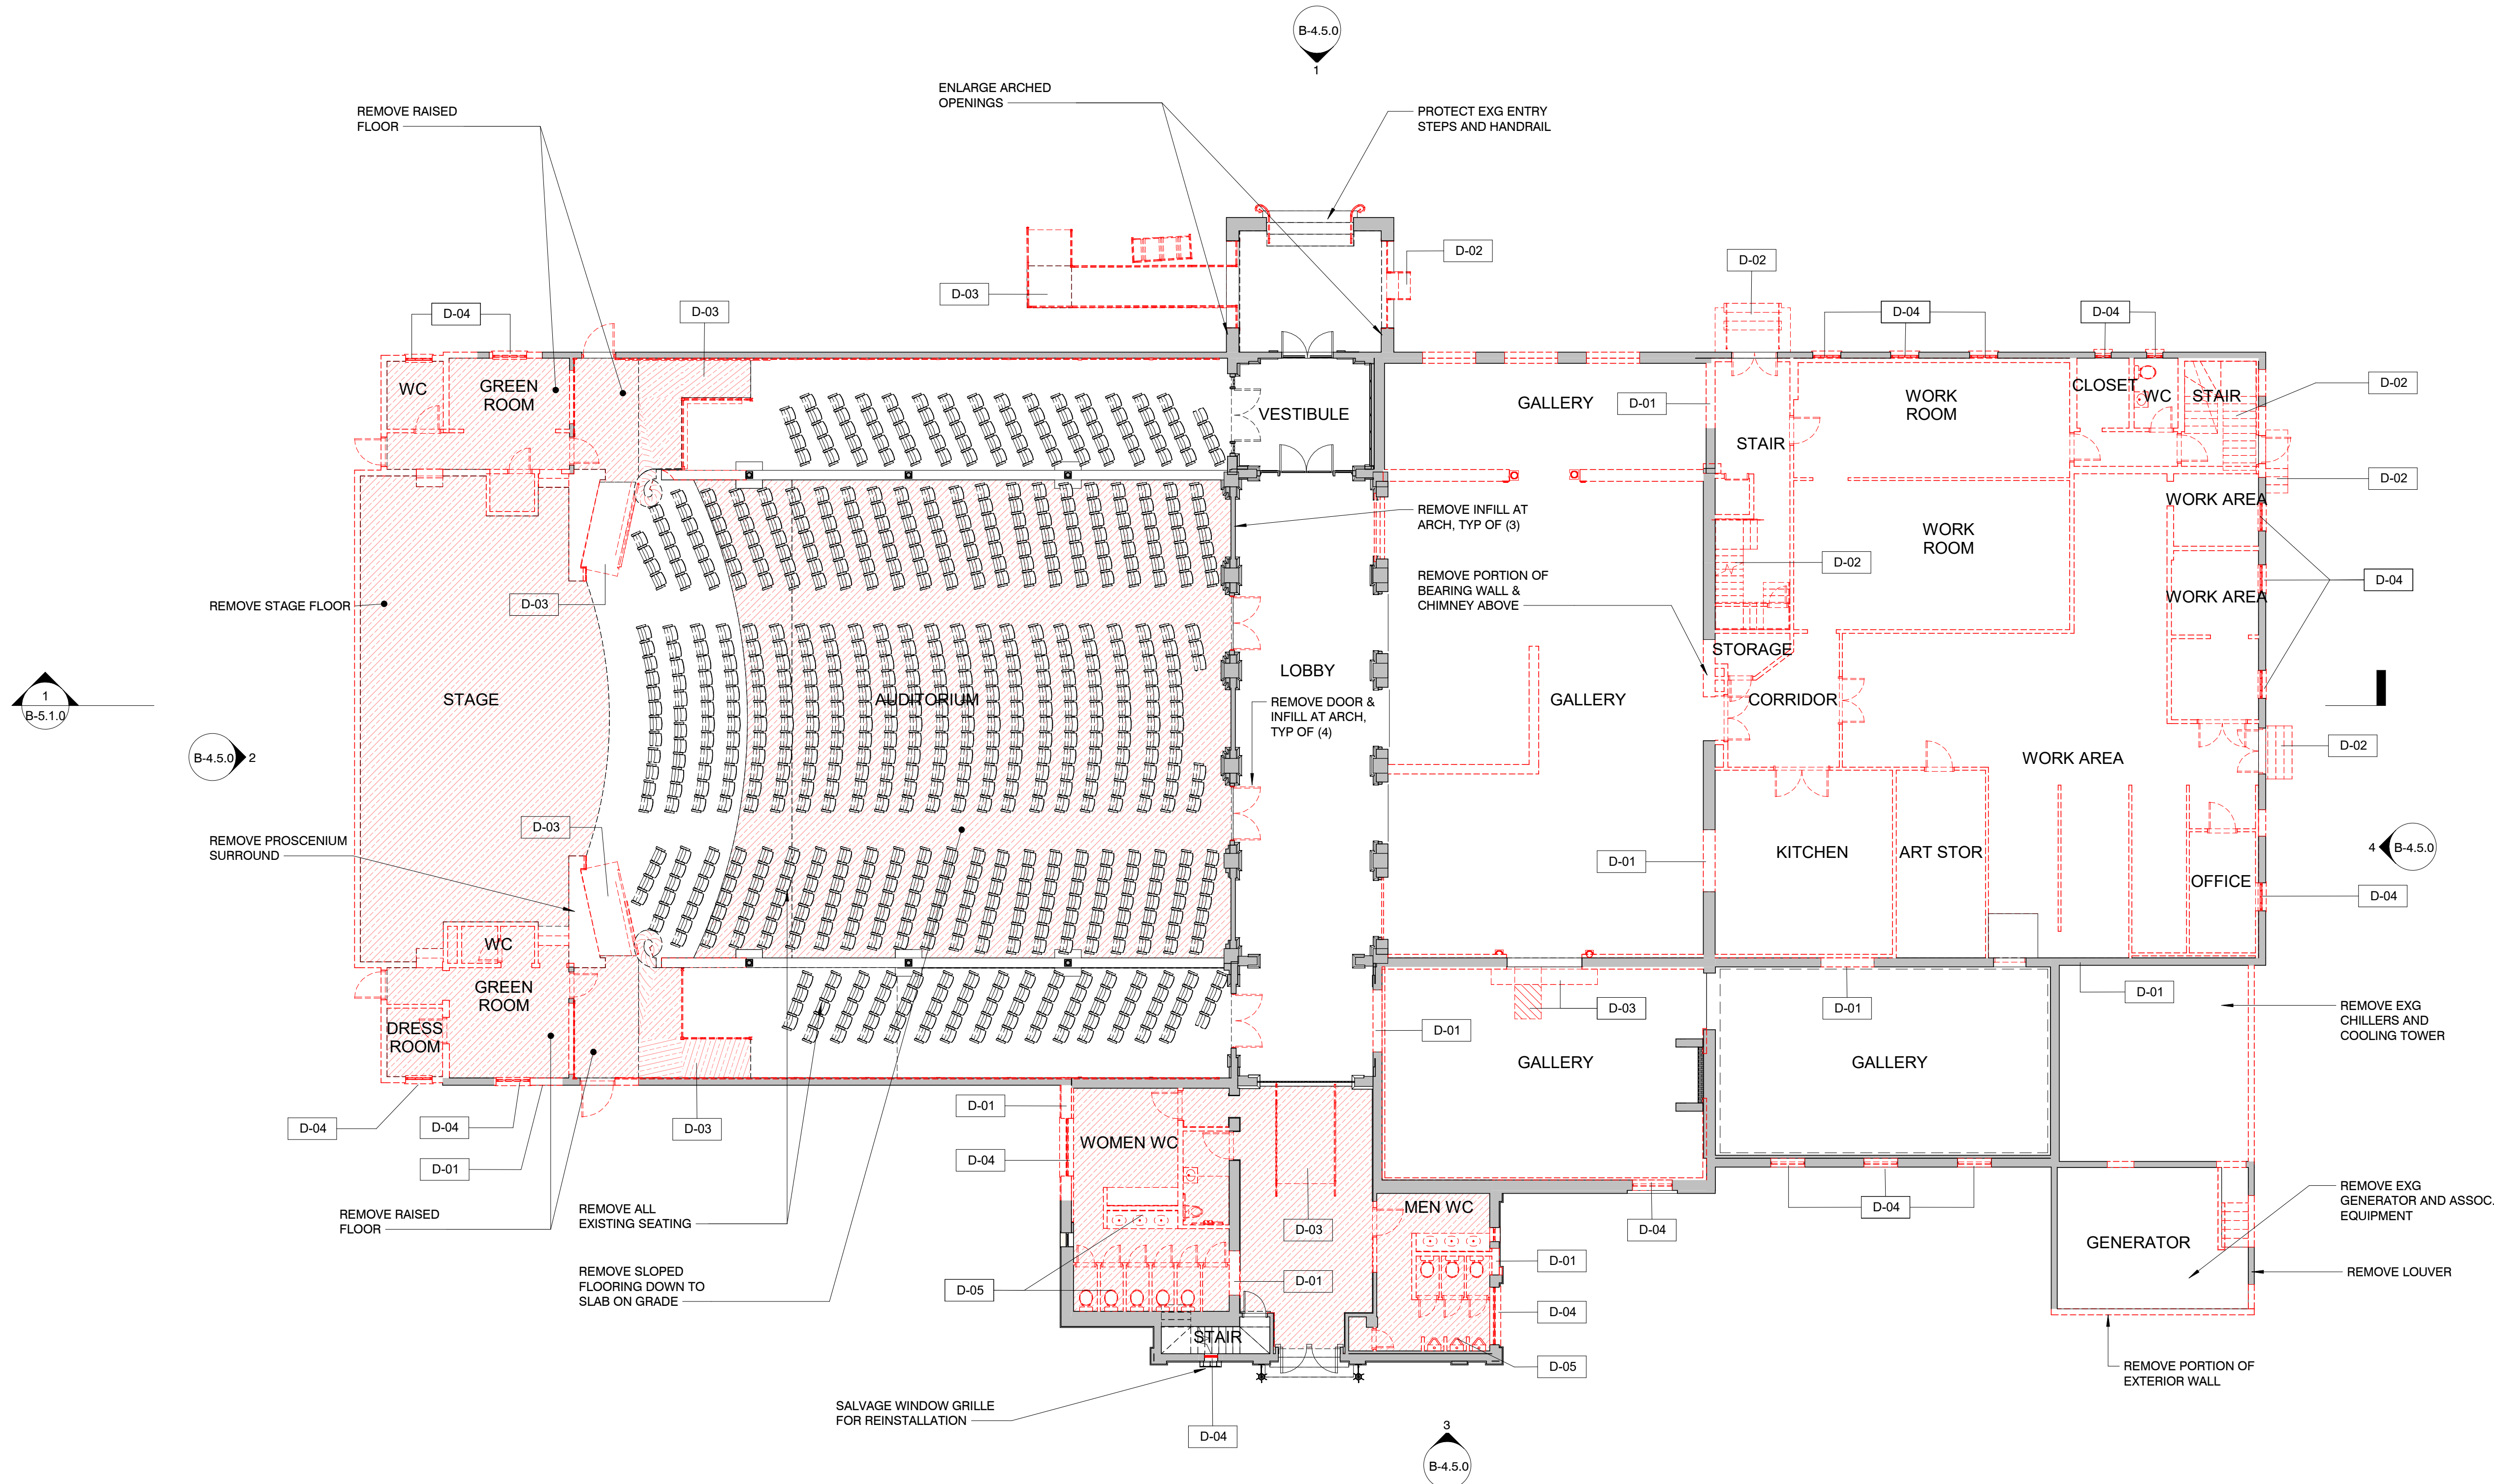

1 FIRST FLOOR MATERIAL REMOVAL PLAN
B-2.1.3 3/32" = 1'-0"

LEGEND

- EXISTING CONSTRUCTION TO REMAIN
- EXISTING WALL CONSTRUCTION TO BE REMOVED
- EXISTING SLAB TO BE REMOVED
- EXISTING DOORS TO BE REMOVED

DEMOLITION & SALVAGE KEYNOTES

KEYNOTE	DESCRIPTION
D-01	REMOVE PORTION OF BEARING WALL FOR NEW OPENING.
D-02	REMOVE STAIR.
D-03	REMOVE RAMP & RAILINGS.
D-04	REMOVE WINDOW.
D-05	REMOVE ALL PLUMBING FIXTURES.

